



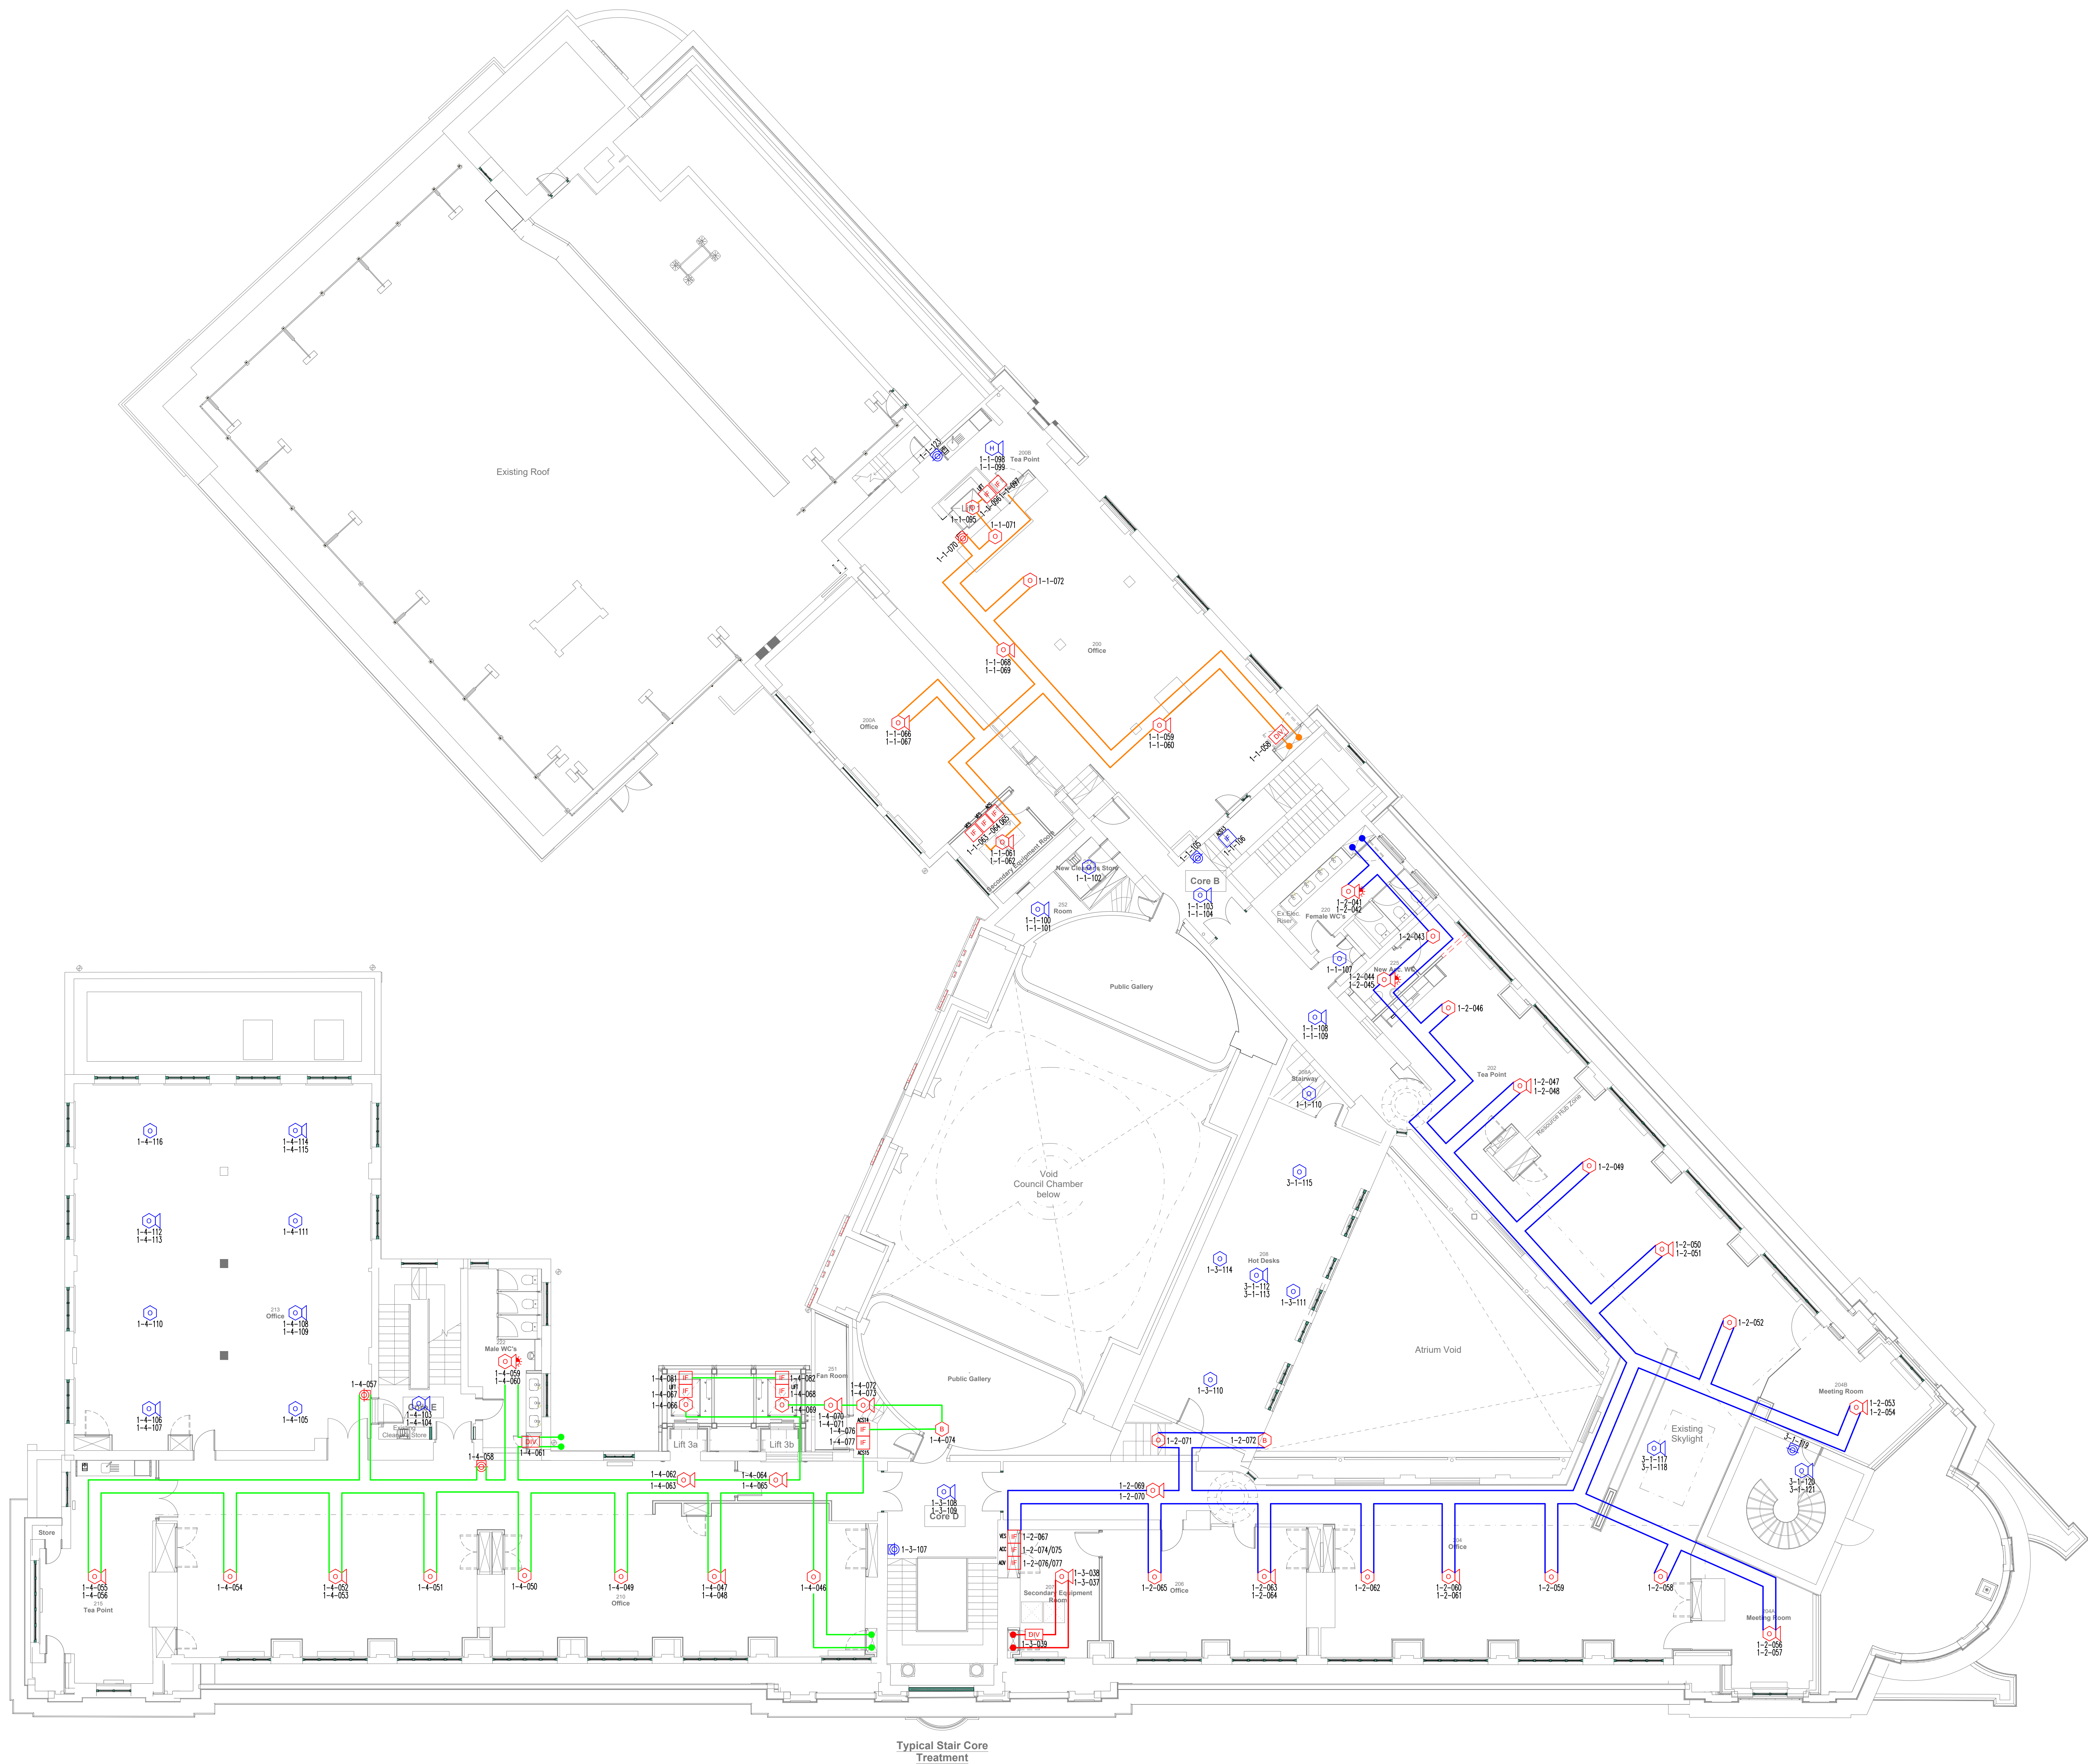

ADVANCED DEVICE ADDRESS FORMAT

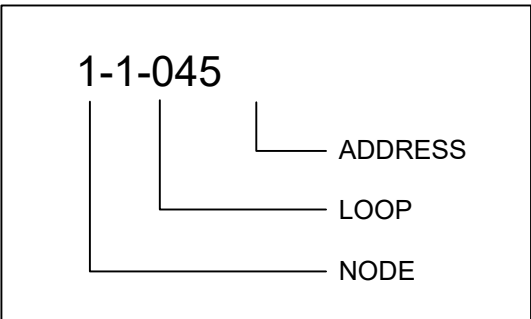

LEGEND

- Fire alarm panel
- Fire alarm repeater panel
- Red break glass unit/manual call point
- Smoke detector types - (X - denotes type)
 - Optical
 - Heat
 - Smoke detector with an integral sounder
 - Smoke detector with visual alarm device
 - Smoke detector with sounder and visual alarm device
- Aspiration detector with PSU & Interface
- Aspiration pipework
- Aspiration point
- Fire alarm interface
- Fire alarm sounder
- Fire alarm sounder/visual alarm device combined
- Visual alarm device
- Diversity unit
- Wireless break glass unit/manual call point
- Wireless smoke detector types - (X - denotes type)
 - Optical
 - Heat
 - Wireless smoke detector with an integral sounder
 - Wireless smoke detector with visual alarm device
 - Wireless smoke detector with sounder and visual alarm device
 - Wireless fire alarm sounder/visual alarm device combined
- ACS Access control system interface
- FC Fire curtain interface
- LIFT Lift interface
- MCC Motor control centre
- SPK Sprinkler interface
- Cable loop 1
- Cable loop 2
- Cable loop 3
- Cable loop 4
- Cable loop 5
- Cable loop 6
- Cable loop 7
- Repeater circuit

A0 ORIGINAL SIZE DRAWING

AI	AS INSTALLED	AJO	15.01.18
No.	REVISION	BY	DATE

minerva fire
Minerva Fire Ltd
St. Georges House
8 St. Georges Way
Leicester
LE1 1SH
Tel: 0116 201 4408

CLIENT
NG Bailey

PROJECT
Lambeth YNTH

TITLE
Fire Alarm System Layout
Town Hall
Level 02

DATE	09.09.16	SCALE	1:100 @ A0
DRAWN	PKW	CHECKED	AJO
CAD REF	30611-NGB-TH-02-DR-E-104		
DRAWING STATUS	As Installed		

DRAWING No.	MIN/NGB/LTH/FA/02	REVISION	AI
-------------	-------------------	----------	----