


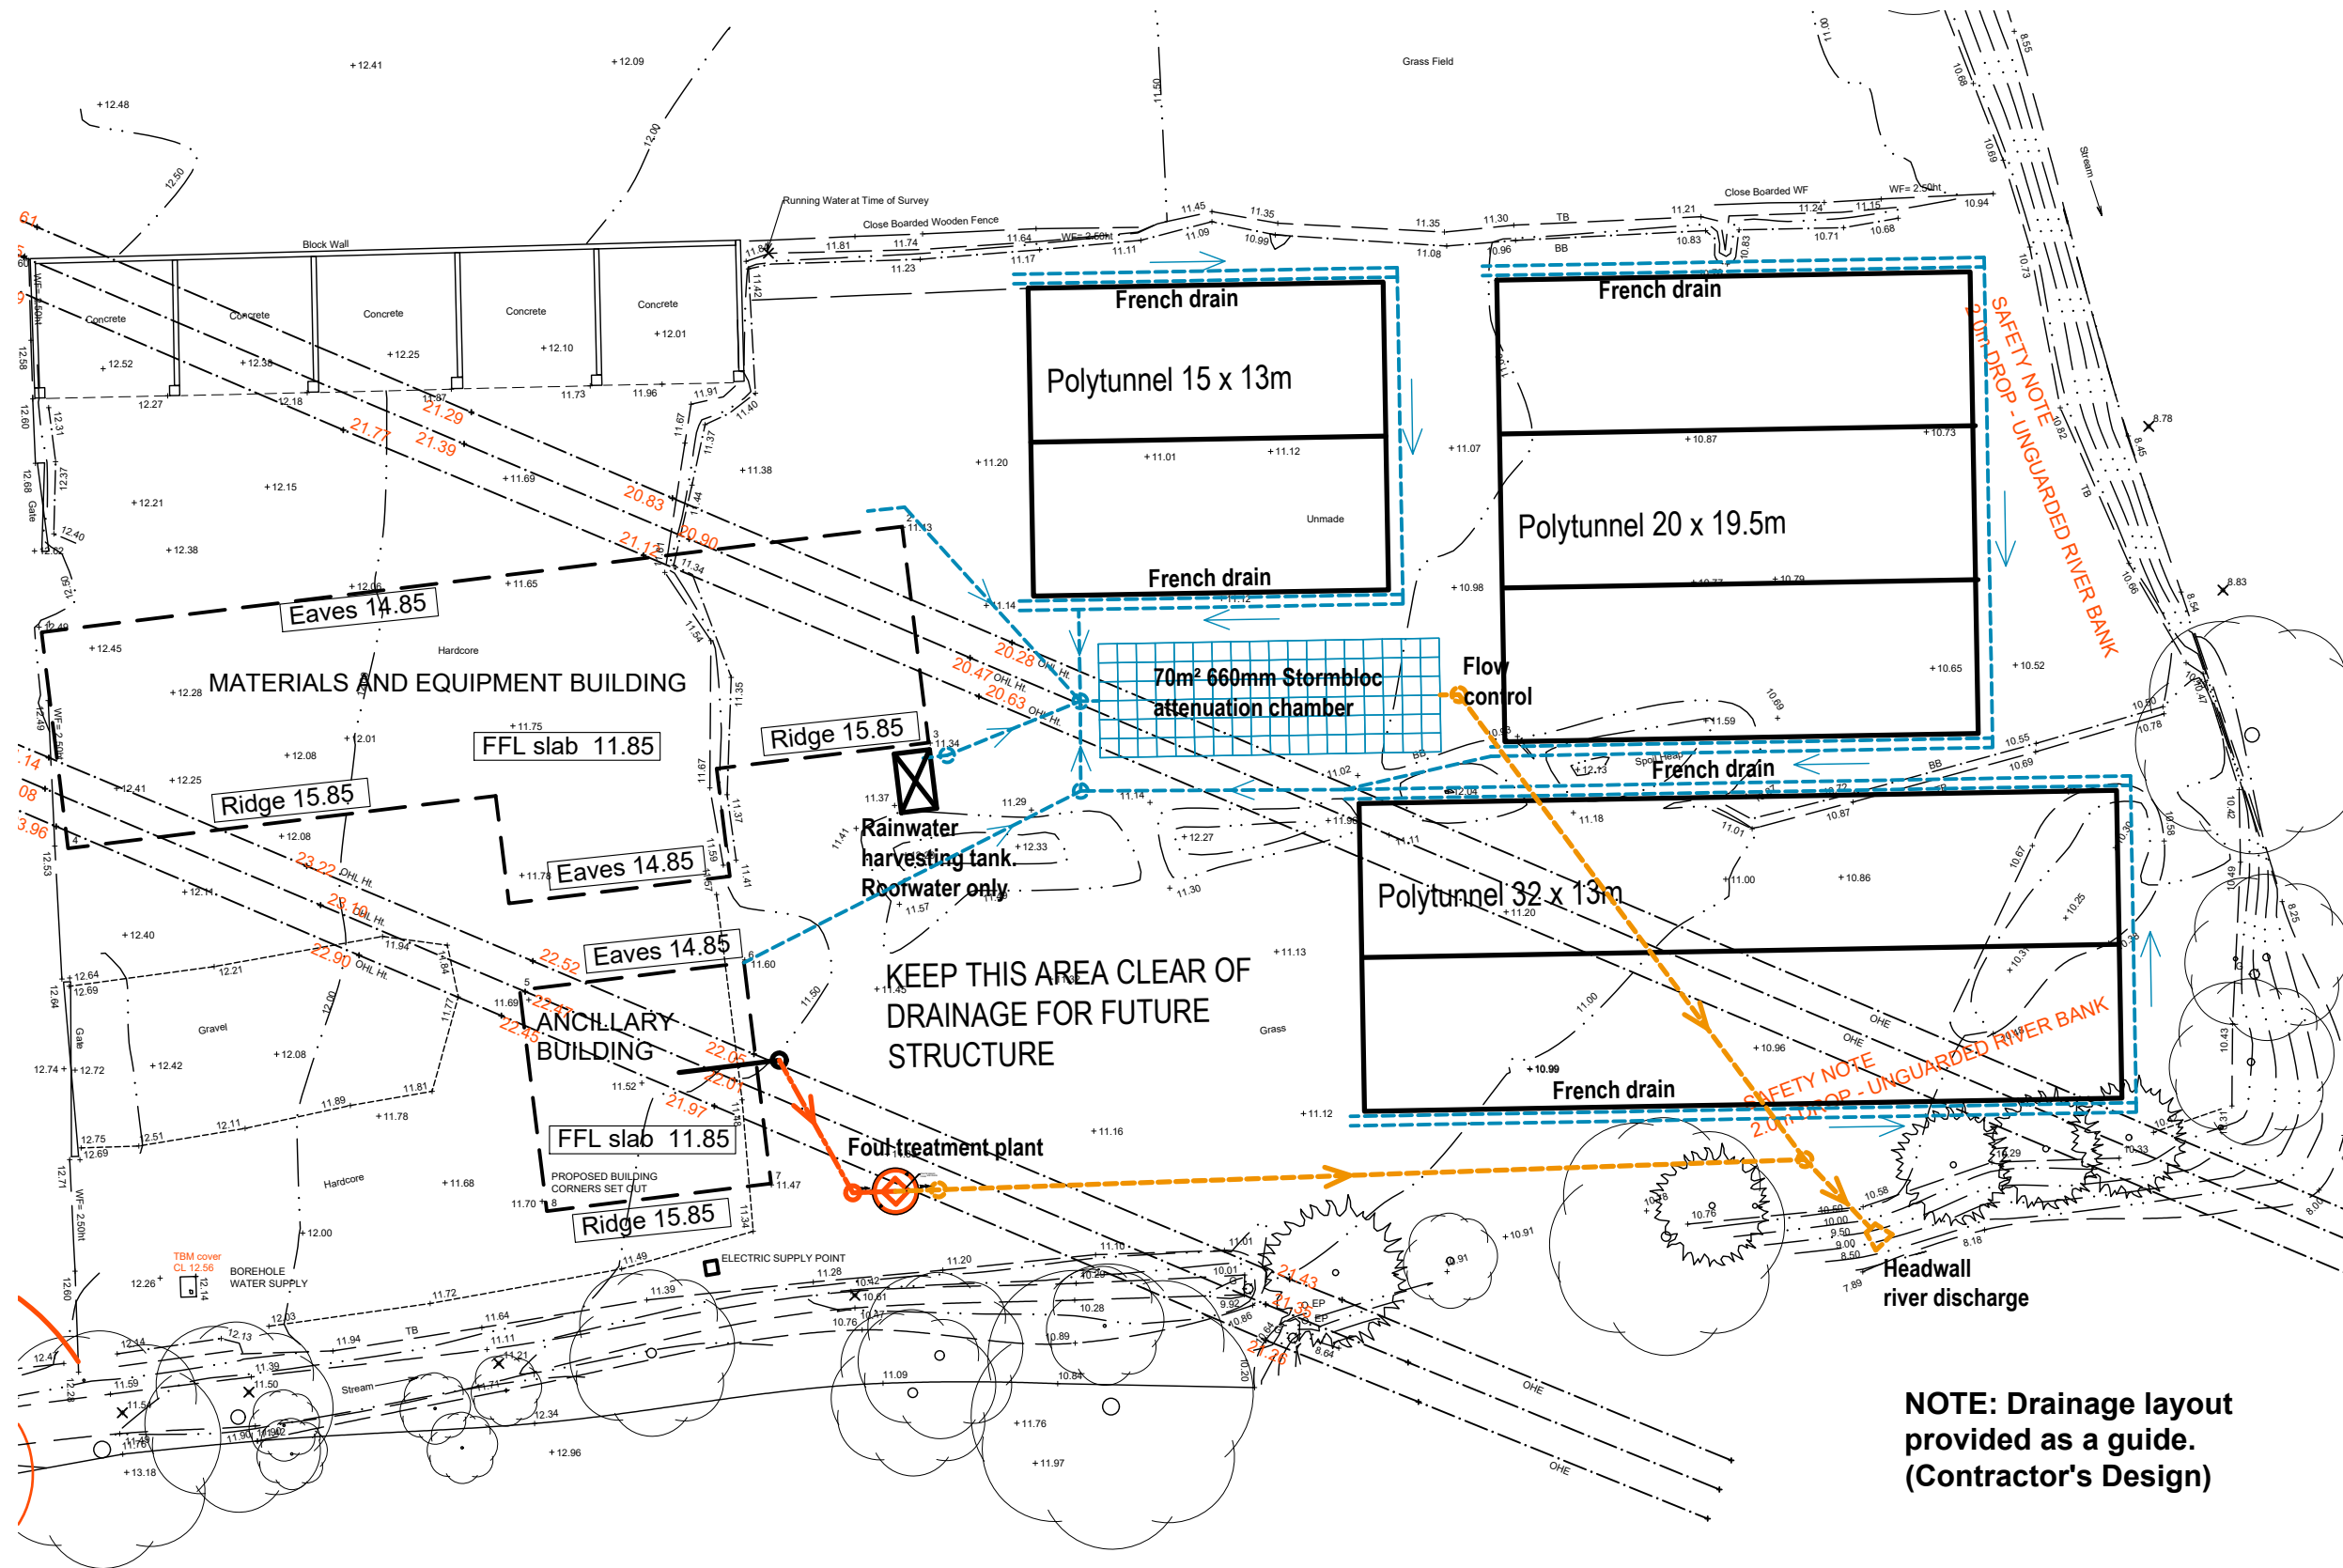

NOTE: Drainage layout provided as a guide. (Contractor's Design)

- +13 Foul drain
- French drain
- Surfacewater drain
- Modular attenuation chamber with controlled flow
- ⊗ Foul treatment plant
- ⊗ Above ground, rainwater harvesting tank. (Roofwater of main building only)
- Discharge drain
- ⚡ Headwall discharge

Topographic survey by Douglass Geomatics ref. DG19016-1-1.
TBM borehole cover level 12.560



LLOYDS Architecture 11 Kingsley Close, Truro, Cornwall, TR1 XJ 07875 481 919 mail@lloydsarchitecture.co.uk www.lloydsarchitecture.co.uk www.ciat.org.uk		PROJECT PROPOSED HORTICULTURAL NURSERY, IDLESS, TRURO		Client Truro City Council		
		Scale: (A3) 1:300		Drawing DRAINAGE AND POLYTUNNELS		
		Date 07-20	Project No. 18002	Drg. No. 104	Rev. A	