


This document and its contents are the property of the Purchaser/employer and Crooks Water Consulting. They may not be copied or reproduced in any way, in part or whole, without prior written approval of both parties. Visitors are asked to sign in upon arrival. This document and its contents are to be used in connection with the Civil Engineering and / or Electrical Specification(s). DO NOT SCALE FROM THIS DRAWING

DESIGNERS RISK ASSESSMENT
GENERAL PRINCIPLES OF RISK SPECIFICATION FOR DESIGNERS RISK ASSESSMENT SCHEDULE

DRAWING BACKGROUNDS:

ARCHITECTS: CROSBY_CAD FILE NOVEMBER 2016_1B

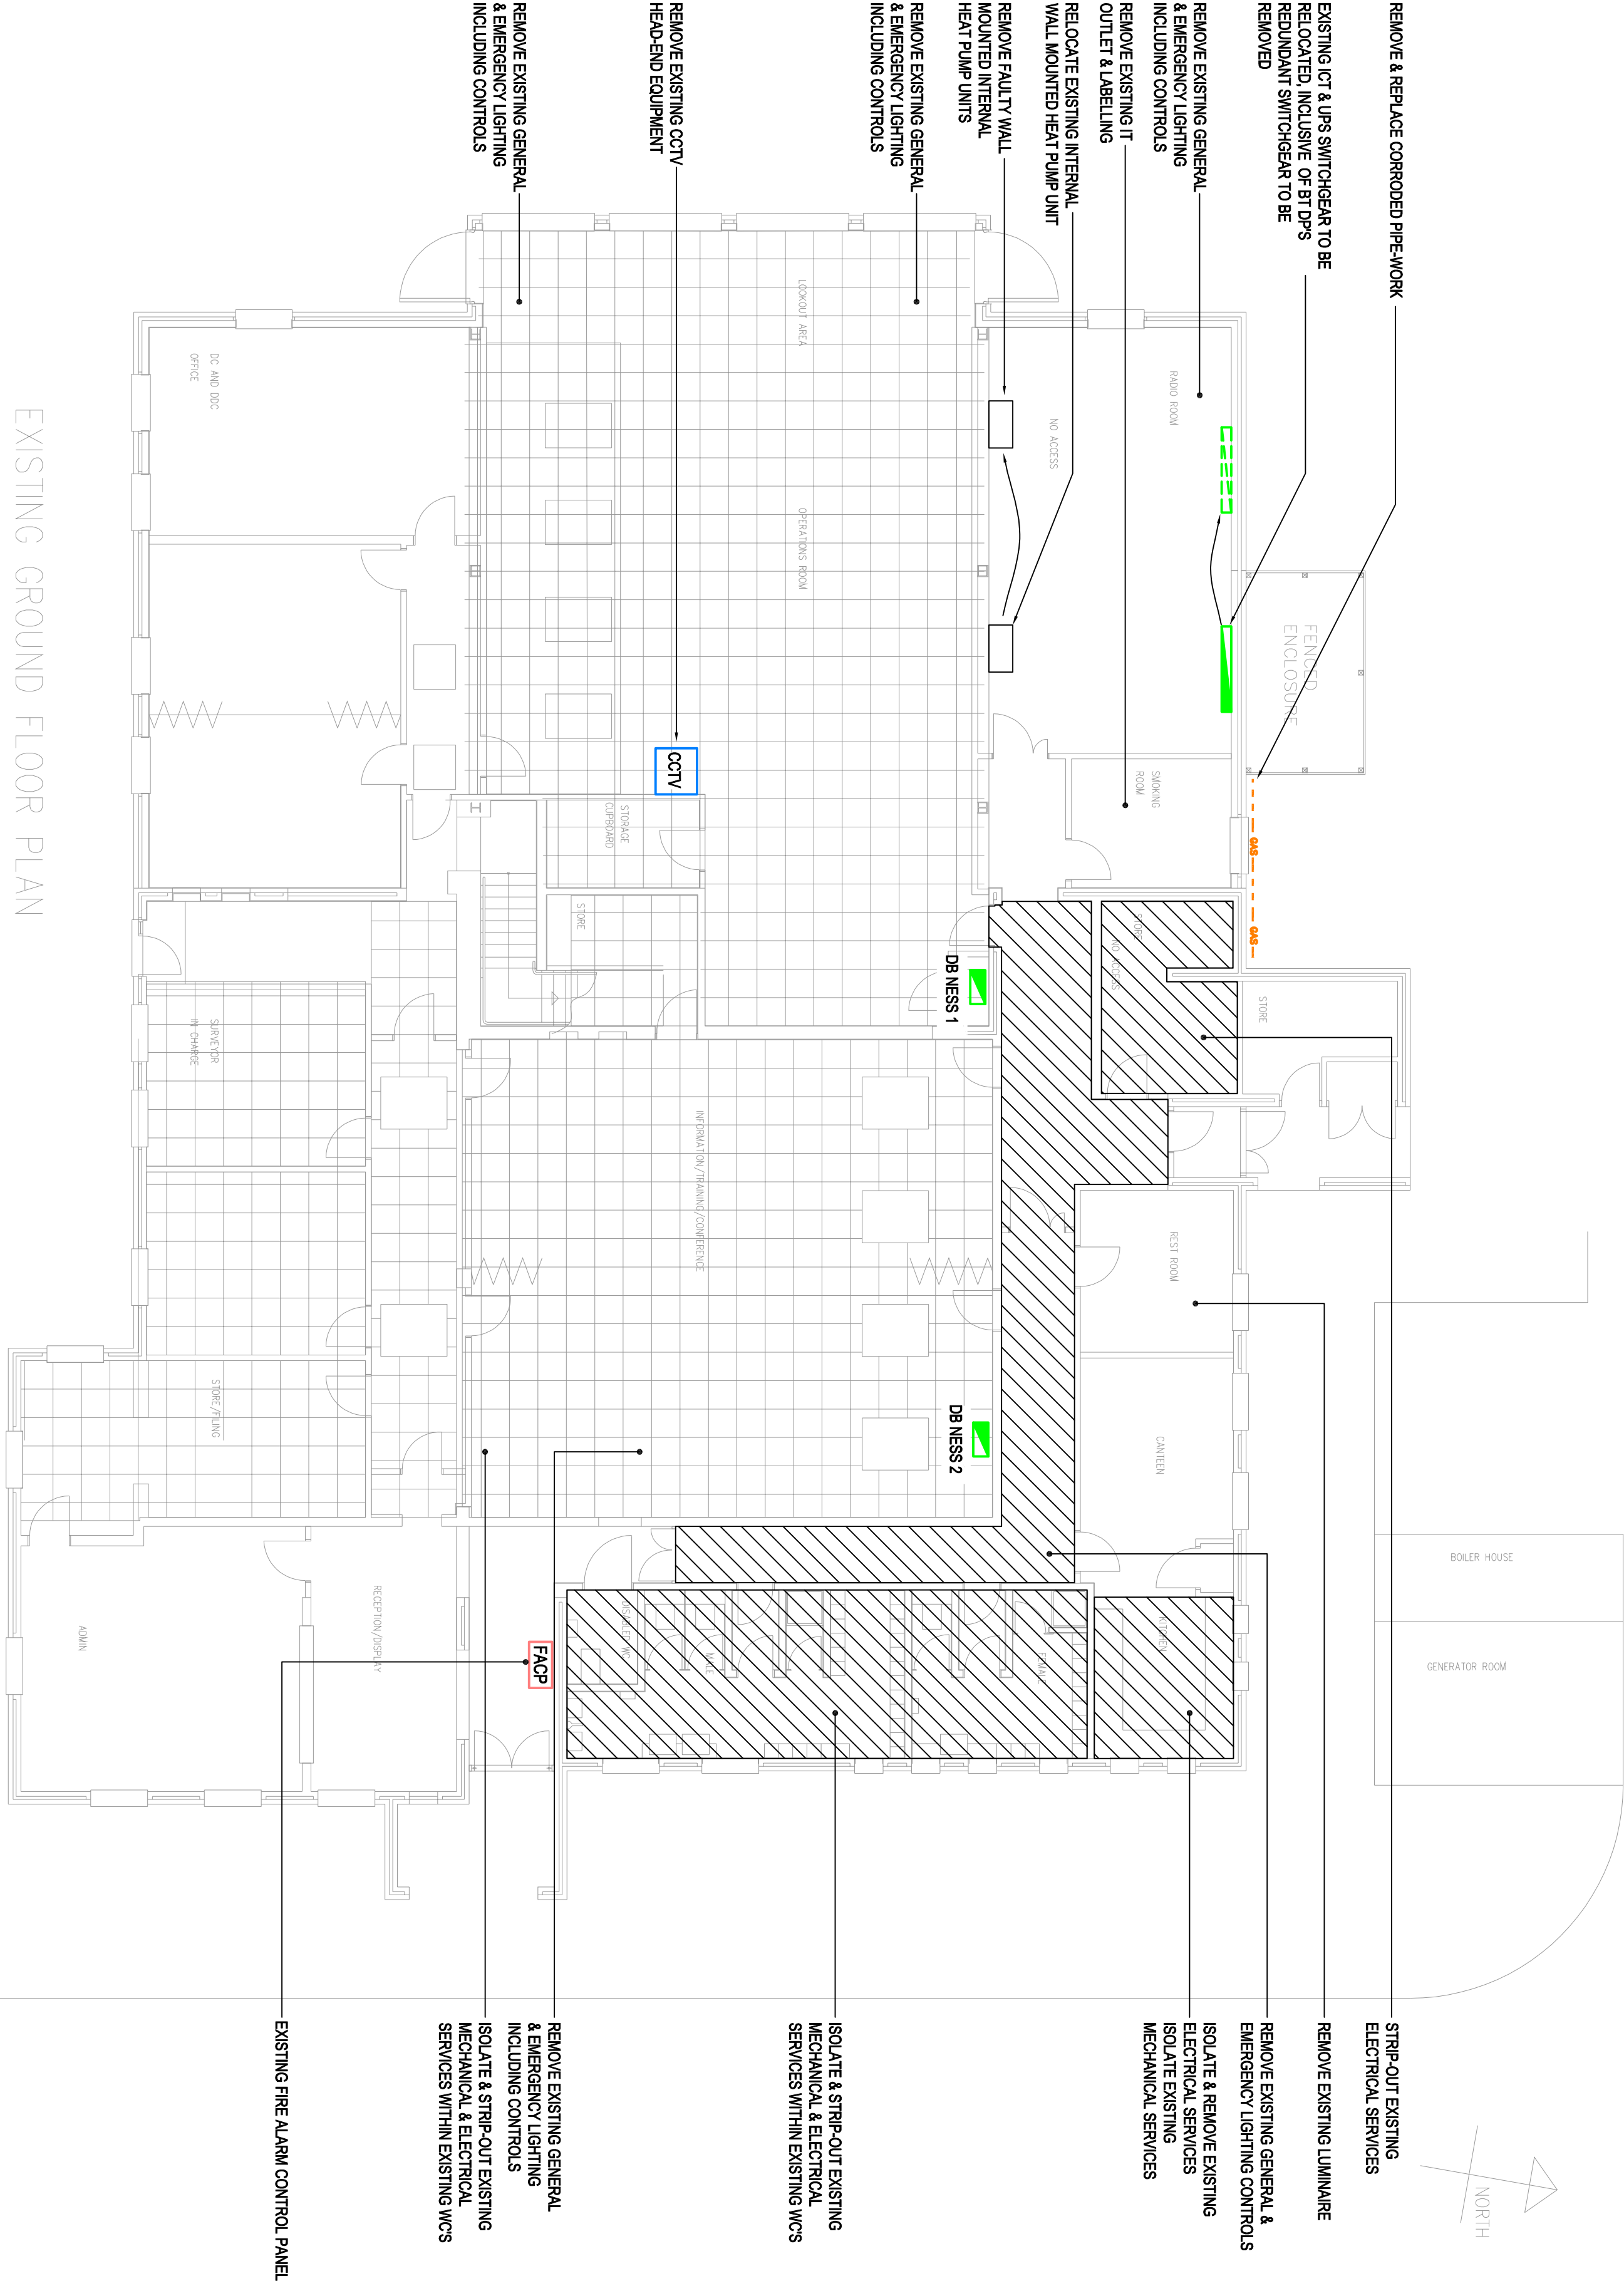

EXISTING GROUND FLOOR PLAN


EXISTING FIRE ALARM CONTROL PANEL

REMOVE EXISTING GENERAL & EMERGENCY LIGHTING INCLUDING CONTROLS
ISOLATE & STRIP-OUT EXISTING MECHANICAL & ELECTRICAL SERVICES WITHIN EXISTING WCS

ISOLATE & STRIP-OUT EXISTING MECHANICAL & ELECTRICAL SERVICES WITHIN EXISTING WCS

REMOVE EXISTING LUMINAIRE
REMOVE EXISTING GENERAL & EMERGENCY LIGHTING CONTROLS
ISOLATE & REMOVE EXISTING ELECTRICAL SERVICES
ISOLATE EXISTING MECHANICAL SERVICES

STRIP-OUT EXISTING ELECTRICAL SERVICES

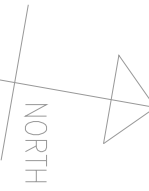

T1	20.12.18	ISSUED FOR TENDER	CSL JLM
Rev	Date	Description	Eng/CHK
CWC Crooks Water Consulting The Plaza, Old Hall Street, Liverpool L3 9QU Tel: 0151 680 5409 E-mail: admin@cwcon.co.uk Website: www.cwcon.co.uk			
Attention House, 30 St Mary's Parsonage Manchester M3 2NU Tel: 0161 624 9929			

mca
Maritime and Coastguard Agency

Project
**HM COASTGUARD
HALL ROAD WEST
CROSBY
LIVERPOOL L23 8SY**

Drawing Title
**EXISTING GROUND FLOOR
M&E STRIP-OUT**

Status
TENDER ISSUE

Project No.
1752

Drawn
MJF

Scale / Paper Size
1:100 @ A1

Drawing No.
1752-GF-6101

Rev
T1