


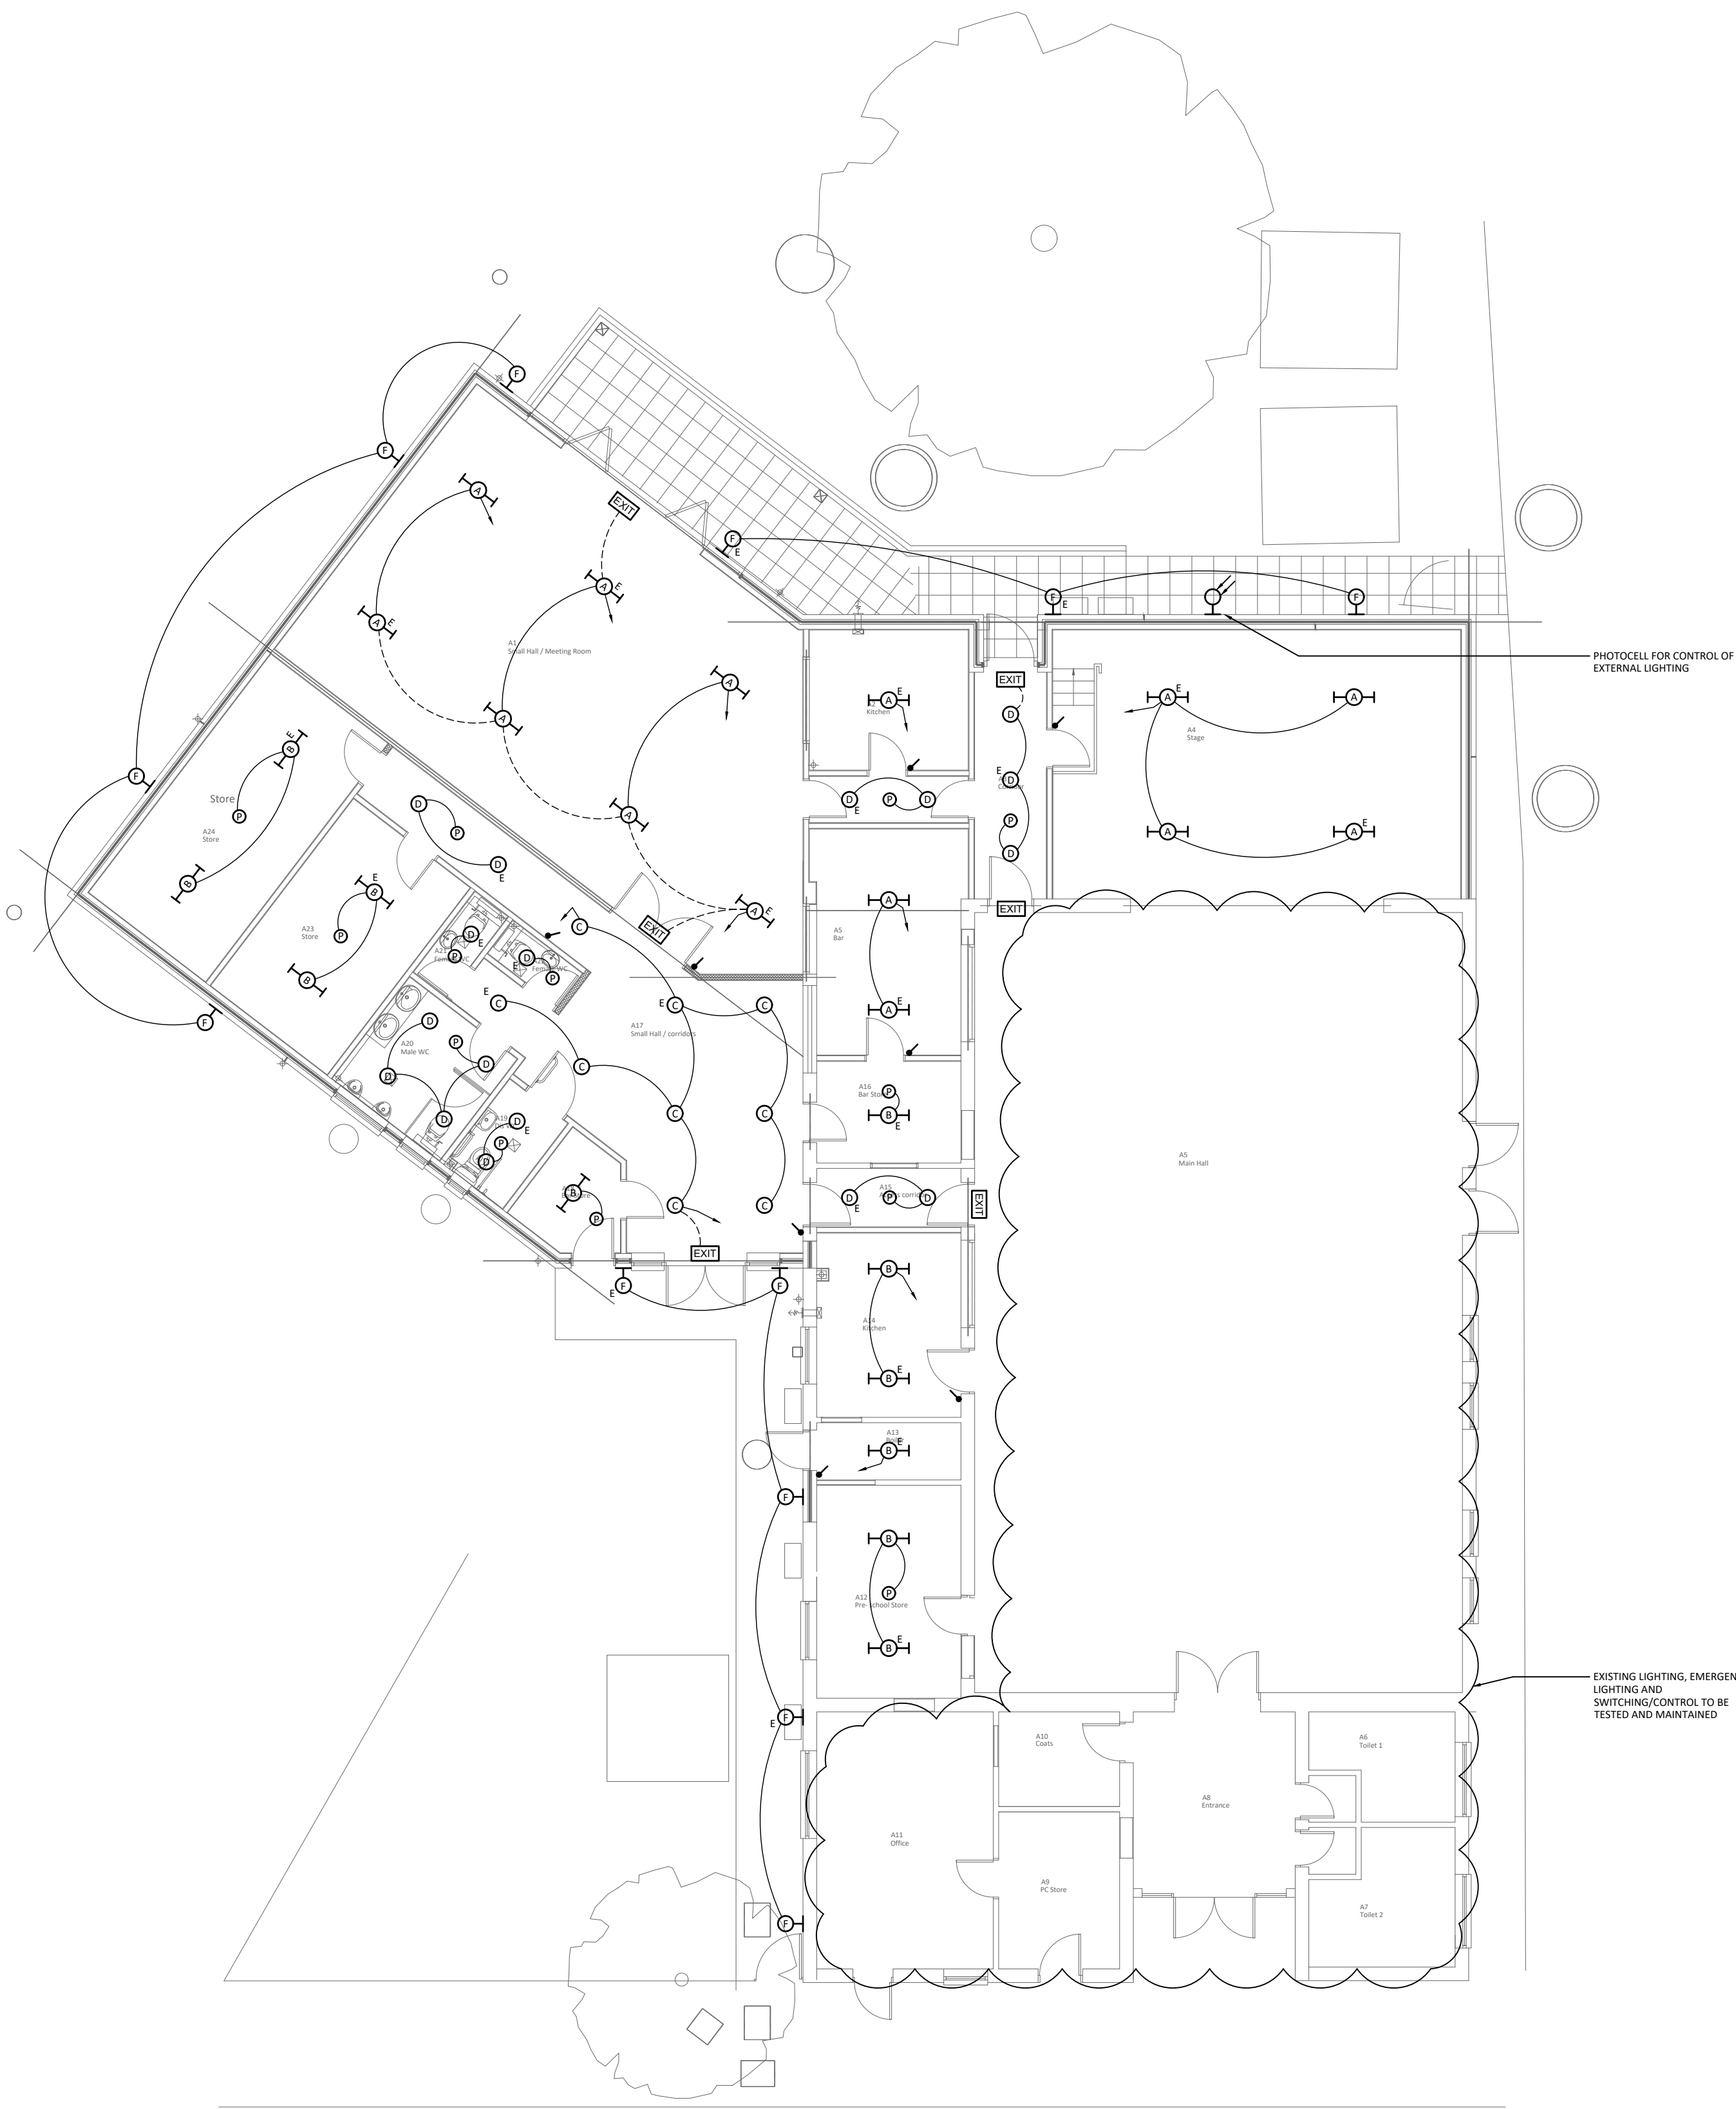

No dimensions are to be scaled from this drawing.
All dimensions are to be checked on site, where
discrepancy occurs between specification and
drawings the supervising officer must be notified.

NOTES:

1. THIS DRAWING SHALL BE READ IN CONJUNCTION WITH THE SPECIFICATION.
2. ALL SETTING OUT ARE TO BE CONFIRMED BY THE ARCHITECT.
3. ANY DISCREPANCIES ARE TO BE REPORTED TO THE ENGINEERS.

LEGEND:

Amendments:

T	TENDER ISSUE	24.01.20
P	PRELIMINARY ISSUE	14.10.19

Drawing type:
TENDER

Client:
LEYBOURNE PARISH COUNCIL

Project:
LEYBOURNE VILLAGE HALL
KENT, ME19 5QL

Title:
LIGHTING LAYOUT

Scale: 1:100 @A1 Date: JAN 2020

Drawn: F.T. Checked: M.J.

Drg.no:128316-E-300

Rev: T

Watts.

Watts Group Limited

1 Great Tower Street

London EC3R 5AA

T: 020 7280 8000

watts.co.uk