


# PROPOSED INDICATIVE VENTILATION CHANGES

**Project: Environment Agency, Leeds**  
**DRG Ref: M04**  
**Scale: NTS**

## First Floor Plan

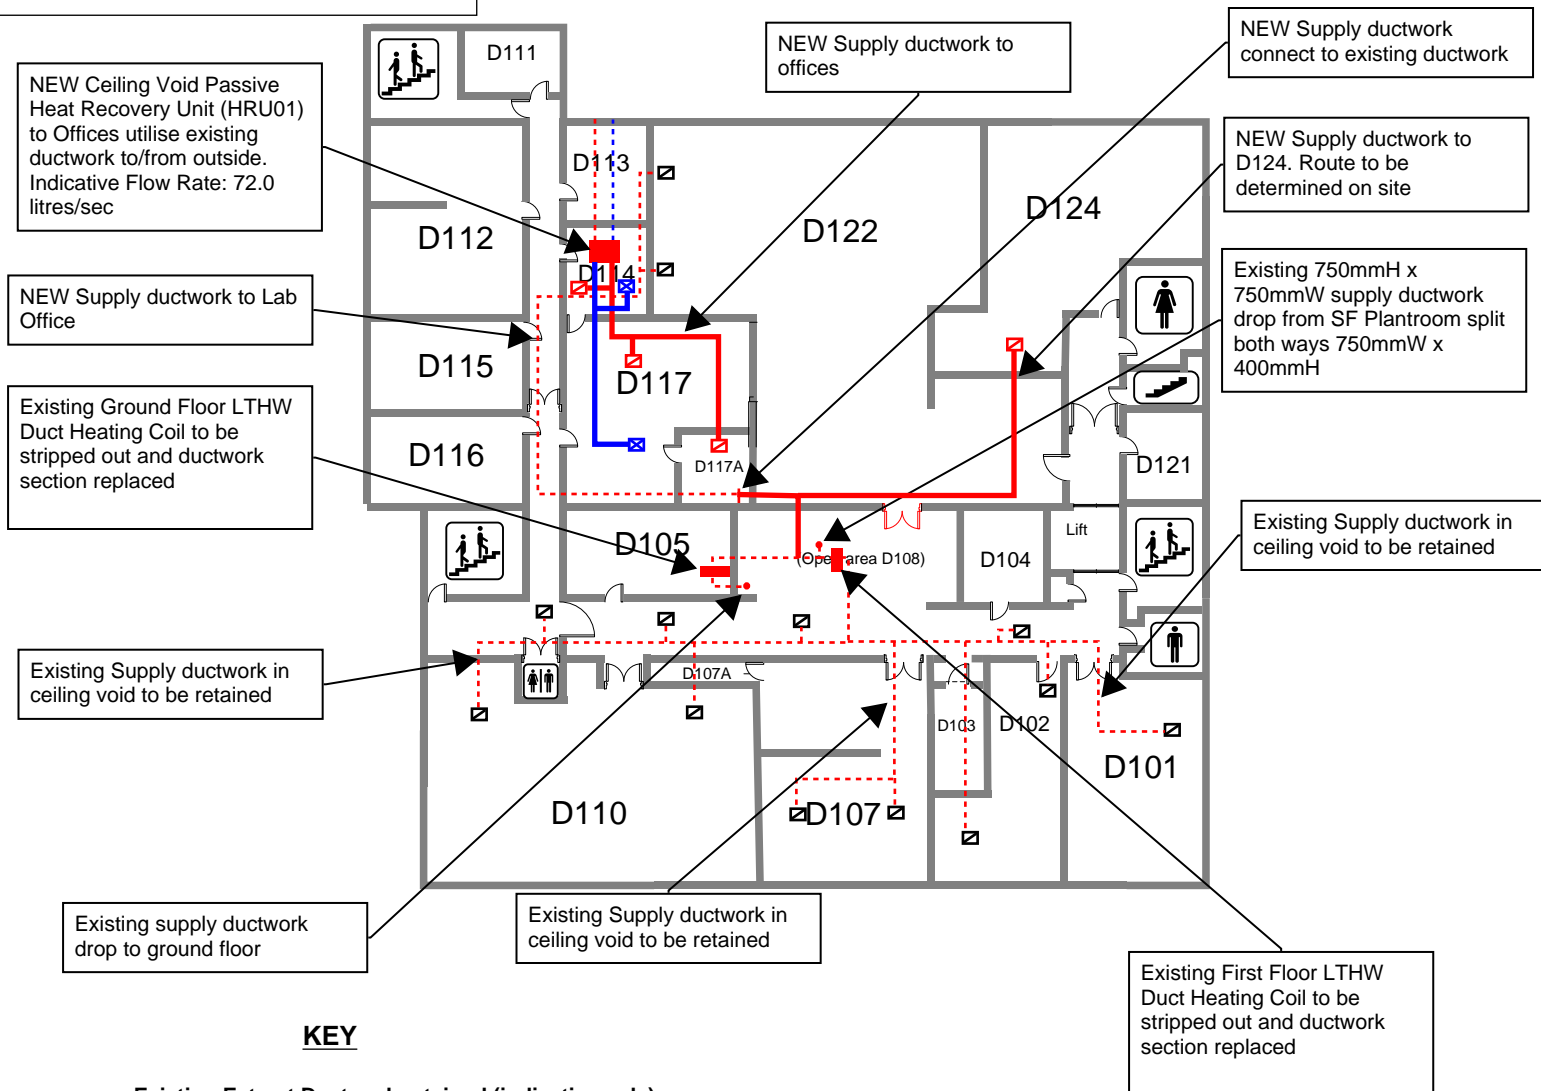

### KEY

- Existing Extract Ductwork retained (indicative only)
- Existing Supply Ductwork retained (indicative only)
- /// Strip Out Works (indicative only)
- NEW Extract Ductwork retained (indicative only)
- NEW Supply Ductwork retained (indicative only)
- Existing Supply Grille to be replaced with NEW 4 Way Diffuser c/w OBD (indicative only)
- ⊠ Existing Extract Grille to be replaced with NEW Eggcrate Grille c/w OBD (indicative only)
- NEW 4 Way Diffuser (indicative only)
- ⊠ NEW Eggcrate Grille (indicative only)

