


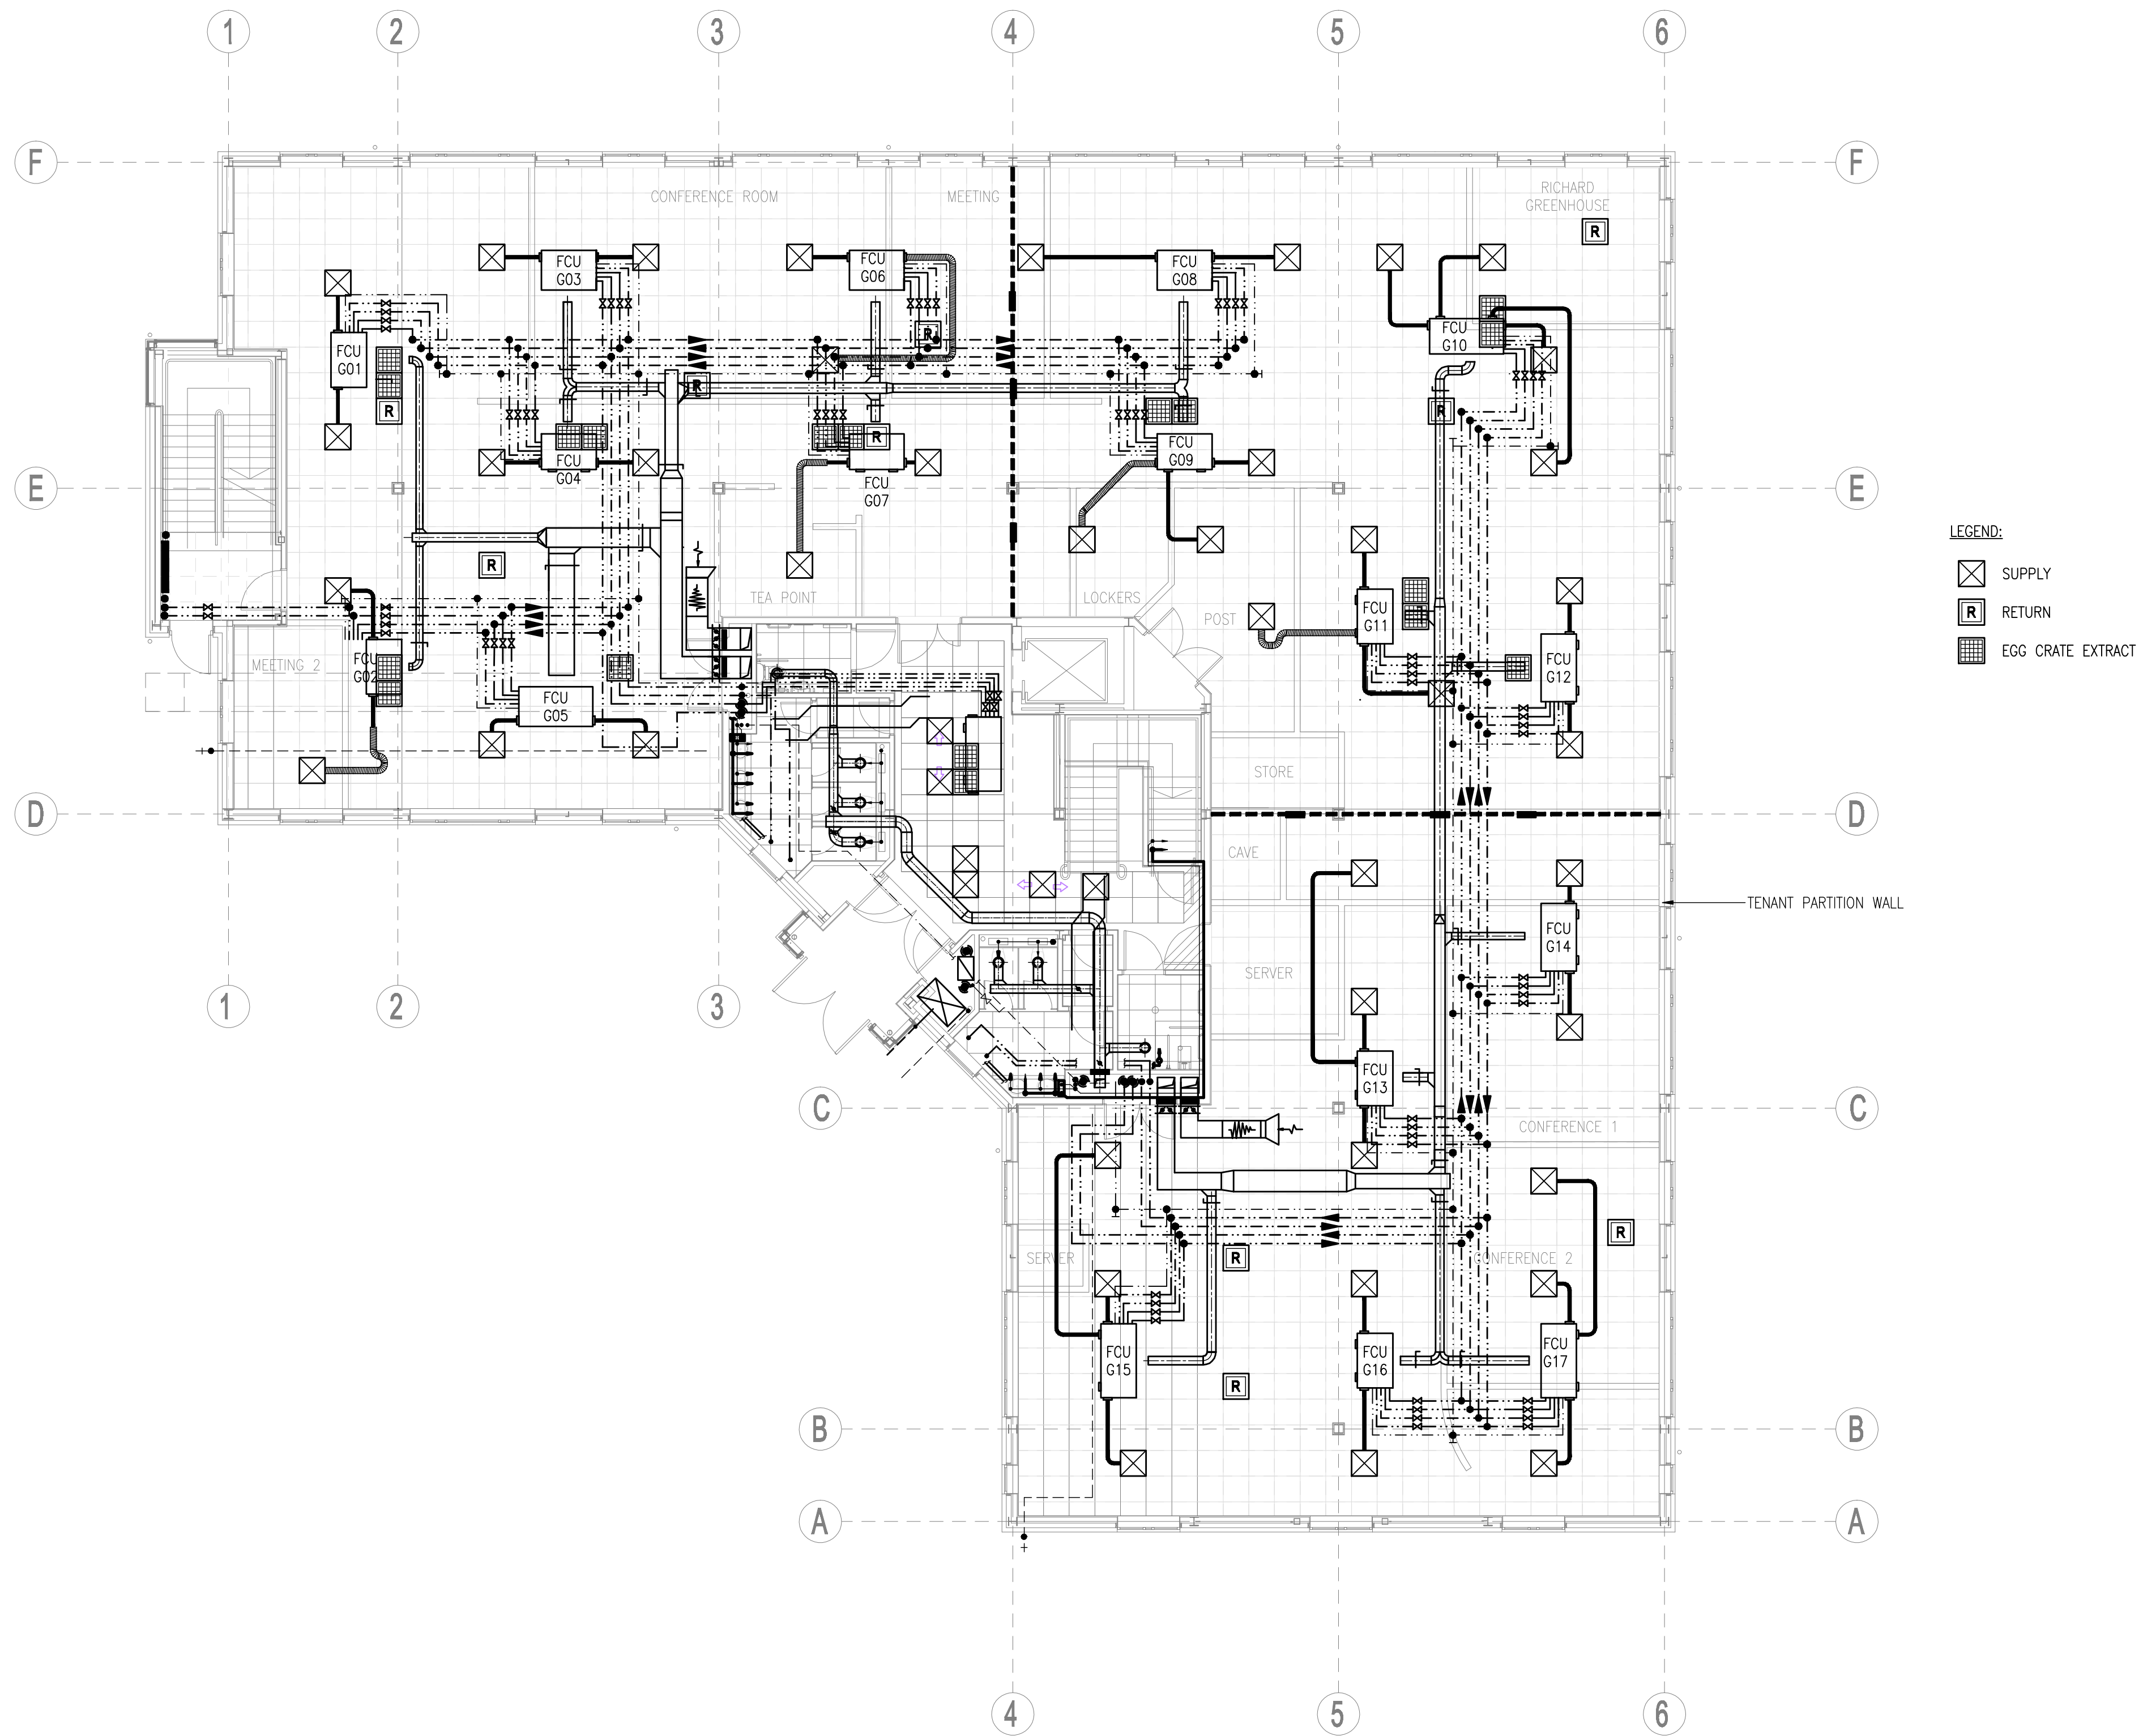

NOTES:

FORESTRY COMMISSION
620 BRISTOL BUSINESS PARK
BRISTOL

The Brodie Partnership
Building Services Consulting Engineers

Unit 4, Knightsbridge Court
North Street, Downend
Bristol, BS16 5SF
Tel: 0117 957 0554
Fax: 0117 957 2350
E-mail: post@brodiepartnership.co.uk

GROUND FLOOR
EXISTING HVAC LAYOUT

1521

M-10

T1

SCALE: 1:100

MAY 16

SIZE: A1