


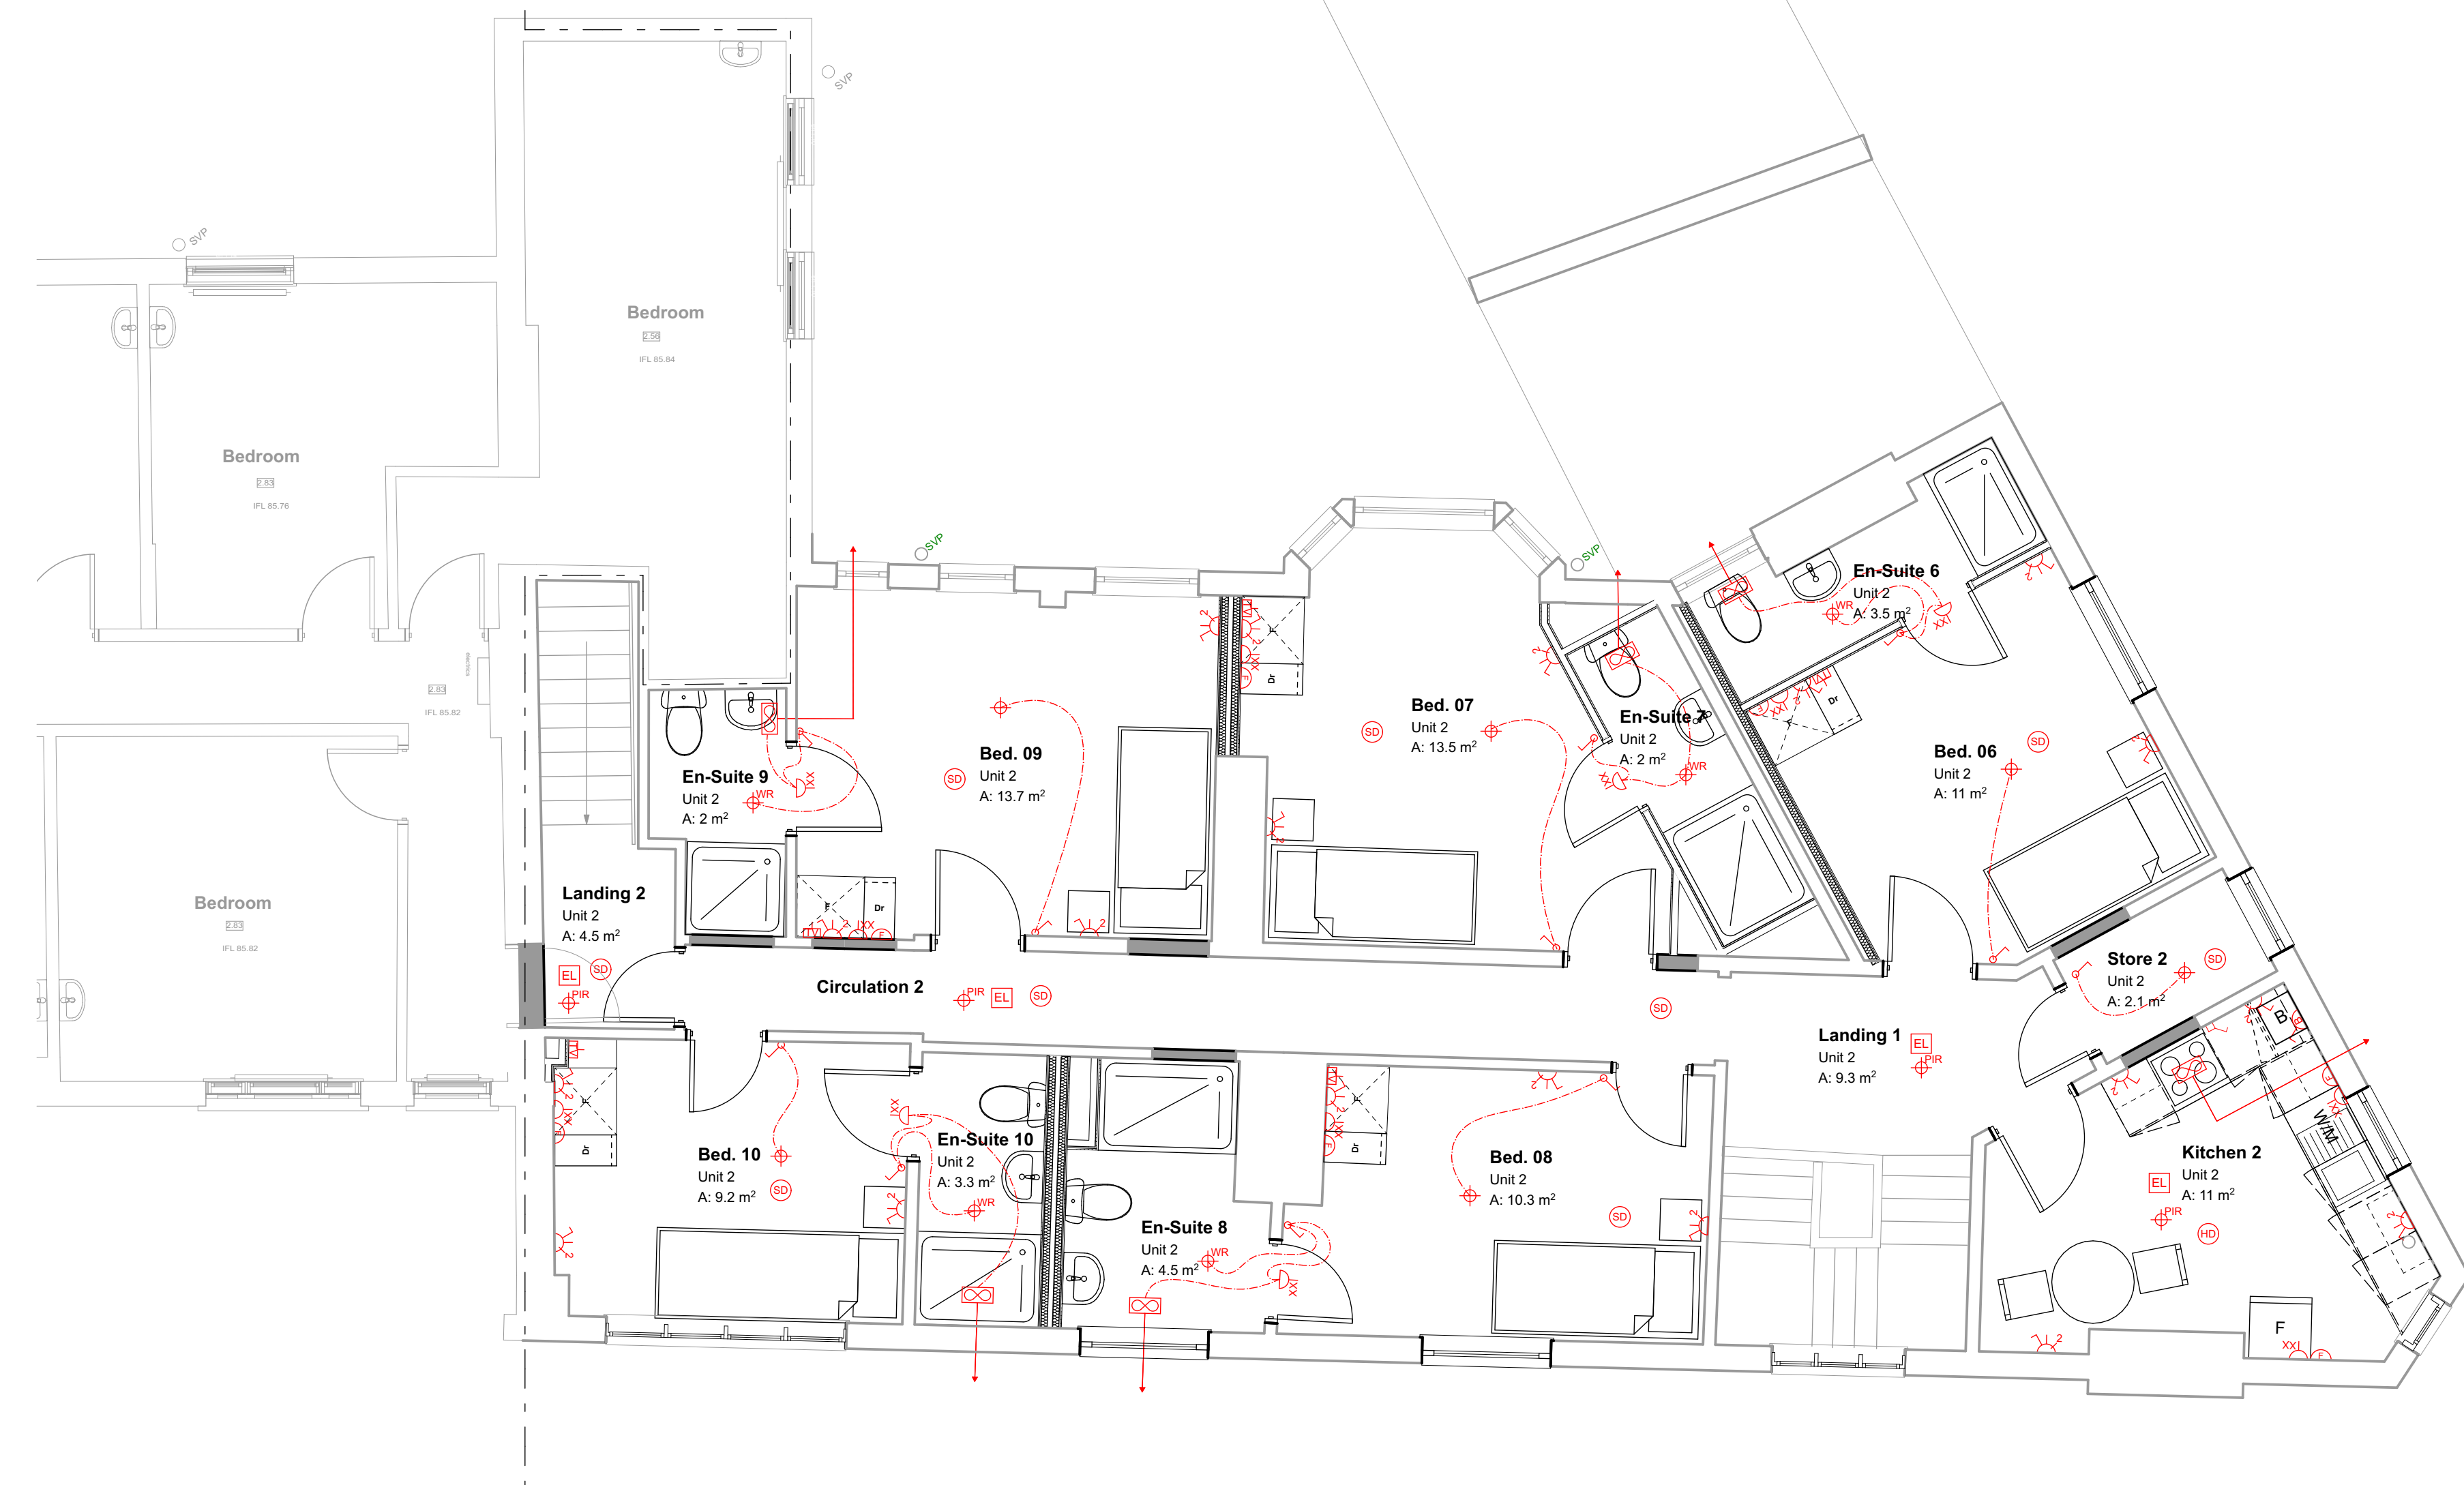

Scale: 1:50

Note: Electrical layouts are indicative only of provision. Exact locations of all outlets and equipment to be confirmed by Client. Specification and design of all electrical and mechanical services by specialist.
All light fittings to be LED unless otherwise specified.



Source File:
A77-6 26 Action Homeless Leicester 20231017 Onwards.pln

<div><p>ACTION HOMELESS The chance for change</p></div>		
<div><div></div><div><p>1 Millers Yard Roman Way Market Harborough Leicestershire LE16 7PW</p><p>1 : 01858 464986 brp-architects.com</p></div></div>		
Client Action Homeless		
Project Title Proposed Alterations Mayfield House, St James Terrace / Mayfield Road, Leicester		
Drawing Title First Floor Indicative M&E Layout 2 of 2		
Drawing Status Tender		
Scale(s) 1:50		Original Paper Size: A1
Drawn By KRJ	Checked By (if file copy only)	Date: 28.06.2024
Document Reference: A77-BRP-00-01-DR-A-2404-T01		



Project Title	Proposed Alterations Mayfield House, St James Terrace / Mayfield Road, Leicester
Drawing Title	First Floor Indicative M&E Layout 2 of 2

Scale(s): 1:50		Original Paper Size: A1
Drawn By KRJ	Checked By (File copy only)	Date 28.06.2024

Document Reference:
A77-BRP-00-01-DR-A-2404-T01