


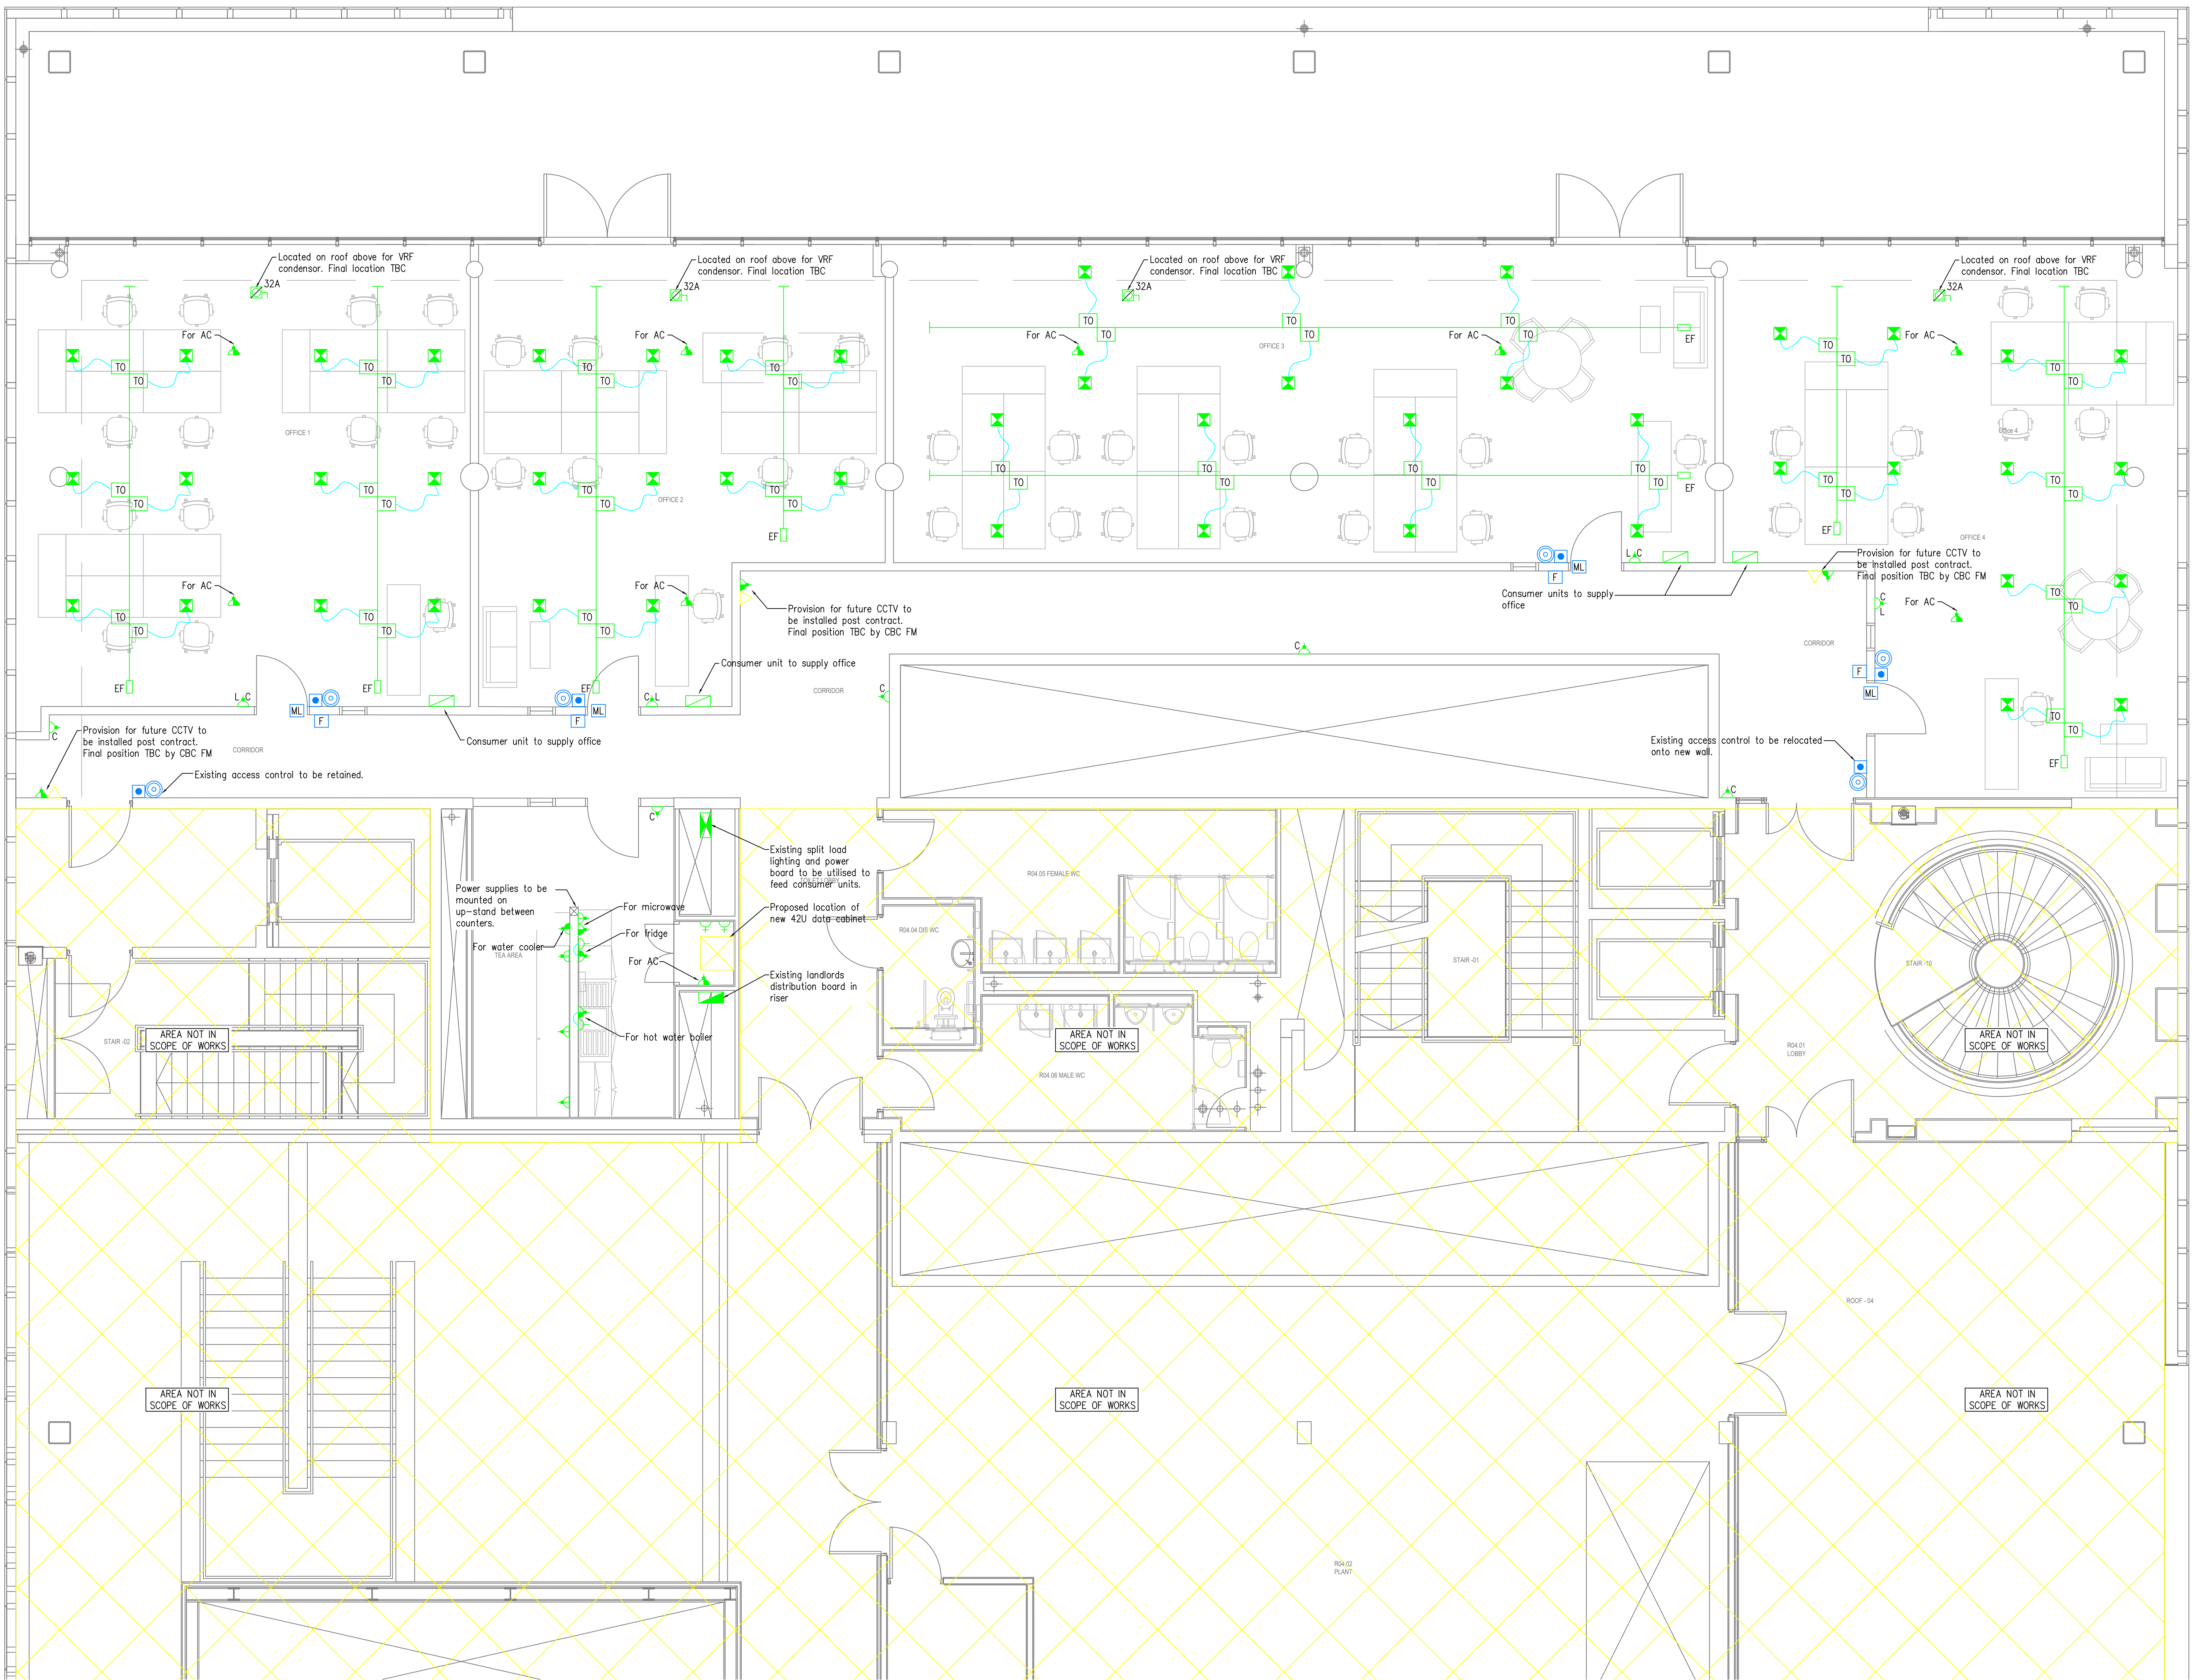




 











1. THIS DRAWING IS TO BE READ IN CONJUNCTION WITH ALL RELEVANT ARCHITECTURAL & STRUCTURAL DRAWINGS.
2. THIS DRAWING IS TO BE READ IN CONJUNCTION WITH ALL RELEVANT BUILDING SERVICES DRAWINGS & THE RELEVANT SECTIONS OF THE SPECIFICATIONS & SCHEDULES.
3. THIS DRAWING IS NOT TO BE SCALED.
4. ALL DIMENSIONS ARE IN mm UNLESS OTHERWISE STATED.
5. UNDERFLOOR BURSARS TO BE FED FROM LOCAL LIGHTING AND POWER DB IN RISER, CLEAN EARTH CONNECTION REQUIRED TO MAIN EARTHING TERMINAL.
6. ALL UNDERFLOOR DISTRIBUTION BOARD LOCATED IN RISER.
7. CONTRACTOR TO ALLOW FOR ALL OUTGOING MCB'S FROM EXISTING DISTRIBUTION BOARDS.
8. CONTRACTOR SHALL LIAISE WITH CBC FM FOR METERING TO SUEP LIFTED SPACES.
9. ACCESS CONTROL, TO CONNECT INTO THE EXISTING 24VDC 2 SYSTEM.
10. CONTRACTOR TO ALLOW FOR POWER TO MECHANICAL PLANT AND SERVICES WHERE REQUIRED.



LEGEND OF SYMBOLS	
SYMBOL	DESCRIPTION
	13A SINGLE SWITCHED SOCKET OUTLET Nc DENOTES FOR CLEANERS USE Mc DENOTES LOCKABLE
	13A TWIN SWITCHED SOCKET OUTLET
	13A SWITCHED FUSED CONNECTION UNIT N DENOTES NEON
	SUPPLY FOR UNDER COUNTER APPLIANCES, SPUR ABOVE COUNTER, SWITCHED SOCKET 600mm AFL
	3 COMPARTMENT FLOOR OUTLET BOX (C/W 2 NO TWIN DATA AND 2 NO TWIN SWITCHED SOCKET OUTLET)
	SINGLE PHASE COMMANDO SOCKET OUTLET. (* DENOTES RATING)
	UNDER FLOOR POWER TRAC & ENDFEED C/W CLEAN EARTH CONNECTION TO LOCAL DB
	UNDER FLOOR BUSBAR TAP OFF
	SINGLE DATA OUTLET (* DENOTES NO OF OUTLETS)
	DISTRIBUTION BOARD
	CONSUMER UNIT
	COMBINED LIGHTING & POWER DISTRIBUTION BOARD
	ROTARY ISOLATING SWITCH SP&N (* DENOTES RATING, FS DENOTES FUSED SWITCH)

LEGEND OF SECURITY SYSTEM SYMBOLS	
SYMBOL	DESCRIPTION
	DOOR RELEASE BUTTON/PUSH PAD
	GREEN BREAKGLASS
	MAGNETIC DOOR LOCK
	FOB ACCESS

T3	19.01.17	TENDER ISSUE	TW
T2	18.01.17	TENDER ISSUE	TW
T1	10.01.17	TENDER ISSUE	TW
P1	02.12.16	PRELIMINARY ISSUE	NP
REV	DATE	DESCRIPTION	BY

BSD Building Services Design
Consulting Engineers
Website: www.buildingservicesdesign.co.uk

1 Brisbane House, Corbygate Business Park
Priors Hall Road, Corby, Northamptonshire, NN17 5JG
Tel: (01536) 403304, Fax: (01536) 403838
Email: corby@buildingservicesdesign.co.uk
Offices in London, Cambridge, Birmingham, Manchester, and Leicester

Client: CORBY BOROUGH COUNCIL

Project:
CORBY CUBE FOURTH FLOOR
OFFICE

Title: ELECTRICAL SERVICES
PROPOSED FOURTH FLOOR
SMALL POWER AND DATA
AND ACCESS CONTROL LAYOUT

Scale at A0:	Date:	Designed:	Drawn:	Design:	
1:50	NOV 16	MR	NP	CAD:	

161190/E/2300

TENDER