


PLAN

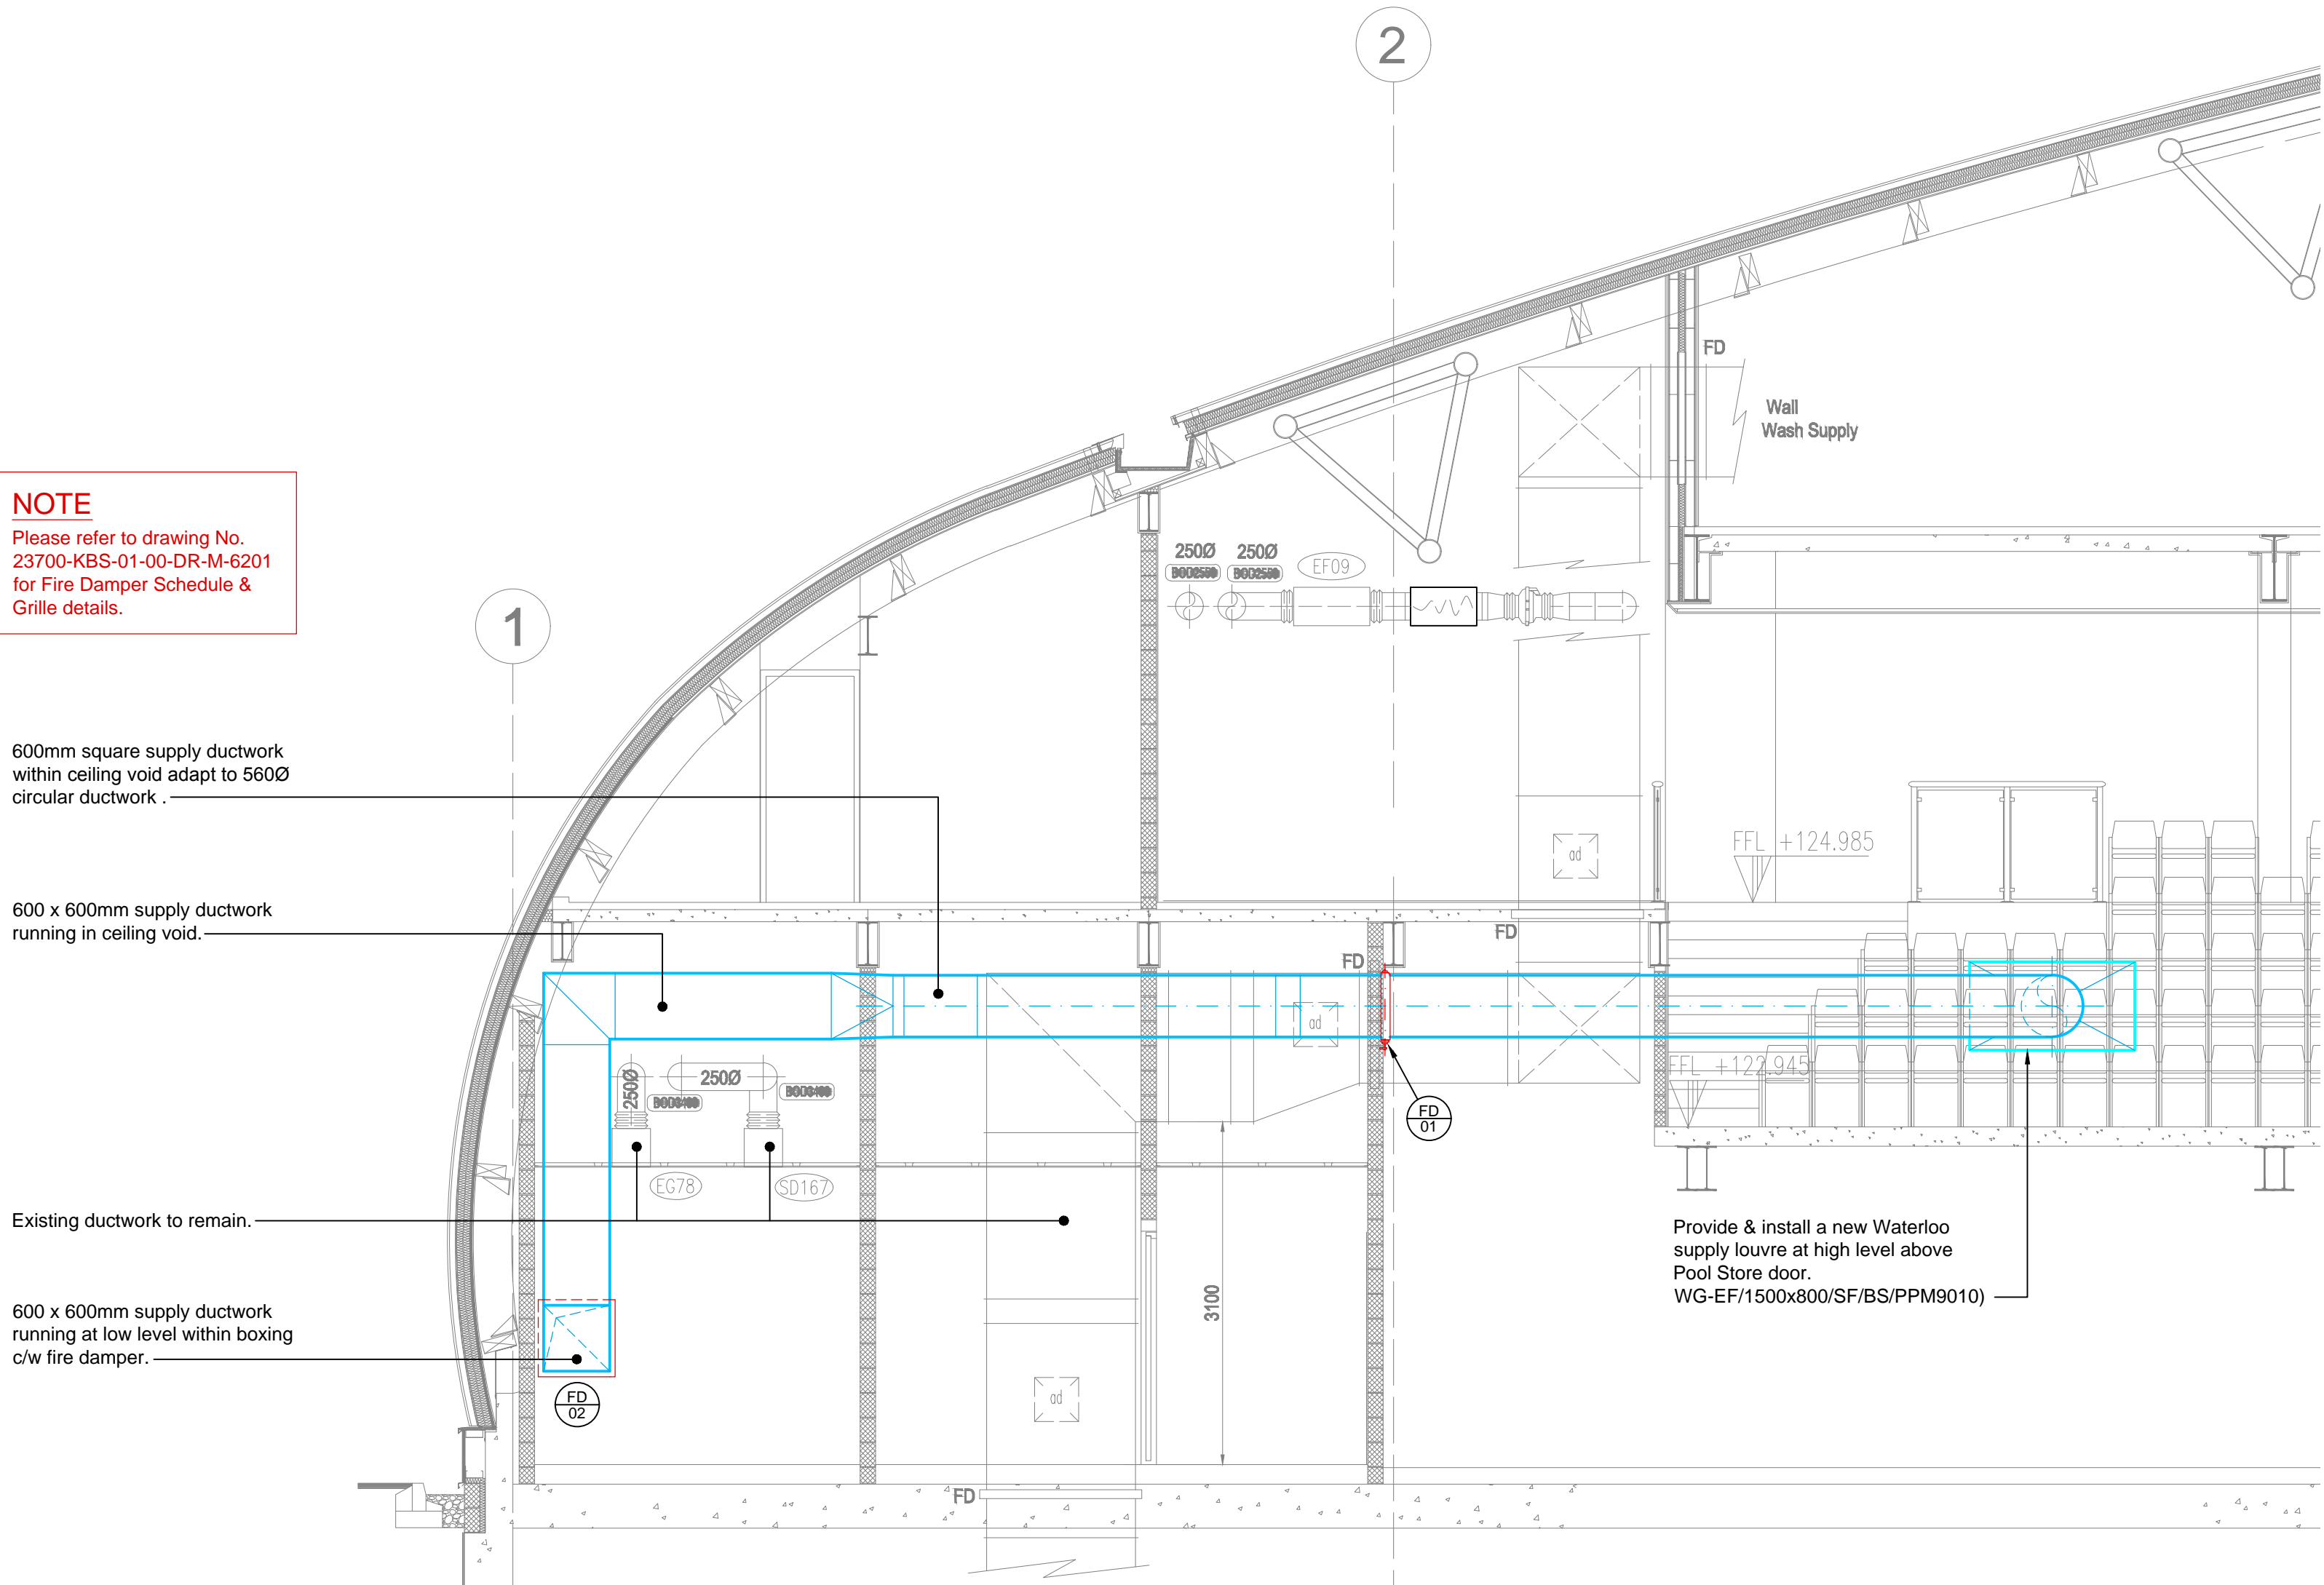

SECTION A-A

NOTES

This Drawing is presented to the Corby Borough Council in respect of the Corby International Swimming Pool and may not be used or relied on by any other person or by the client in relation to any other matters not covered specifically by the scope of this Drawing.

Notwithstanding anything to the contrary contained in the Drawing, Kier Business Services Limited is obliged to exercise reasonable skill, care and diligence in the performance of the services required by Corby Borough Council and Kier Business Services Limited shall not be liable except to the extent that it has failed to exercise reasonable skill, care and diligence, and this Drawing shall be read and construed accordingly.

This Drawing has been prepared by Kier Business Services Limited and no individual is personally liable in connection with the preparation of this Drawing. By receiving this Drawing and acting on it, the client or any other person accepts that no individual is personally liable whether in contract, tort, for breach of statutory duty or otherwise Kier Business Services Limited has used reasonable endeavours to provide information that is correct and accurate and the Drawing sets out reasonable conclusions that have been reached on the basis of the information available.

© Crown Copyright and database rights 2017 Ordnance Survey 0100056811. You are permitted to use this data solely to enable you to respond to, or interact with, the organisation that provided you with the data. You are not permitted to copy, sub-licence, distribute or sell any of this data to third parties in any form.

NOTE

This drawing to be read in conjunction with the Mechanical Installation Specification.

SUPPLY & EXTRACT FAN SCHEDULE				
RADIATOR REF.	LOCATION	MAKE	CODE	DESCRIPTION
EF-01	Zone 3	NUAIRE	AM43ES-QA14151	Nuaire Airmover centrifugal square cased unit with double skinned acoustic panels c/w frequency inverter with full ECOSMART compatibility in a remote control box. Inverter supplied with fan needs, to be mounted internally within the building unless weather enclosure is ordered. QA = unit has been treated for use in chlorinated atmosphere.
			AMDF3	Doubled flanged flexible connector.
			NAV2	Anti-vibration mounting kit (540822)
			ES-LCD	Nuaire Ecosmart user control with touch screen c/w time clock, fitted with cable extender 830272.
SF-01	Plant Room	NUAIRE	AM43ES-QA14151	Nuaire Airmover centrifugal square cased unit with double skinned acoustic panels c/w frequency inverter with full ECOSMART compatibility in a remote control box. Inverter supplied with fan needs, to be mounted internally within the building unless weather enclosure is ordered. QA = unit has been treated for use in chlorinated atmosphere.
			AMDF3	Doubled flanged flexible connector.
			NAV2	Anti-vibration mounting kit (540822)
			ES-LCD	Nuaire Ecosmart user control with touch screen c/w time clock, fitted with cable extender 830272.
RC01			TRTS-C-QA14151 Note Upstand to be provided by others.	Terminator terminal size C c/w shutters treated for use in chlorinated atmosphere.

P01	Tender Issue	I.D.	A.G.	O.T.
Rev.	Details	Author & Date	Checked & Date	Approved & Date

Issuing Office
SANDY

Tel. no.
07989 532456

email
ozlem.thomson@kier.co.uk

Internal Project Number
10005163

Client
Corby Borough Council

Project name
Corby International Swimming Pool

Drawing Title
Existing & Proposed Ventilation Layout
Ground Floor First Air & Poolside

Scale	Original Size	RIBA Stage
1:50	A1	Stage A4

Date of First Issue November 2019	Author	Checked	Approved
Drawing Number 23700-KBS-01-GF-DR-M-6202	I.D.	A.K.	O.T.

Project	Originator	Volume	Type	Role	Number

Status
D2
Rev.
P01

