


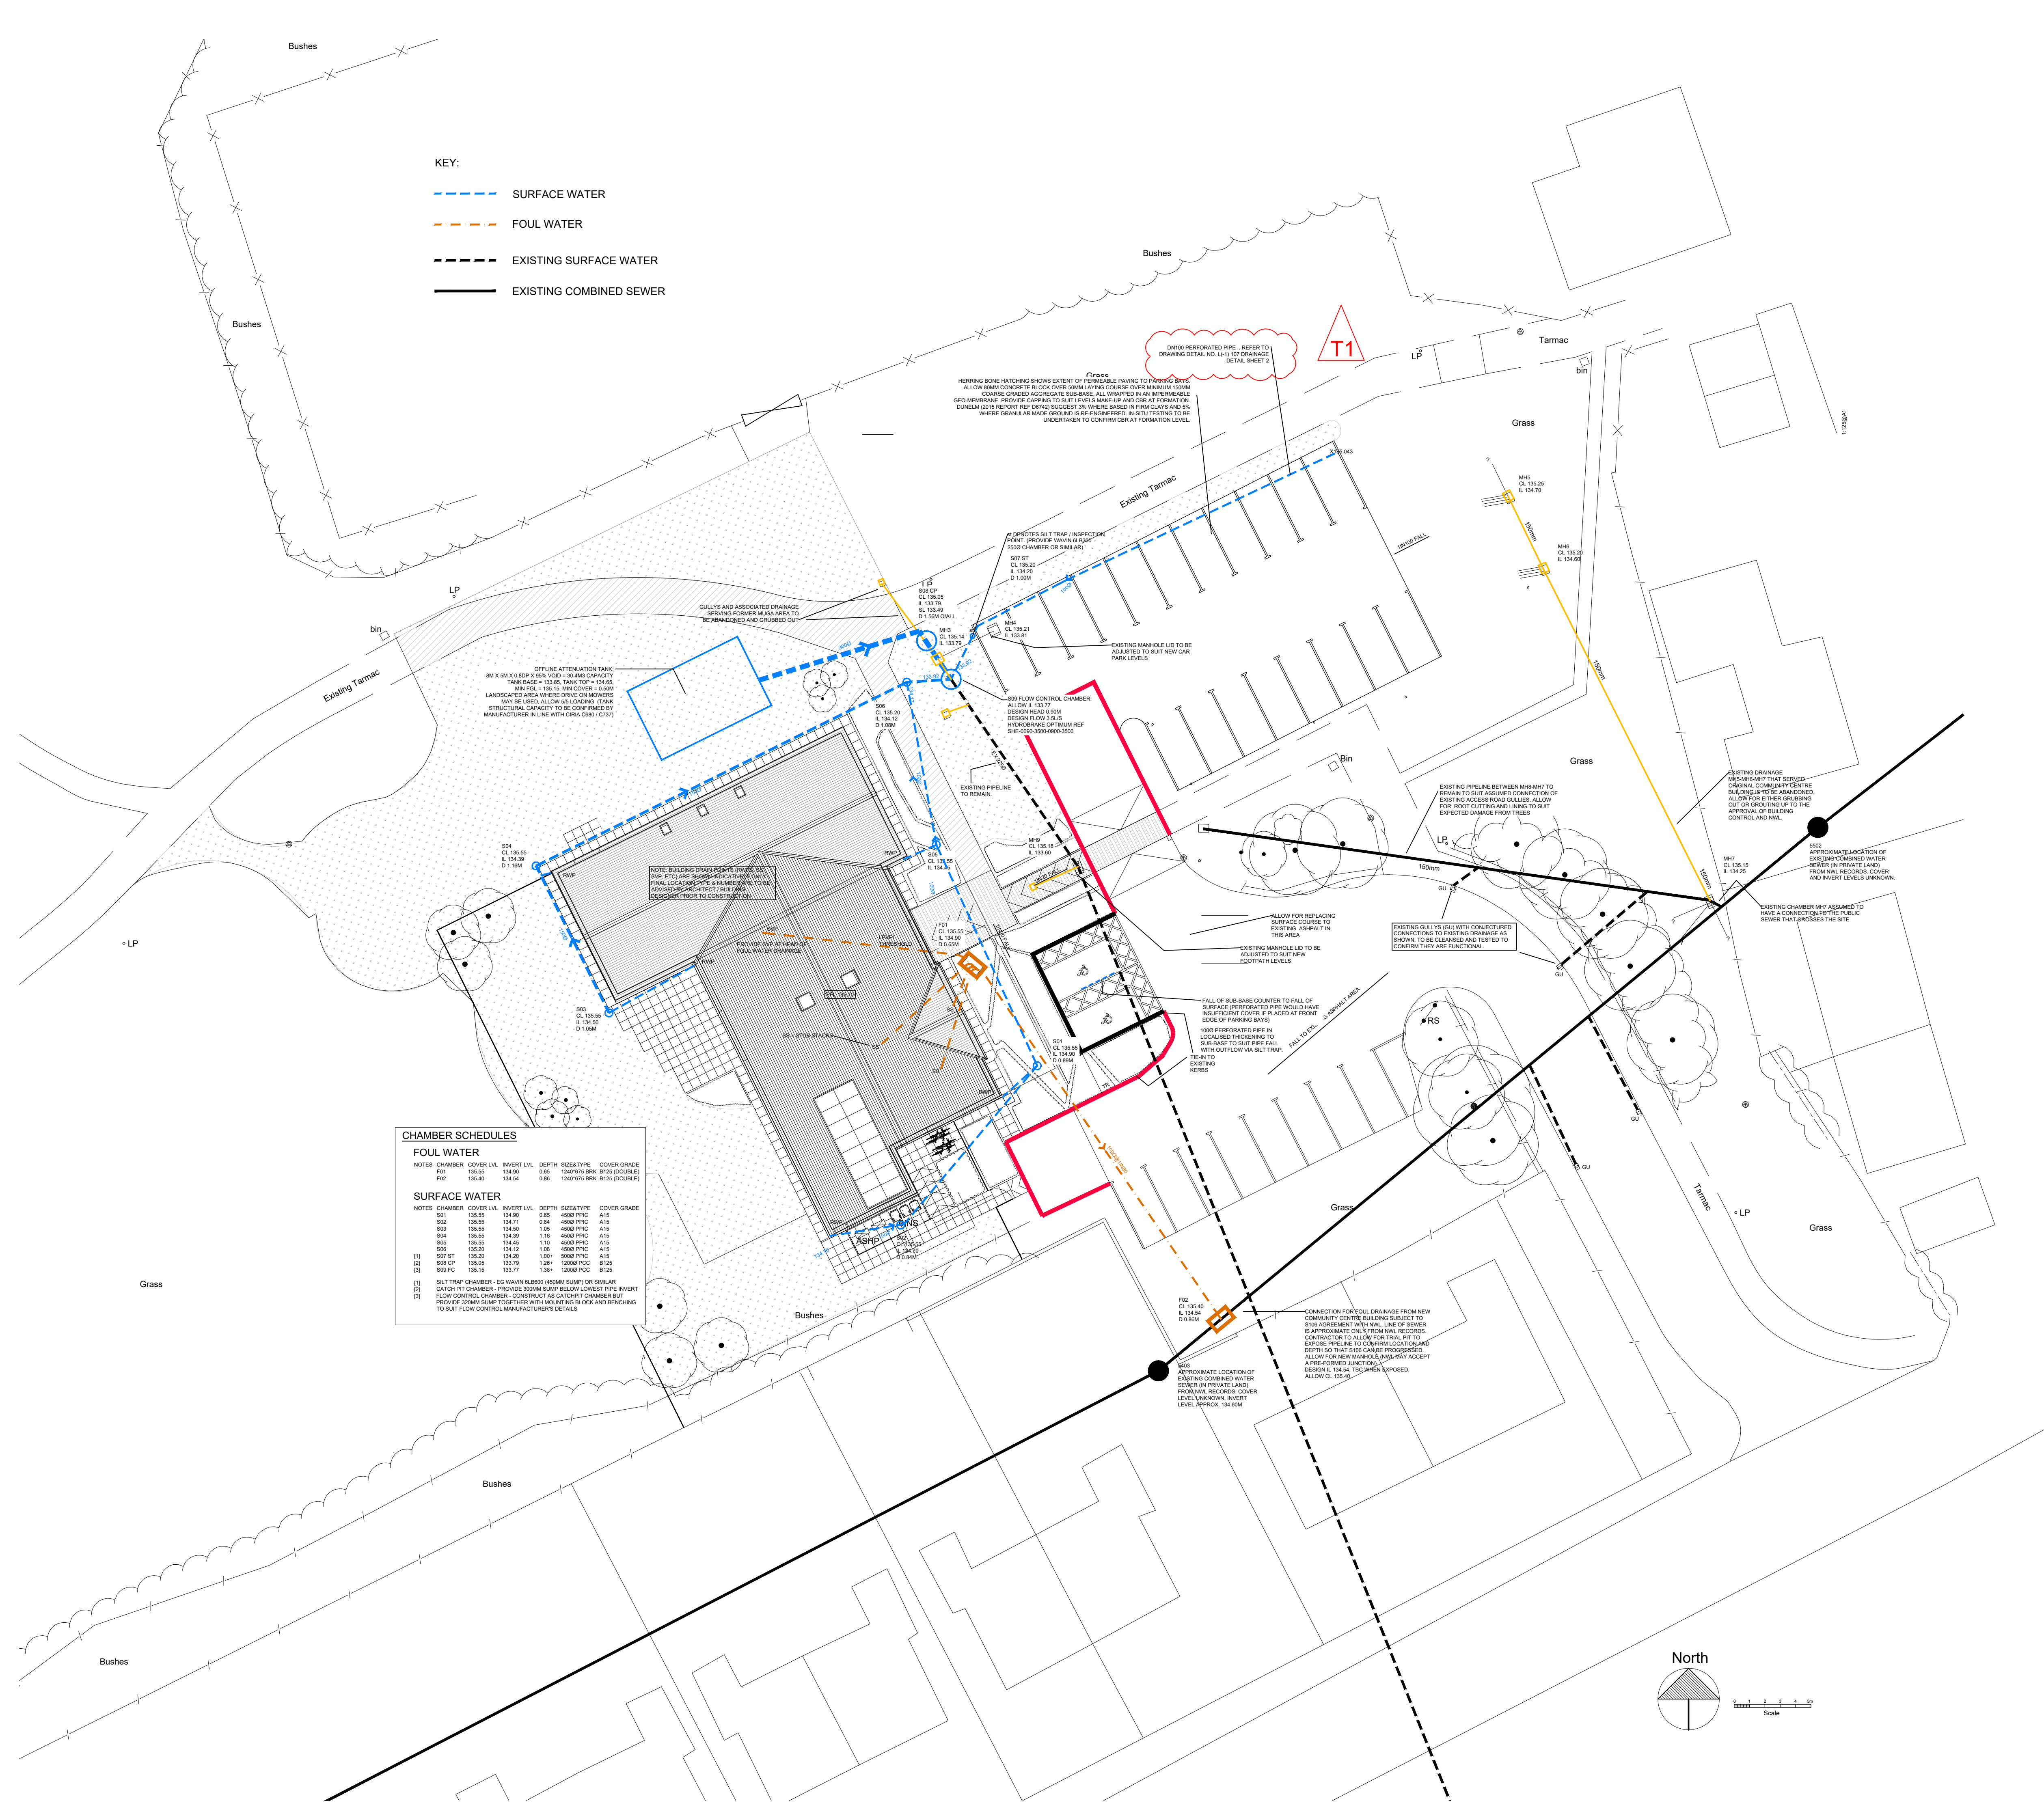

KEY:

--- SURFACE WATER

--- FOUL WATER

--- EXISTING SURFACE WATER

— EXISTING COMBINED SEWER

CHAMBER SCHEDULES						
FOUL WATER						
NOTES	CHAMBER	COVER LVL	INVERT LVL	DEPTH	SIZE&TYPE	COVER GRADE
F01		135.55	134.90	0.65	1200x750 BRK B125 (DOUBLE)	
F02		135.40	134.54	0.86	1200x750 BRK B125 (DOUBLE)	
SURFACE WATER						
NOTES	CHAMBER	COVER LVL	INVERT LVL	DEPTH	SIZE&TYPE	COVER GRADE
S01		135.55	134.90	0.65	450x600 PPC A15	
S02		135.55	134.71	0.84	450x600 PPC A15	
S03		135.55	134.50	1.05	450x600 PPC A15	
S04		135.55	134.39	1.16	450x600 PPC A15	
S05		135.55	134.45	1.10	450x600 PPC A15	
S06		135.20	134.12	1.08	450x600 PPC A15	
S07 ST		135.20	134.20	1.00	450x600 PPC A15	
S08 CP		135.05	133.79	1.26	1200x600 RCC B125	
S09 FC		135.15	133.77	1.38	1200x600 RCC B125	
[1]	SILT TRAP CHAMBER - EG WOVEN ELBOW 450MM SLUMP OR SIMILAR					
[2]	CATCH PIT CHAMBER - PROVIDE 300MM SLUMP BELOW LOWEST PIPE INVERT					
[3]	FLOW CONTROL CHAMBER - CONSTRUCT AS CATCH PIT CHAMBER BUT PROVIDE 300MM SLUMP TOGETHER WITH MOUNTING BLOCK AND BENCHING TO SUIT FLOW CONTROL MANUFACTURER'S DETAILS					

NOTES.

1. ALL DIMENSIONS IN MILLIMETRES (mm) UNLESS NOTED OTHERWISE.

2. ALL LEVELS ARE IN METRES (m) ABOVE ORDNANCE DATUM.

3. THIS DRAWING SHOULD BE READ IN CONJUNCTION WITH THE GENERAL ARRANGEMENT DRAWING.

T1	20-02-19	Re-issued for Tender	EMN
T	29-01-19	Issued for Tender	CJW
Rev.	Date	Details	App'd

PROJECT TITLE:

SHOTTON COMMUNITY CENTRE

DRAWING TITLE:

Proposed Drainage Plan

CLIENT:

Shotton Parish Council

STATUS: TENDER	
Design: CJW	CAD: CJW
Chk'd: MRD	App'd: MRD
Date: 25.07.18	Scale: 1:200 @A1



d3 associates
consultants and project managers

Mallan House,
Bridge End, Hexham,
Northumberland, NE46 4DQ

01434 610 434
info@d3-associates.co.uk
www.d3-associates.co.uk

Project no:	Drg no:	Rev:
1442	L(-1)105	T1