


INDICATIVE STRIP OUT WORKS

First Floor Plan

Project: Environment Agency, Leeds
DRG Ref: M03
Scale: NTS

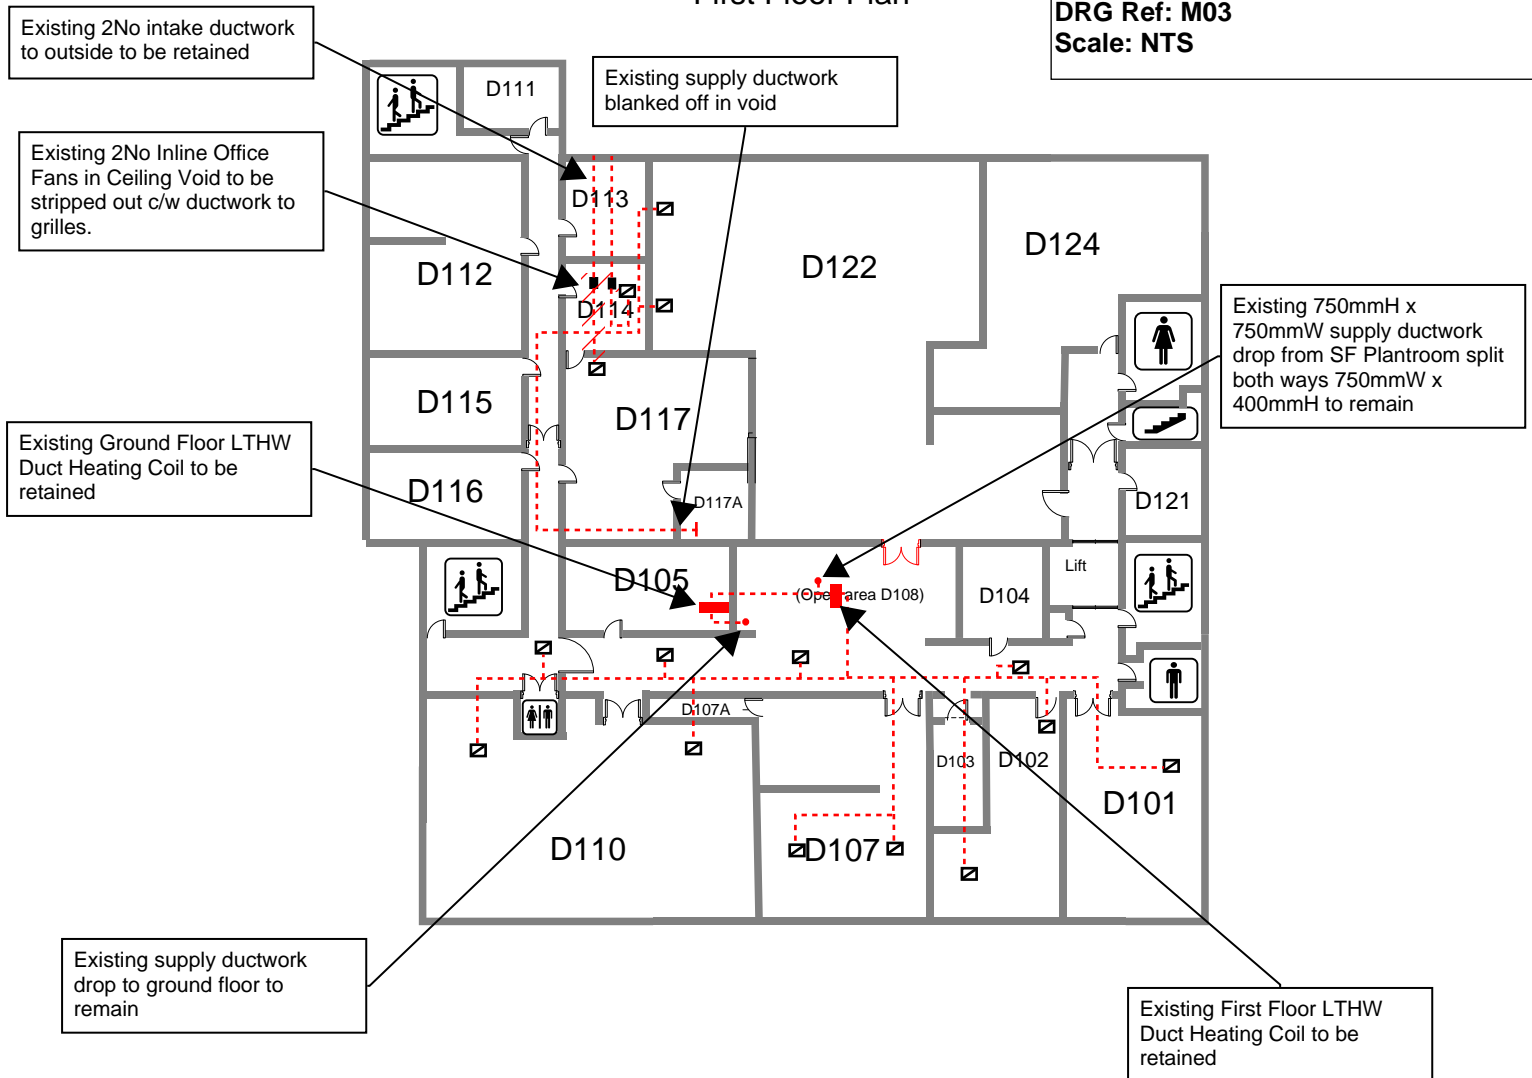

KEY

- - - - - Existing Extract Ductwork retained (indicative only)
- - - - - Existing Supply Ductwork retained (indicative only)
- / / / / / Strip Out Works (indicative only)
- — — — — NEW Extract Ductwork retained (indicative only)
- — — — — NEW Supply Ductwork retained (indicative only)
- Existing Supply Grille to be replaced with NEW 4 Way Diffuser c/w OBD (indicative only)
- X Existing Extract Grille to be replaced with NEW Eggcrate Grille c/w OBD (indicative only)