


UNDERFLOOR HEATING

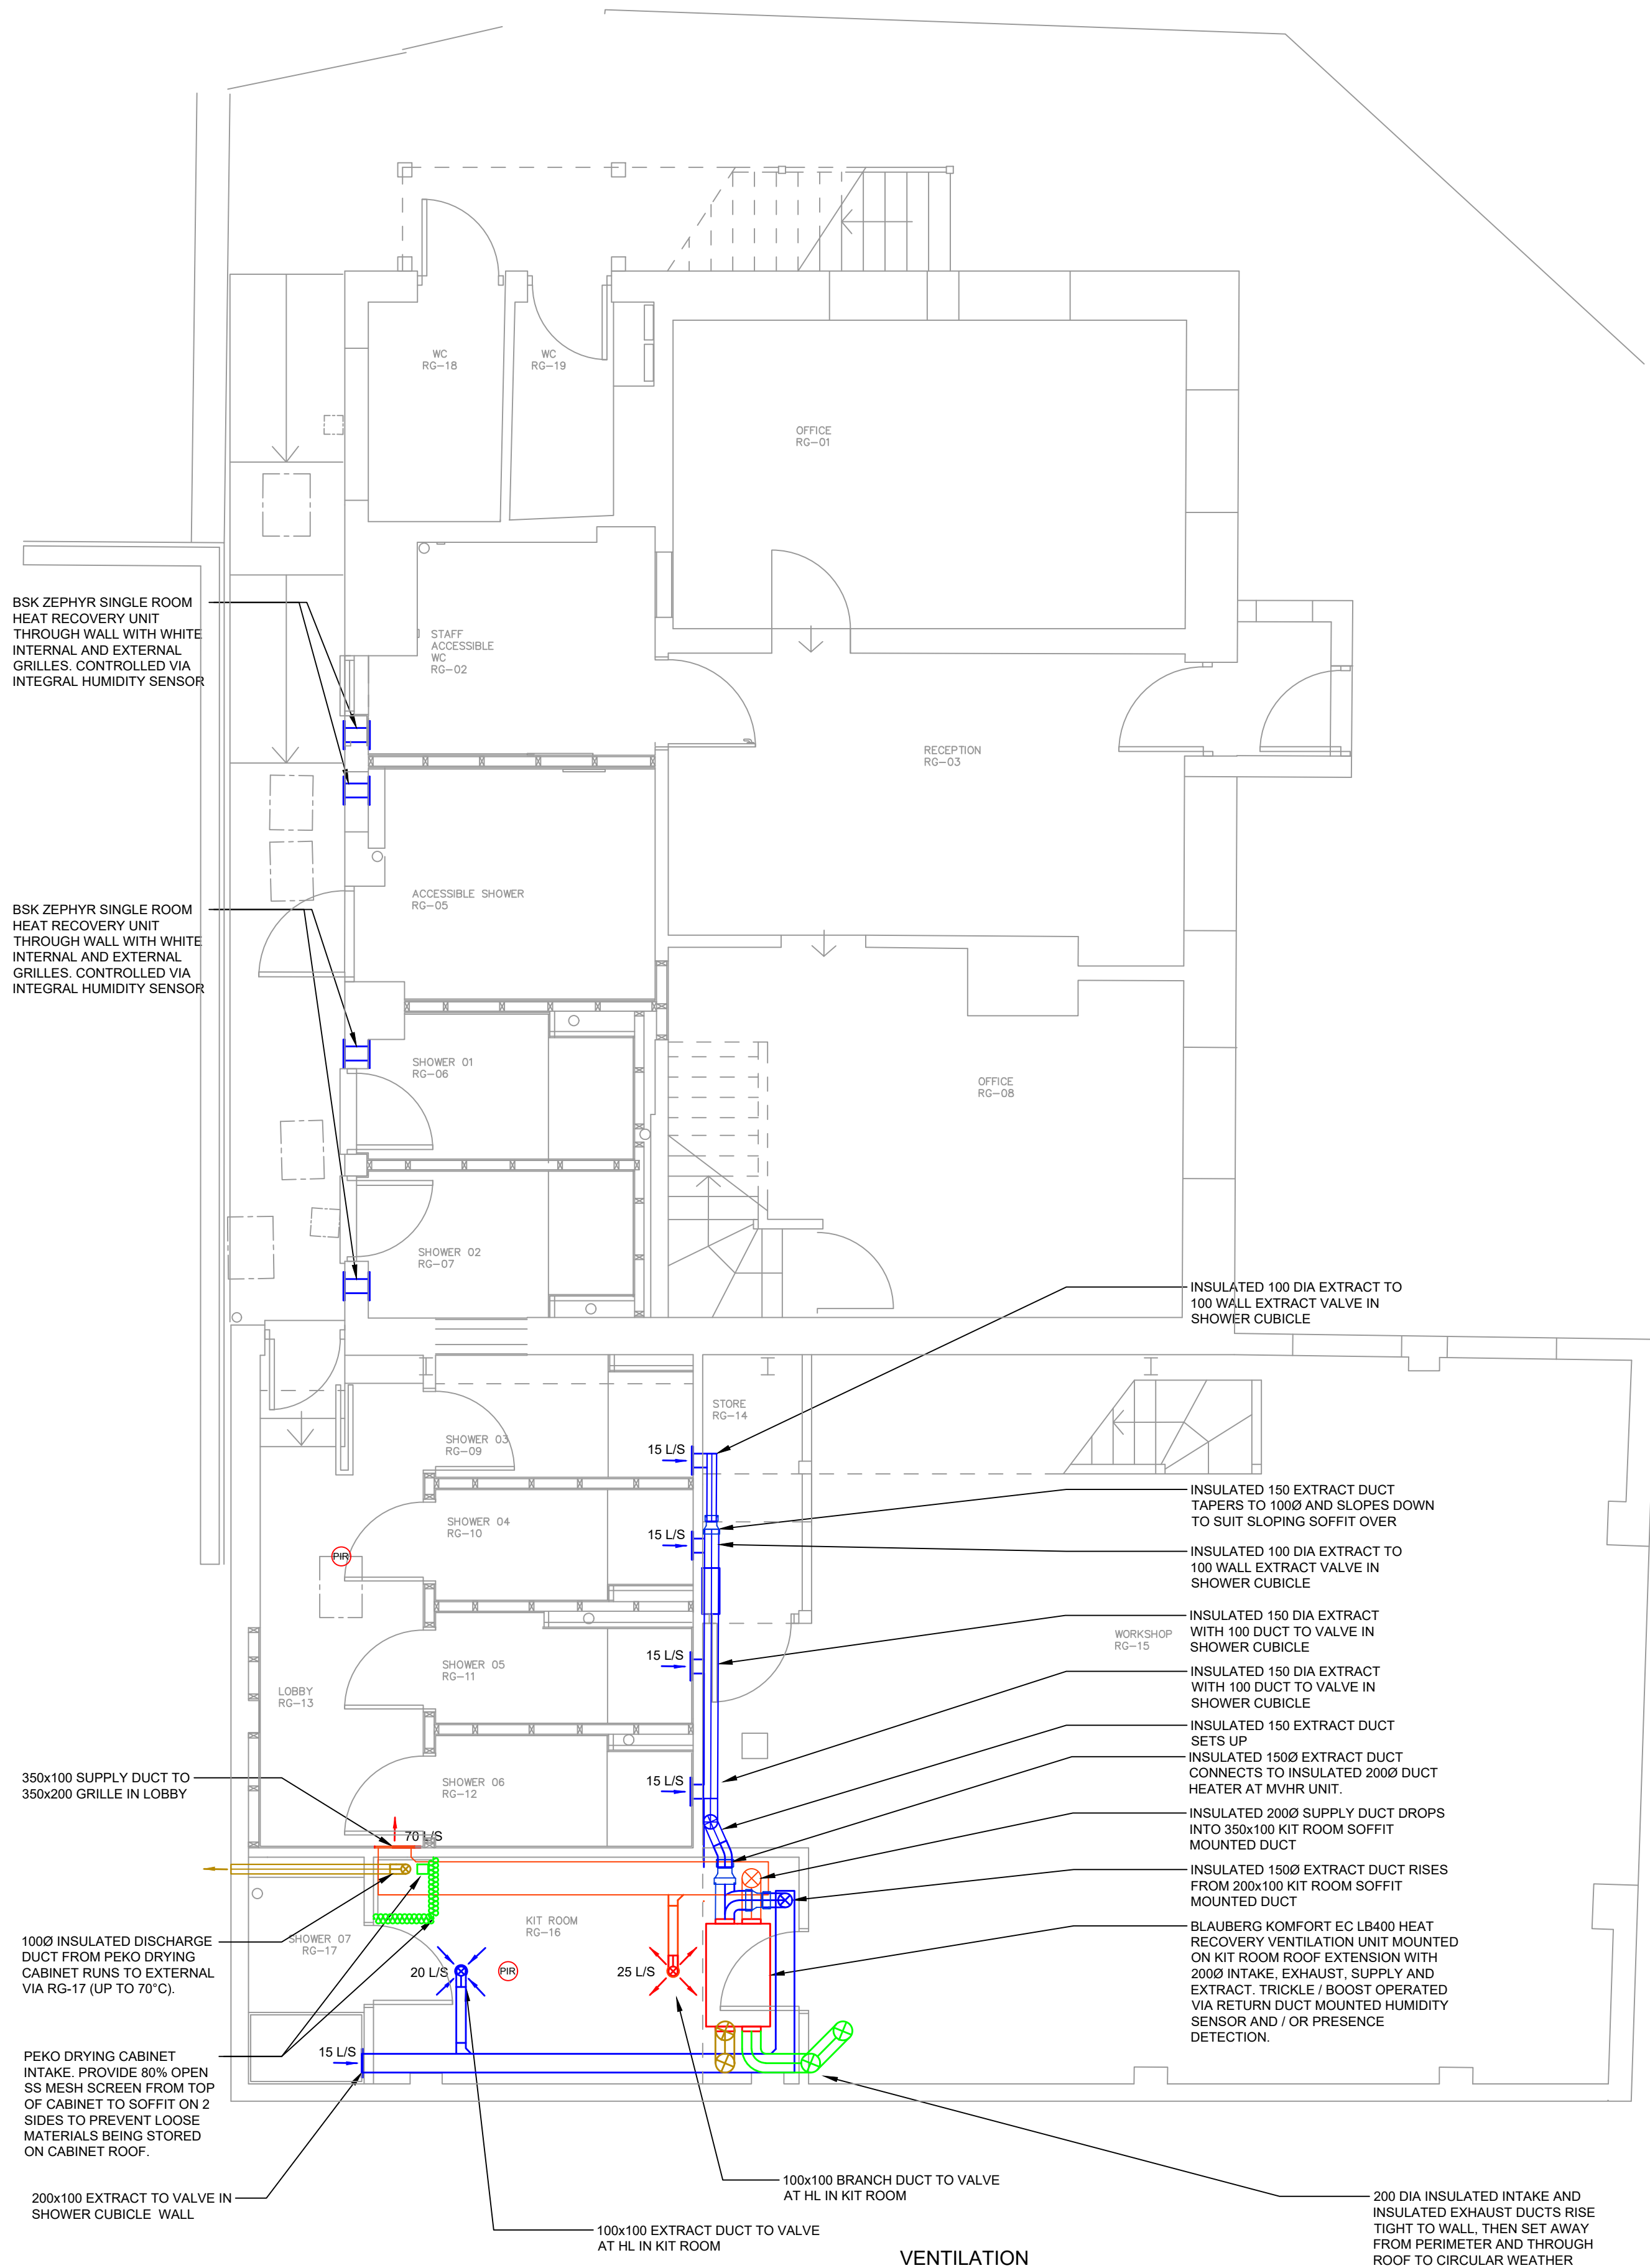

VENTILATION

DO NOT SCALE FROM THIS DRAWING - CHECK ALL DIMENSIONS ON SITE.
THIS DRAWING IS A DESIGN DRAWING ONLY. INFORMATION SHOWN MAY NEED TO BE SUPPLEMENTED OR FURTHER DRAWINGS PRODUCED FOR CONSTRUCTION.
ANY INACCURACIES WITH THIS DRAWING MUST BE REPORTED TO POPE CONSULTING LTD AT THE EARLIEST OPPORTUNITY.

SAFETY, HEALTH AND ENVIRONMENT INFORMATION
OUR ASSESSMENT IS BASED ON THE USE OF EXPERIENCED AND COMPETENT CONTRACTOR(S) WORKING TO AN APPROVED METHOD STATEMENT. UNUSUAL HAZARDS/RISKS ARE LISTED BELOW OR THE STATEMENT "NO SIGNIFICANT RISK" IS INCLUDED

CONSTRUCTION
1. Residential Staircase Congestion

OPERATION
1. No Significant Risk

MAINTENANCE
1. No Significant Risk

(FUTURE) DISMANTLING/DEMOLITION
1. INFORMATION BASED ON RECORD DRAWINGS CANNOT BE VALIDATED FOR ACCURACY - SURVEY REQUIRED PRIOR TO WORKS

VENTILATION LEGEND

- BROWN - EXHAUST
- GREEN - INTAKE
- RED - SUPPLY
- BLUE - EXTRACT

SP06
EX09

CEILING SUPPLY DIFFUSER

CEILING EXTRACT GRILLE

EXTRACT GRILLE

SUPPLY GRILLE

FD
FSD
VCD

FIRE DAMPER

FIRE SMOKE DAMPER

VOLUME CONTROL DAMPER

CTA 01
ATT

CROSS TALK ATTENUATOR

ATTENUATOR

VENTILATION CRUCIFIX LEGEND

DUCT SIZE - mm

FLOW RATE - m³/s

VELOCITY m/s

PRESSURE LOSS Pa/m

2000	0.055
1750	0.225

T2	CLIENT REVIEW UPDATES	NC	20.12.24
T1	TENDER ISSUE	NC	03.12.24
No.		CHK	DATE
REVISION			

ISSUE:

TENDER



CLIENT:

CHICHESTER
HARBOUR CONSERVANCY

PROJECT:

HARBOUR CONSERVANCY
ITCHENOR

DRAWING TITLE:

UNDERFLOOR HEATING
AND VENTILATION LAYOUTS

DATE: 03.12.24	DESIGNED: JC	CHECKED: NC	SCALE: 1:50 @ A1
PROJECT NO. 5453	DRAWING NO. M001	REV: T2	