

DO NOT SCALE FROM THIS DRAWING.

THE CONTRACTOR SHALL CHECK ALL DIMENSIONS AND REPORT ANY OMISSIONS OR ERRORS.


ALL DIMENSIONS IN MILLIMETRES UNLESS OTHERWISE STATED.

LEGEND

- | | |
|---|---|
| 1 | 1X3W SURFACE MOUNTED LINEAR FLUORESCENT CW LAMP
DELTA REF: GRADUATE 900708 HF TPA |
| 2 | 2X3W SURFACE MOUNTED LINEAR FLUORESCENT CW LAMPS
DELTA REF: GRADUATE 900206 HF TPA |
| 3 | 1X3W SURFACE MOUNTED CIRCULAR LUMINAIRE CW LAMP
DELTA REF: AMB 103 HF |
| 4 | 1 GANG LIGHT SWITCH (ESSENTIAL SERVICES)
1 GANG LIGHT SWITCH (EXISTING (ESSENTIAL SERVICES)) |
| 5 | SMOKE DETECTOR |
| 6 | SMOKE DETECTOR (EXISTING) |
| 7 | SMOKE DETECTOR (EXISTING/RELOCATED) |

EXISTING LAYOUT


SCALE 1:50

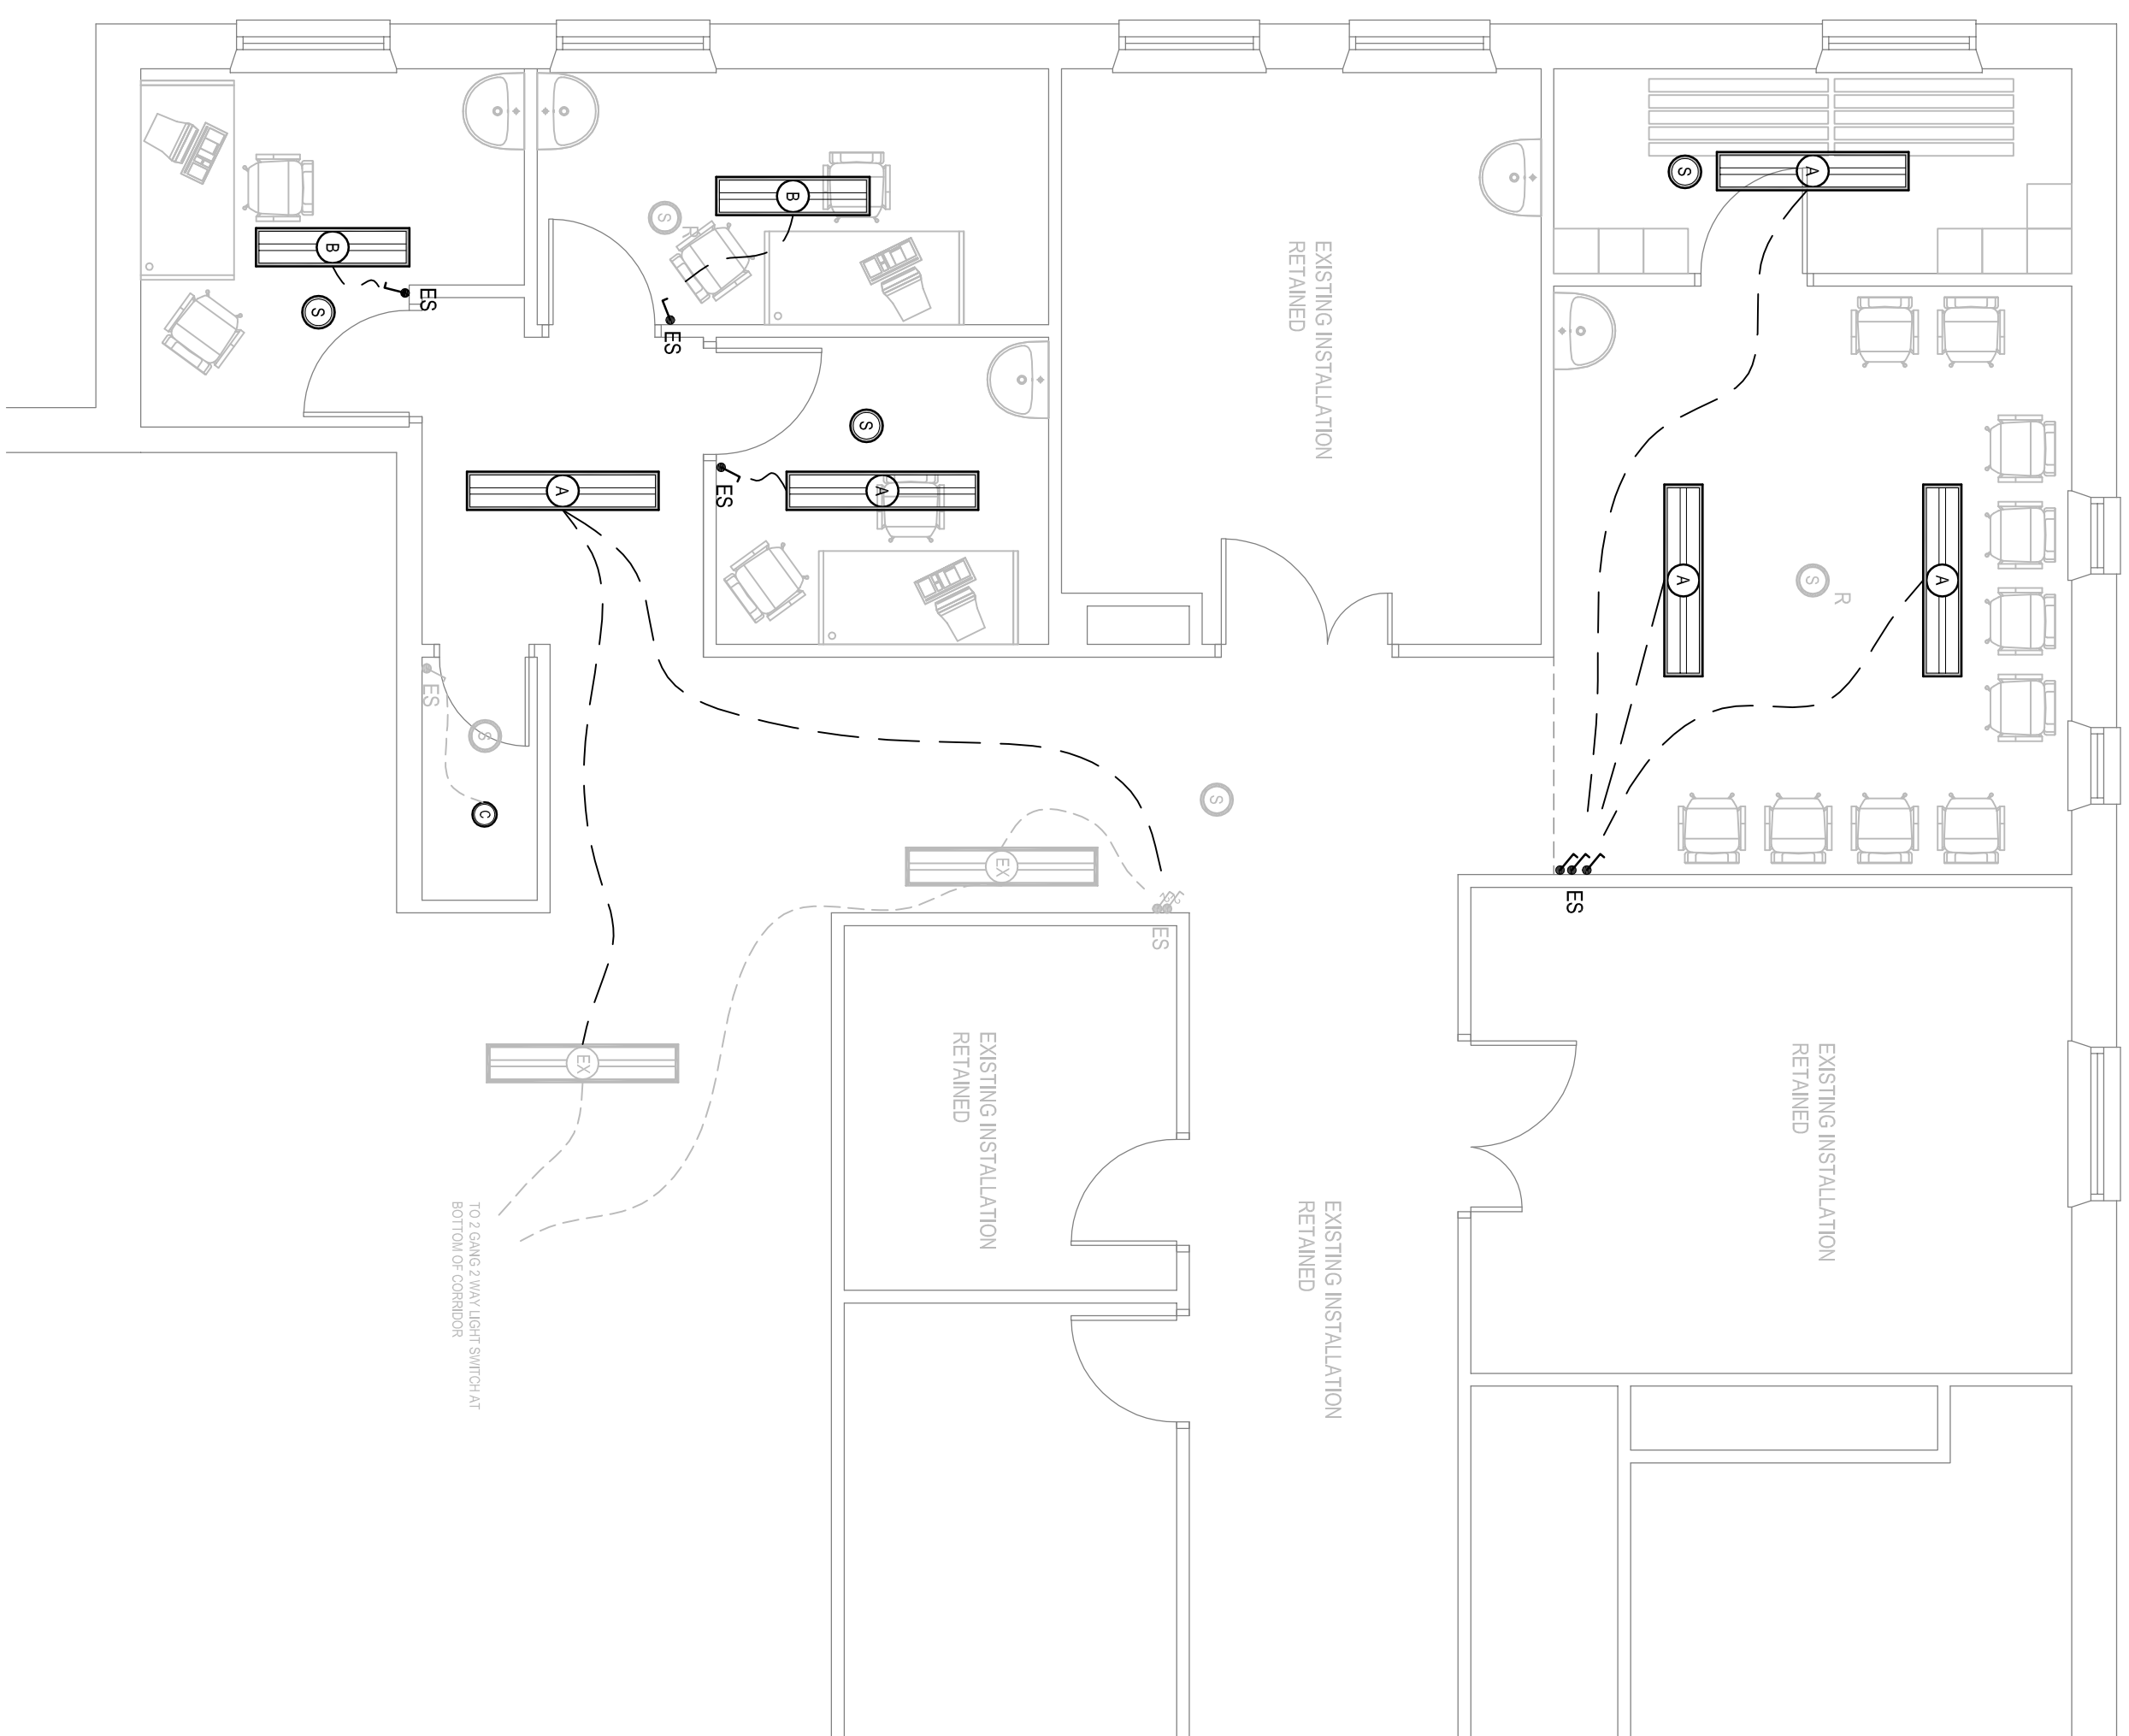

PROPOSED LAYOUT

SCALE 1:50

T1	ISSUED FOR TENDER	SPB	PTH
Rev	Purpose of Issued/Modifications	By	CHK'd
			Date
			03/06/15

<p>  JH Partners The Old Barn South Offices 1700 Main Durham NC 27601 </p>	Tel: 0191 365 3111 Fax: 0191 365 9111 Email: admin@jhparkers.co.uk
<p> York Teaching Hospital NHS Foundation Trust TRUST </p>	<p> Project: ALTERATIONS TO A&D CLINIC BRLINGTON AND DISTRICT HOSPITAL </p>
<p> THB </p>	<p> ELECTRICAL SERVICES EXISTING AND PROPOSED FIRE ALARM AND LIGHTING LAYOUT </p>
<p> Size: A1 </p>	<p> Scale: 1:50 </p>
<p> By: SFB </p>	<p> Checked: PTH </p>
<p> Drawing No: 0372-09-001 </p>	<p> Rev: T1 </p>