


PRELIMINARY

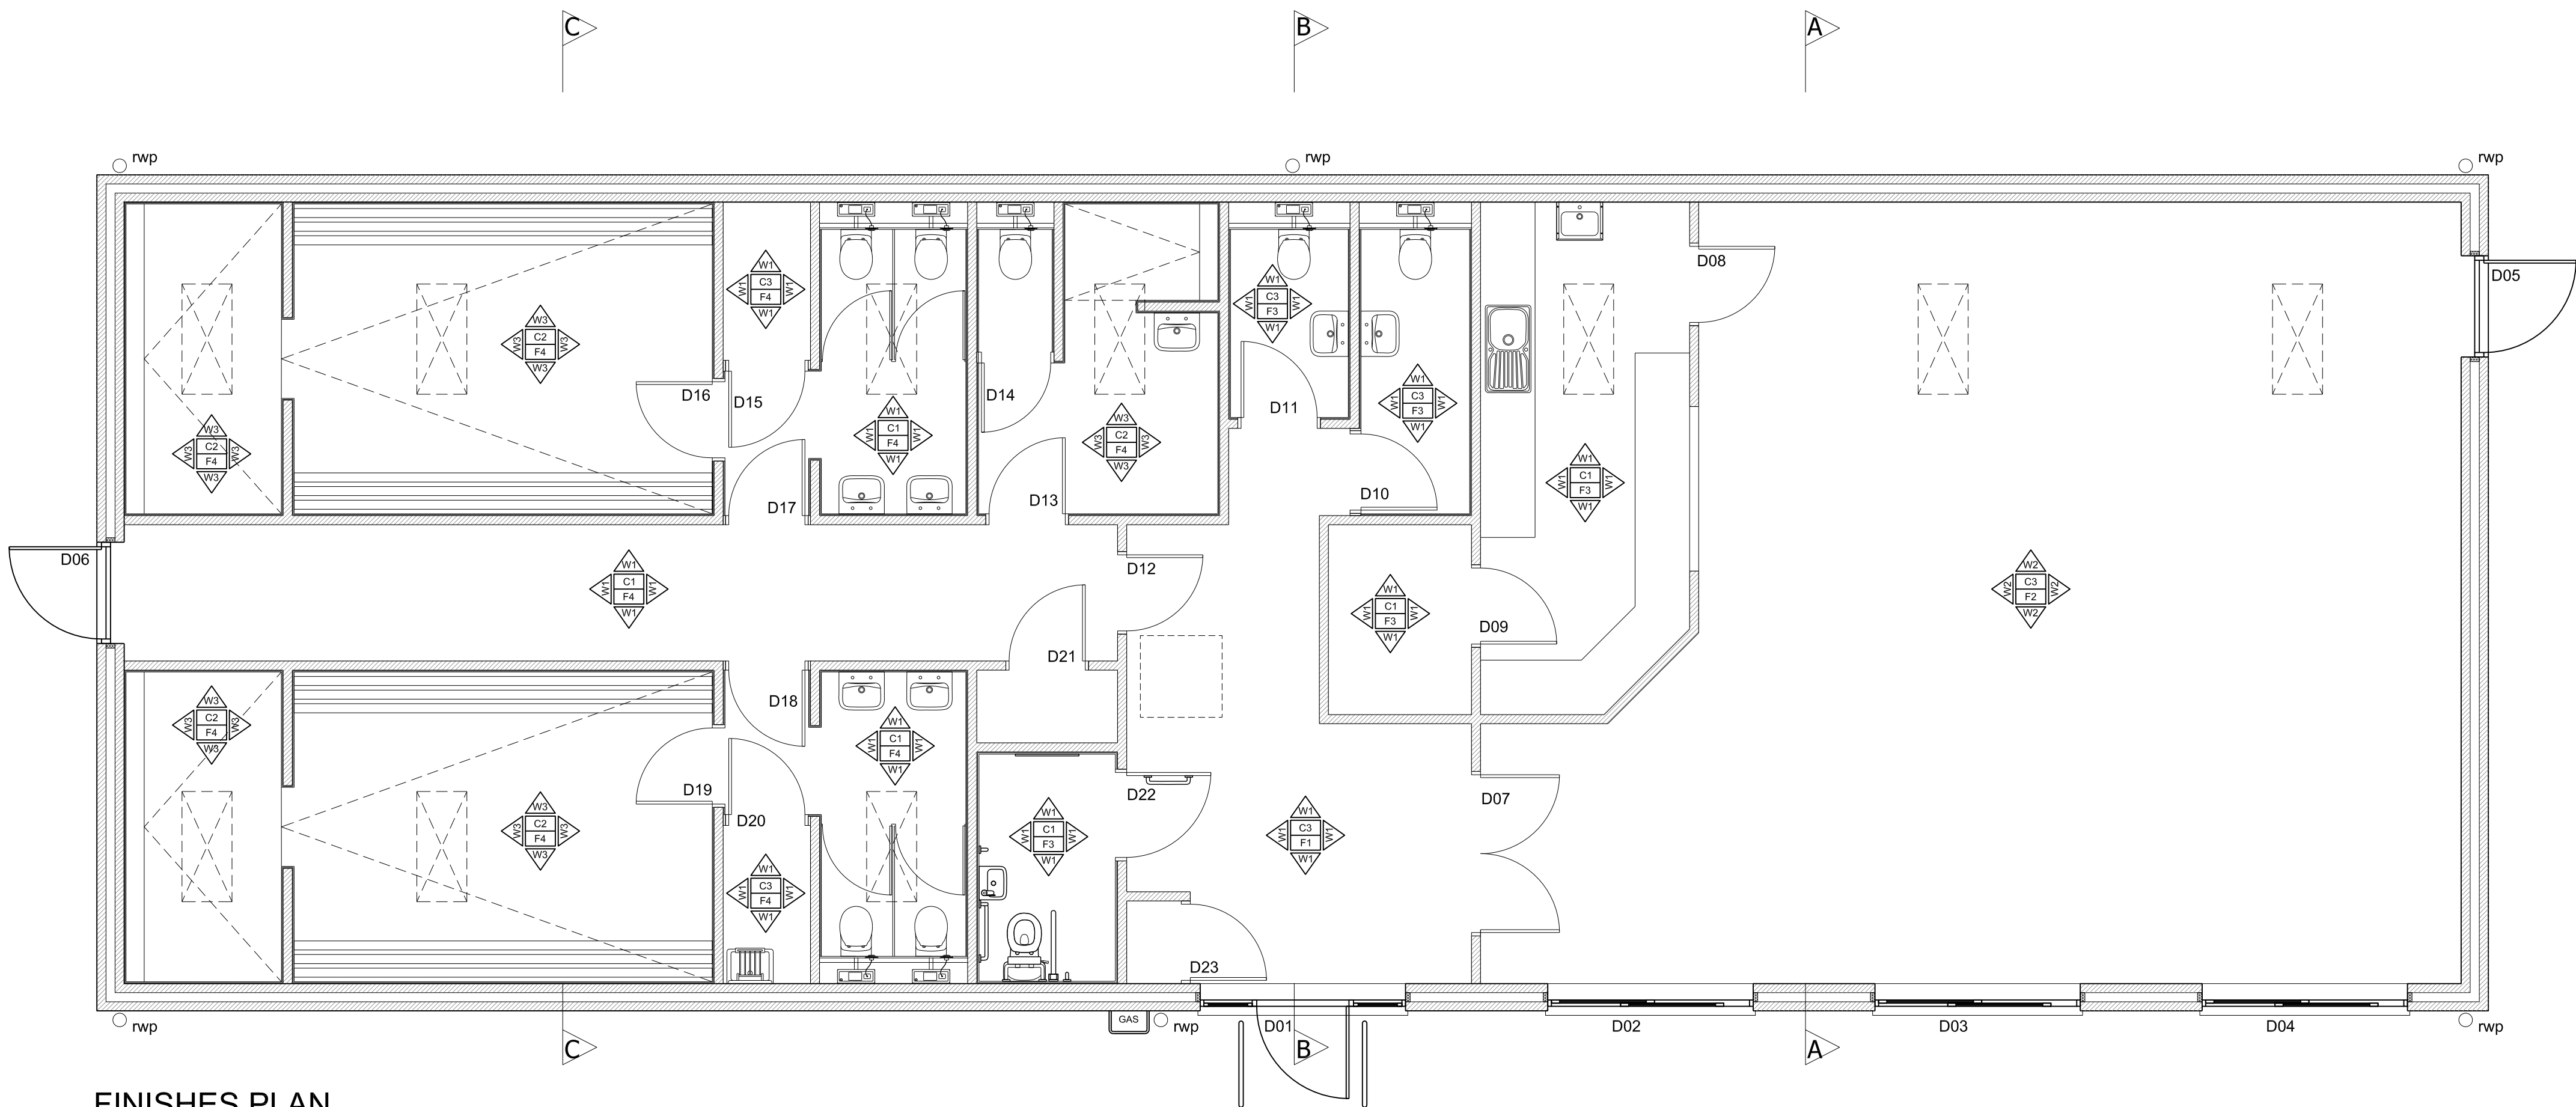

FINISHES PLAN

FINISHES LEGEND:


- F1 Burmatex Grimebuster 50 Carpet tiles with MDF skirting
F2 Burmatex Tivoli Carpet tiles with MDF skirting
F3 Polyflor Polysafe Ecomax with coved skirting
F4 Johnson Tiles Aquila White Bush Hammered with sit on tile skirting
- W1 Emulsion paint on paint grade fair faced blockwork
W2 Emulsion paint on 12,5mm taper edge plasterboard, joints taped and filled, on adhesive dabs
W3 Pilkington Prismo 150 x 150mm ceramic glazed tile with feature band

- C1 Dune Tegalur tile in 24mm suspended grid
C2 Cerama Guard clipped tile in 24mm moisture resistant grid
C3 Emulsion paint on 15mm plasterboard ceiling

Unless noted otherwise, provide 150mm deep Pilkington Prismo tile splashback to all basins, sinks and worktops

Where condition W1-C3 occurs provide perimeter trim to ceiling with shadow batten.

Ceiling type C1 & C2 to have shadow batten detail to perimeter.

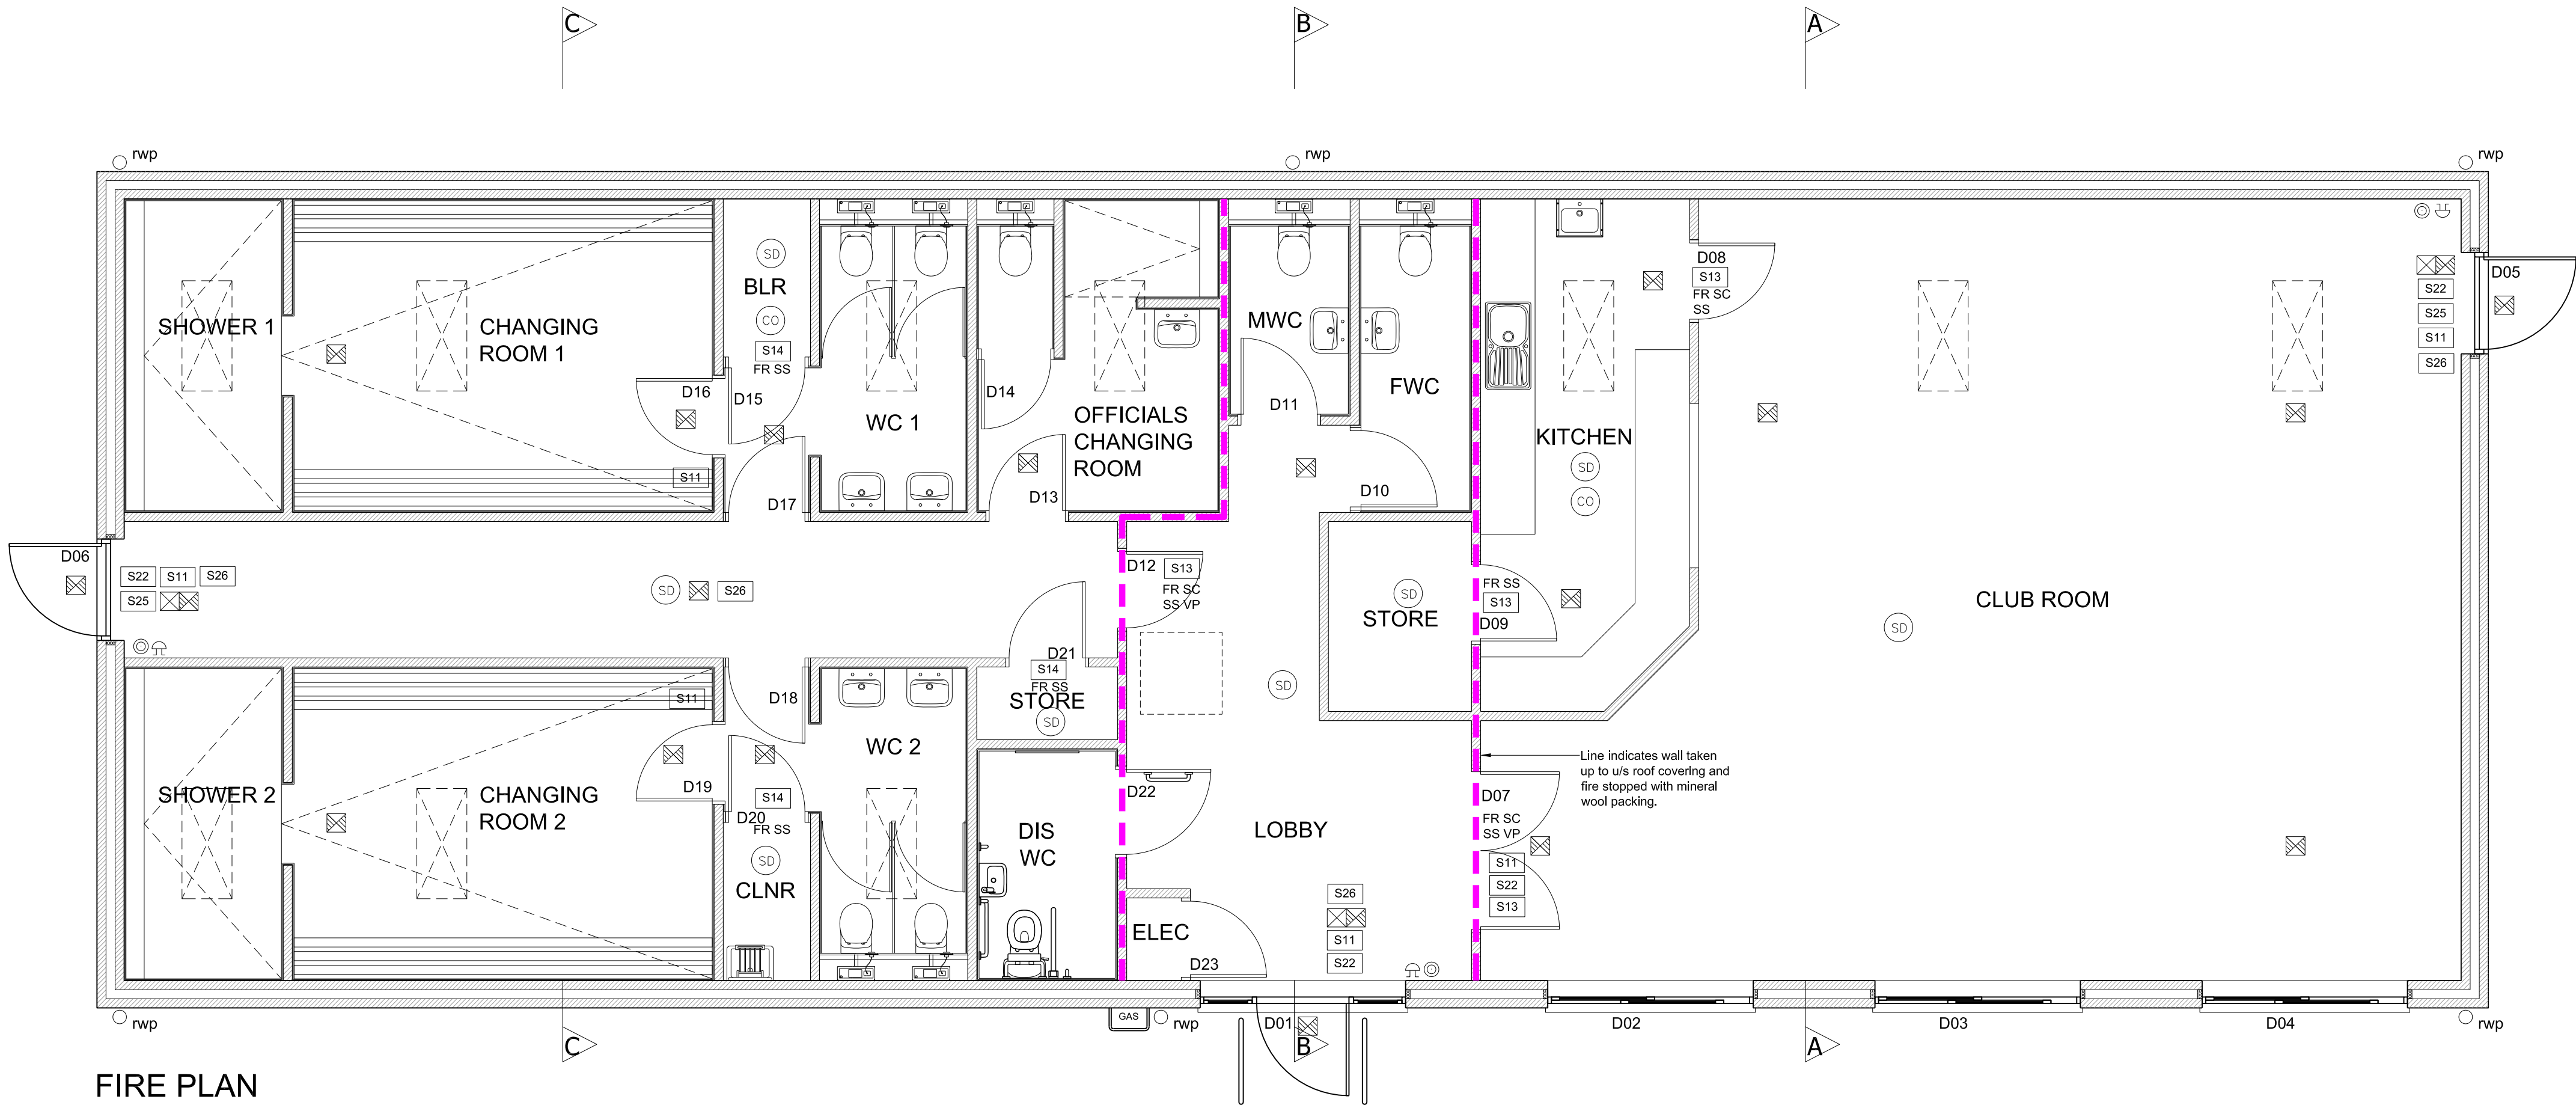

FIRE PLAN

FIRE PLAN LEGEND:

- FR FIRE RATED DOOR
SC SELF CLOSER
SS SMOKE SEALS & INTUMESCENT STRIP
VP VISION PANEL
S11 GENERAL FIRE NOTICE
S13 FIRE DOOR KEEP SHUT(BOTH SIDES OF DOOR)
S14 FIRE DOOR KEEP LOCKED
S22 FIRE EXIT
S25 PUSH BAR TO OPEN
S26 RUNNING MAN' DIRECTIONAL SYMBOL TO BS5499 PT1 AND EEC DIRECTIVE 92/58
- FIRE ALARM SYSTEM MANUAL CALL POINT
1400mm ABOVE GROUND LEVEL
- FIRE ALARM SYSTEM GENERAL SOUNDER
SOUNDER LOCATIONS TO BE DESIGNED BY SPECIALIST
TO ENSURE AUDIBILITY TO ALL AREAS
- SD FIRE ALARM SYSTEM SMOKE DETECTOR (max. 10m spacings)
AUTOMATIC FIRE DETECTORS TO BE BETWEEN 500mm - 7500mm FROM A WALL OR PARTITION
AUTOMATIC FIRE DETECTORS TO BE MIN. 300mm FROM ANY LIGHT FITTING
- HD FIRE ALARM SYSTEM HEAT DETECTOR
- CO CARBON MONOXIDE DETECTOR
- ALL CABLE FOR FIRE ALARM SYSTEM TO BE 1.5mm FIRE TUFF
- S22 EMERGENCY LIGHTING LUMINAIRE
S22 EXIT SIGN (INTERNALLY ILLUMINATED)
- S22 9 LITRE WATER TYPE FIRE EXTINGUISHER TO BS5423
- S22 13/113 A/B AQUEOUS FOAM TYPE FIRE EXTINGUISHER TO BS5423
- S22 2 kg CARBON DIOXIDE TYPE EXTINGUISHER TO BS5423
ALL PORTABLE TYPE FIRE EXTINGUISHERS TO BE HUNG ON WALL BRACKETS
WITH EXTINGUISHER HANDLE 1000mm ABOVE FLOOR LEVEL

REVISION	DESCRIPTION	DATE
----------	-------------	------

	PROJECT	
	Steel Park, Corby	

DRAWING TITLE		
Proposed Finishes & Fire Plans		

DRAWN BY: RH	CHECKED BY:	AUTH BY:
SCALE 1:50 @ A1	DATE June 2015	
DRAWING NUMBER RDC1003-230		REVISION