



NOTES:

1. This drawing is to be read in conjunction with all relevant Engineers drawings and the Specification.
2. The Contractor is responsible for all dimensions and for the correct setting out of the work on site. Only figured dimensions are to be used. Any discrepancies are to be reported to The Engineer before proceeding.
3. All materials and workmanship to comply with the current British Standards and Codes of Practice.

Penzance Gallery
Ground Floor Boiler Plantroom
CP1

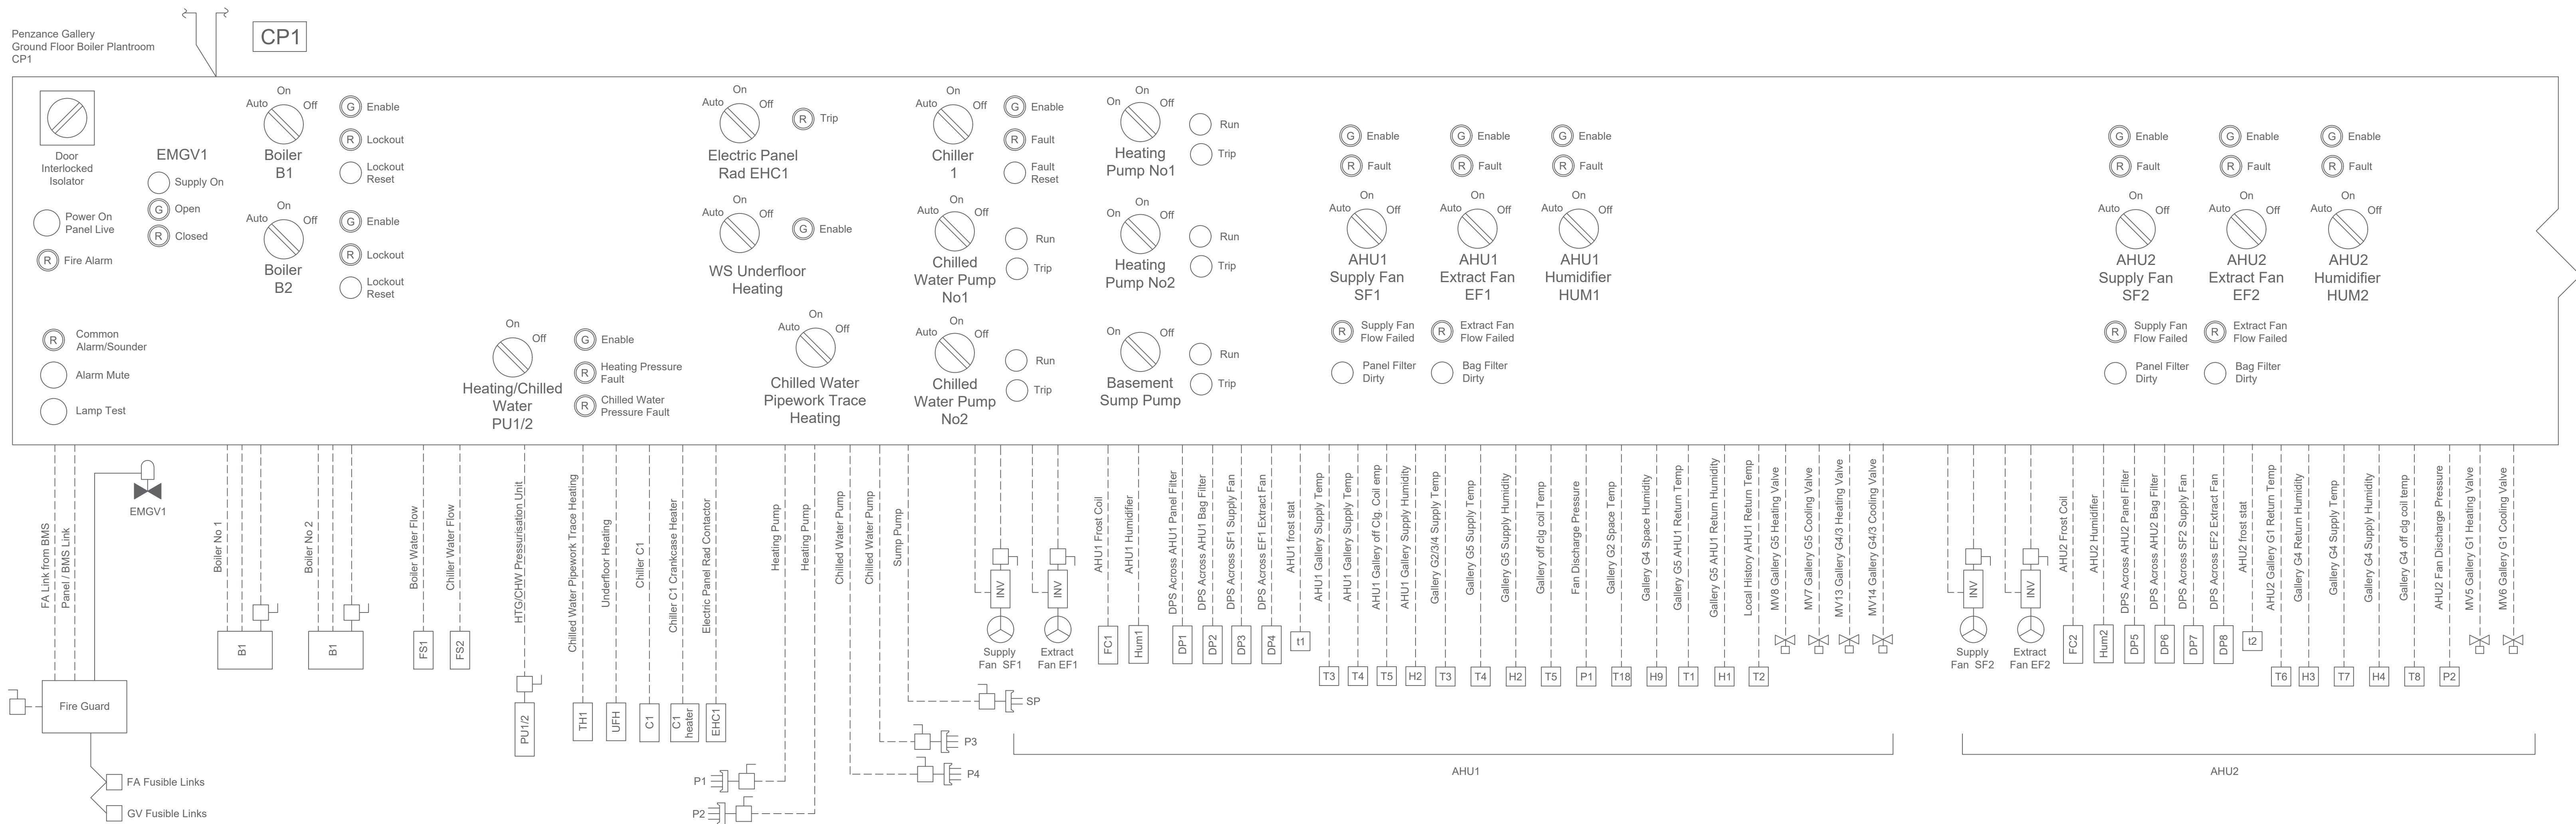

Fireman's Ventilation Switch
(In Reception Area)

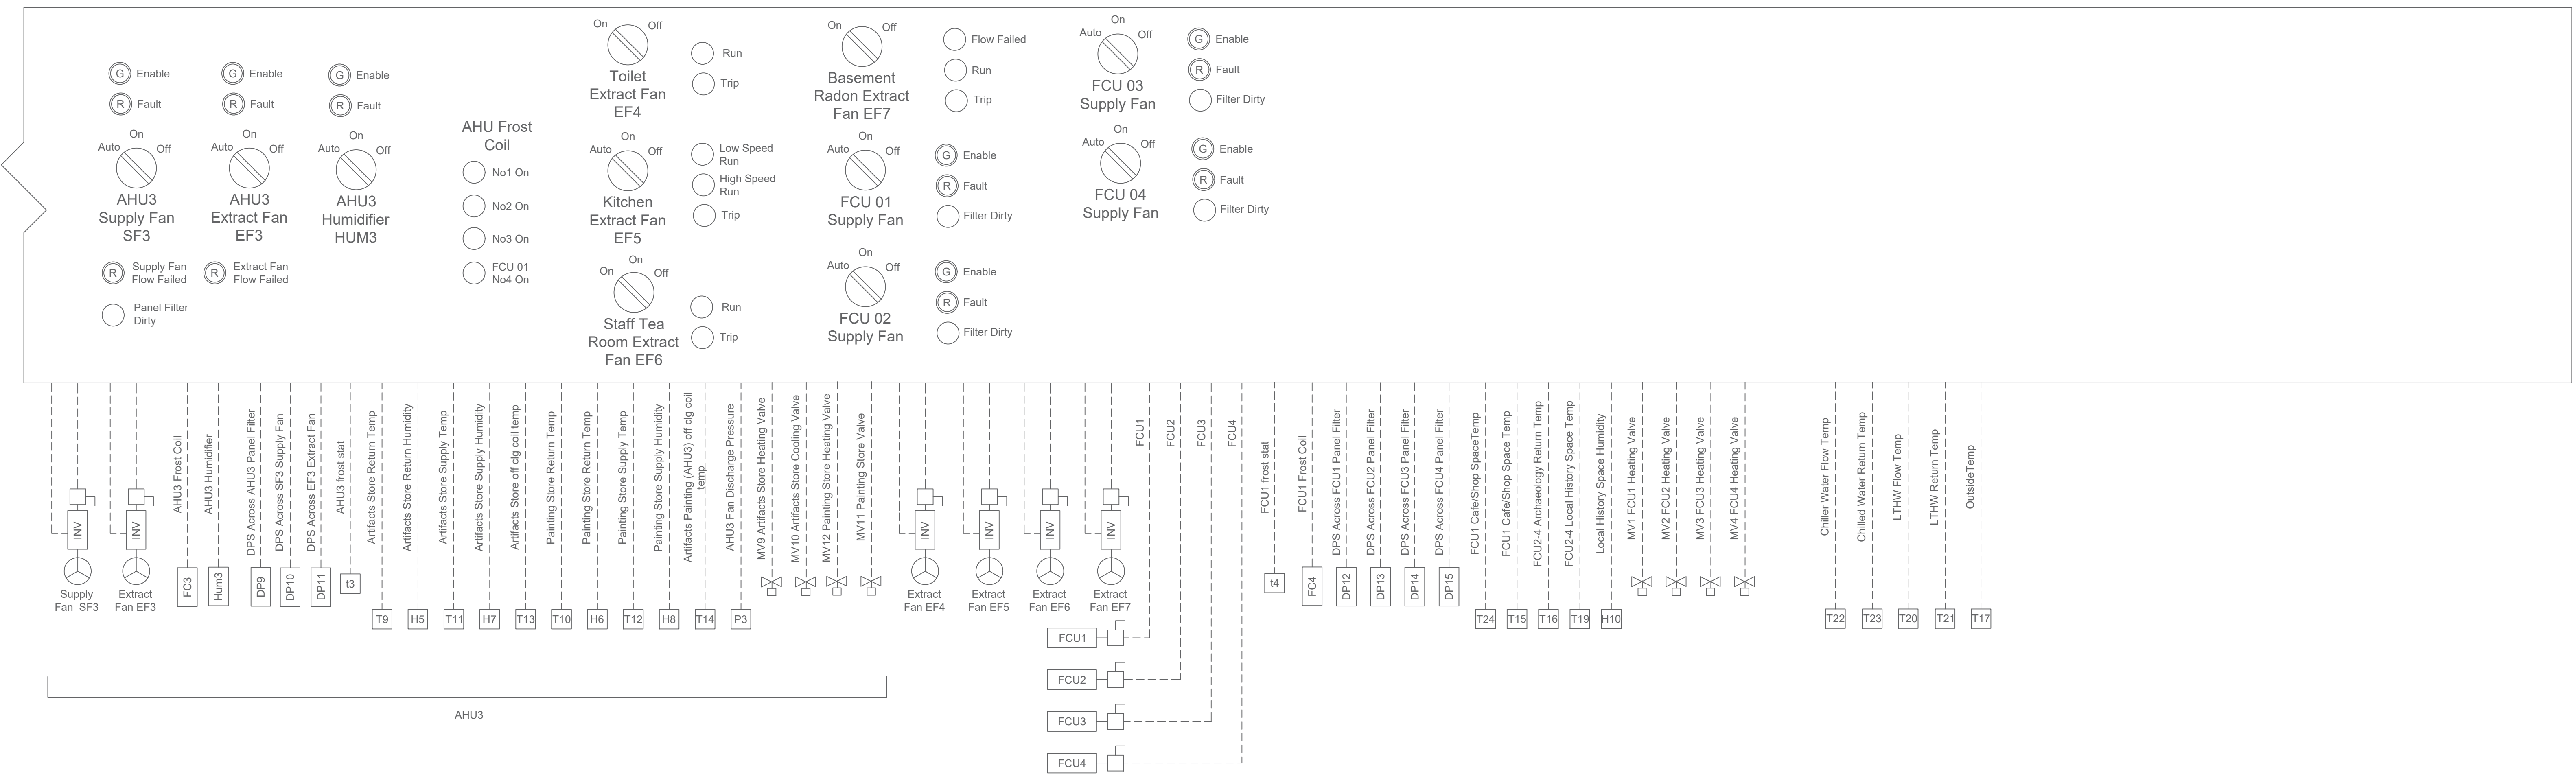

A	Room names revised	By	BN	13/09/2024
Issued for Client Information		By	BN	13/09/2024
Rev.	Amendment	By	BN	13/09/2024
Issued Only For Purpose Indicated		By	BN	13/09/2024

GPJ Consulting Engineers

4 The Setons, Tolvaaddon Energy Park,
Tolvaaddon, Camborne, Cornwall. TR14 0HX
Telephone: 01209 612030
Email: enquiries@gpjconsulting.co.uk
Web: www.gpjconsulting.co.uk

Drawing Title
Existing BMS Panel Schedule

Project
Penlee House Gallery
Penzance
Cornwall

Design
XXX

Date
22/01/24

Scale
as A3
NTS

Drawn
HM

Drawing No.
2752 ME01 A