


THIS DRAWING IS INDICATIVE AND REPRESENTS ONLY THE DESIGN INTENT, THE CONTRACTOR MUST PRODUCE FULLY CO-ORDINATED WORKING / INSTALLATION DRAWINGS AS REFERRED TO IN THE CONTRACT DOCUMENTATION

NOTES

- DO NOT SCALE FROM THIS DRAWING. ALL DIMENSIONS INDICATED ARE IN MILLIMETRES
- DRAWING TO BE READ IN CONJUNCTION WITH SPECIFICATION, DOCUMENTATION, DRAWINGS & ALL RELEVANT BRITISH STANDARD DOCUMENTS
- ALL ELECTRICAL WORKS SHALL COMPLY WITH 18TH EDITION IET WIRING REGS BS7671:2018 (2018), INCLUDING ALL CURRENT AMENDMENTS AND GUIDANCE NOTES AND THE CURRENT BUILDING STANDARDS REGULATIONS
- THE INSTALLATION SHALL ONLY BE CERTIFIED BY A PERSON OR A COMPANY HAVING MEMBERSHIP TO S.E.L.E.C.T. OR N.I.C.E.I.C. OR SIMILAR ELECTRICAL SCHEMES

LEGEND

- SINGLE SWITCHED SOCKET OUTLET
- TWIN SWITCHED SOCKET OUTLET
- SOCKET OUTLET c/w TWIN USB PORT
- SHAVER SOCKET OUTLET
- IP66 RATED EXTERNAL SOCKET OUTLET
- SPN ISOLATOR
- TPN ISOLATOR
- UNSWITCHED FUSED CONNECTION UNIT (OPTIONAL PILOT LIGHT)
- SWITCHED FUSED CONNECTION UNIT (OPTIONAL PILOT LIGHT)
- FUSED GRID SWITCH FOR HOB, OVEN, MICROWAVE, FRIDGE FREEZER, DISHWASHER & WASHING MACHINE WITHIN CABINET AT HIGH LEVEL
- SINGLE UNSWITCHED SOCKET OUTLET / BLANK PLATE AT LOW LEVEL TO FUSED CONNECTION / GRID SWITCH AT MID (COUNTER) LEVE
- TWIN RJ45 DATA OUTLET
- INCOMING BT OUTLET
- TV / FM / SAT TRIPLEXER OUTLET
- CCTV OUTLET
- PANELBOARD
- DISTRIBUTION BOARD

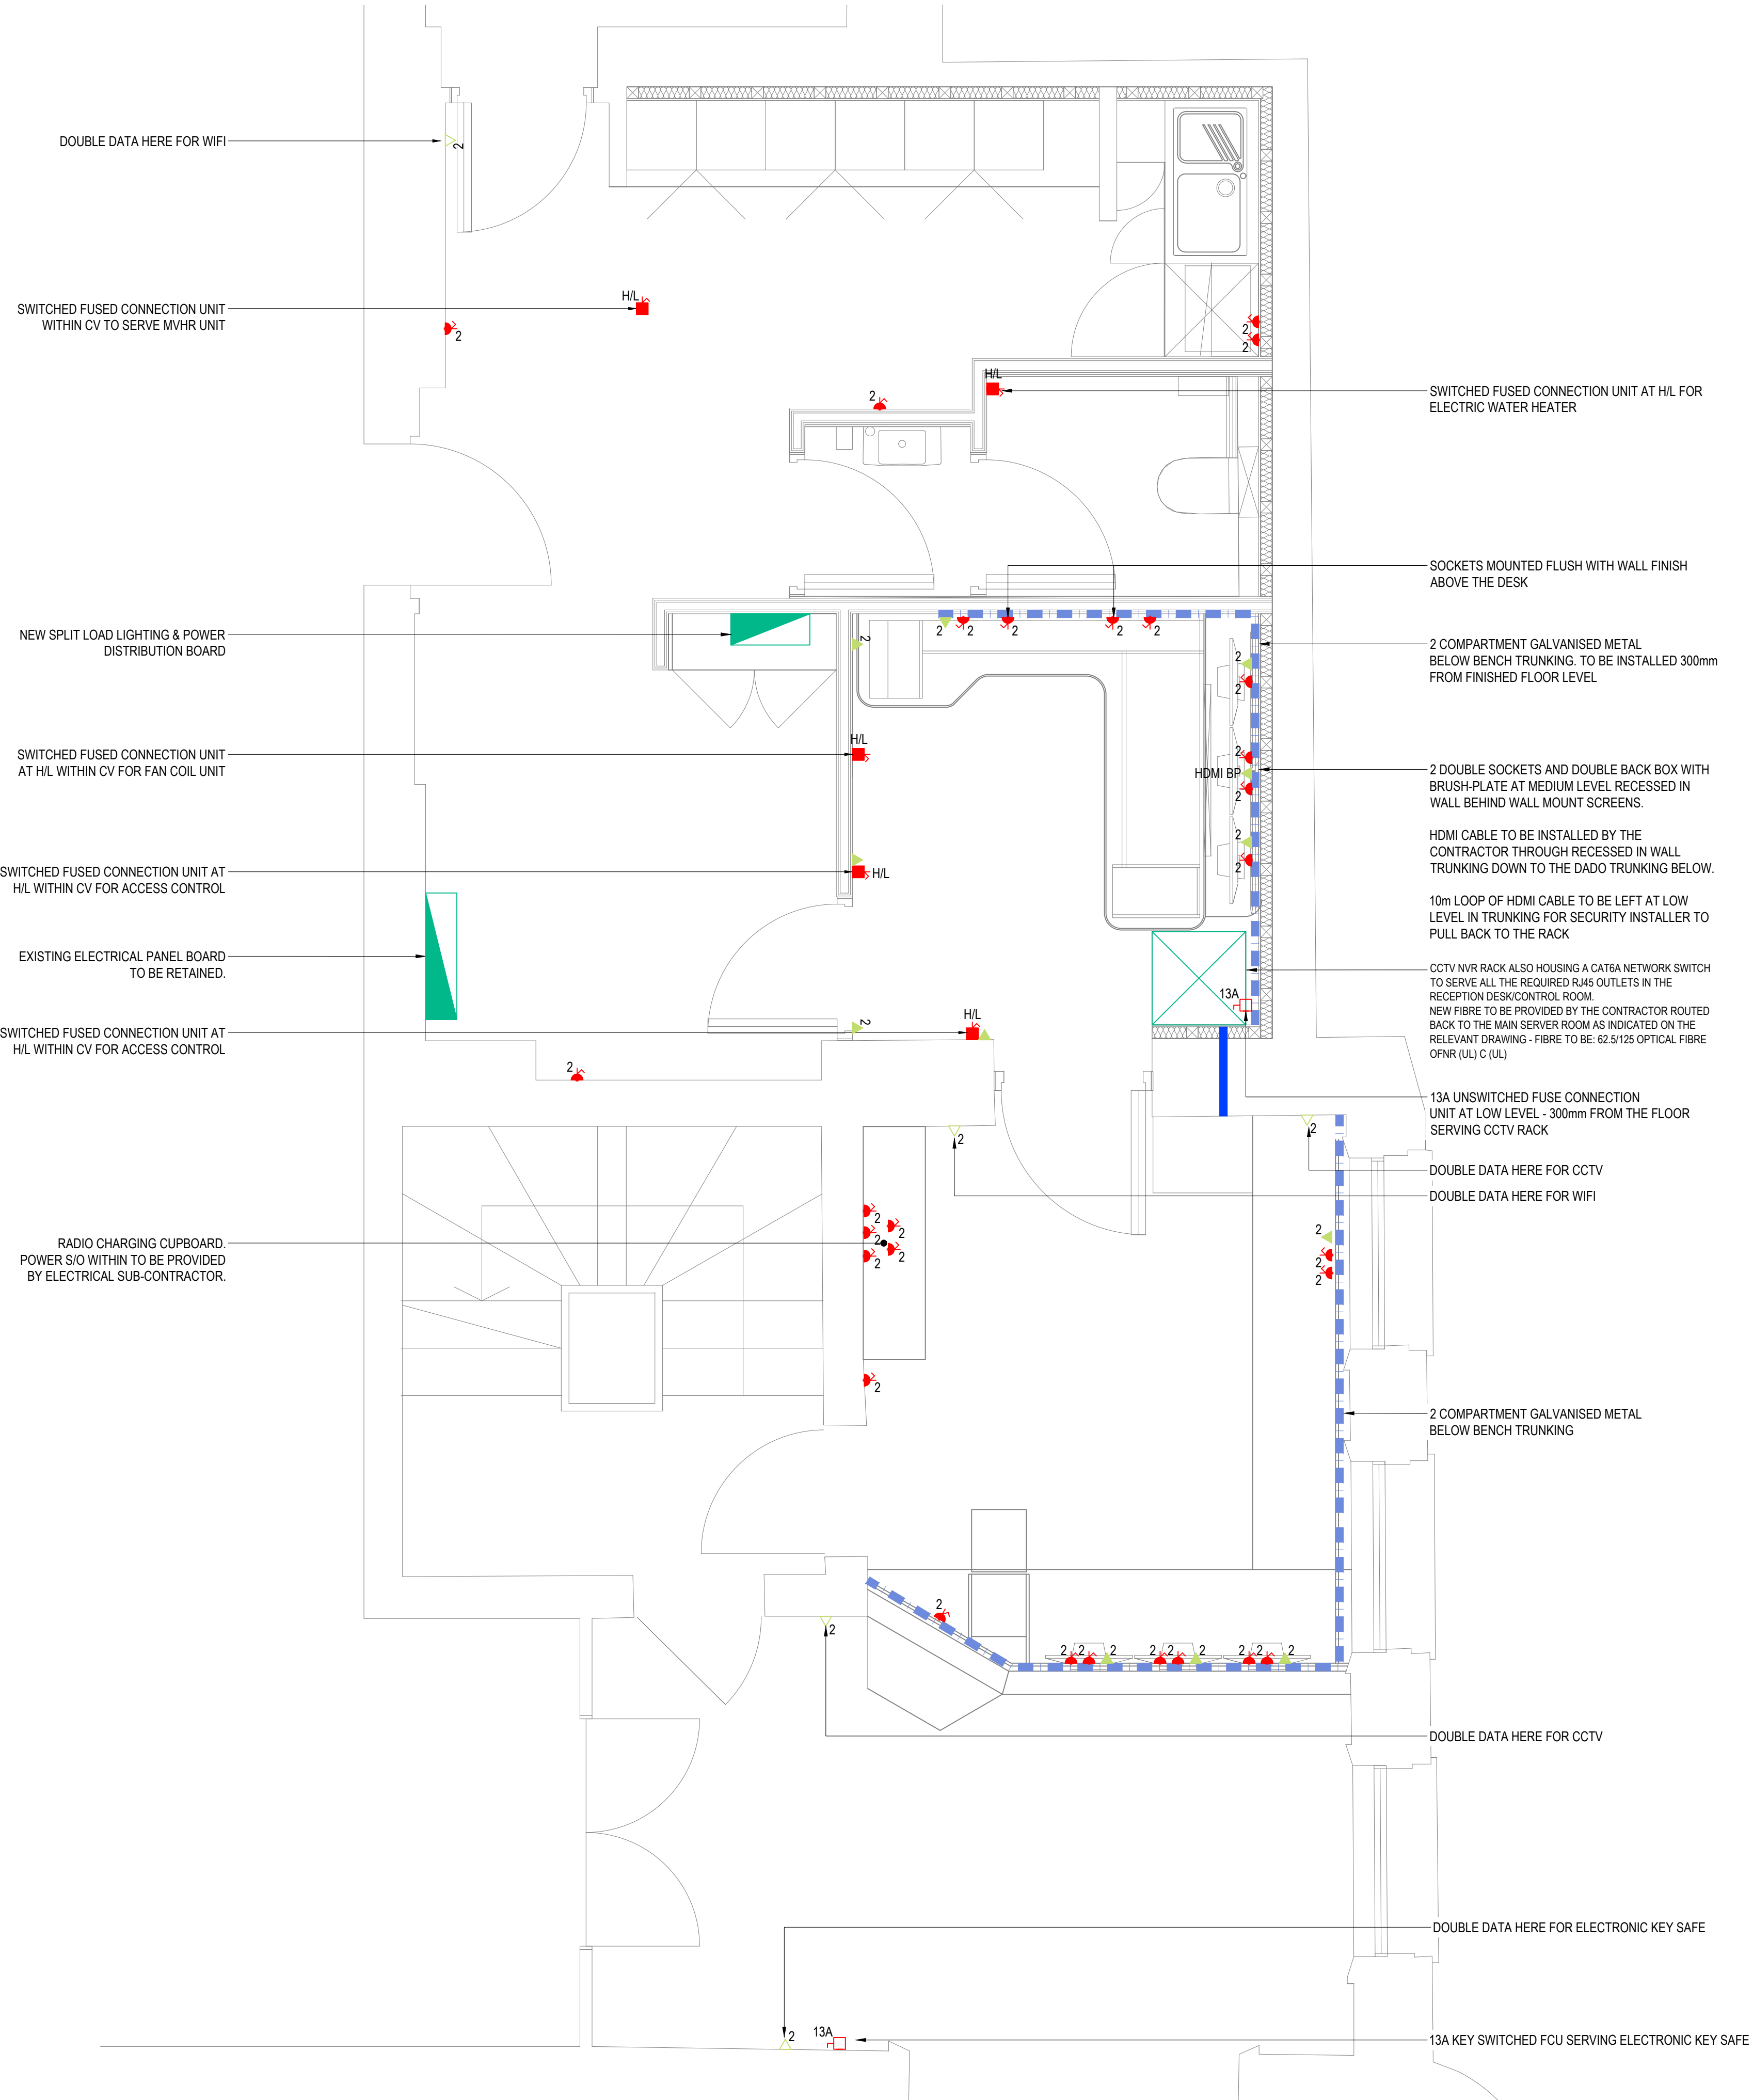

P03	UPDATED TENDER ISSUE	AJ	AJ	AJ	27.10.21
P02	TENDER ISSUE	SM	AJ	AJ	15.10.21
P01	STAGE 3	SM	AJ	AJ	01.10.21
REV	DESCRIPTION	BY	CHK	APP	DATE

Project Status:	TENDER
-----------------	--------



The Multi-disciplinary Engineering Consultancy

Ground Floor, 45 Great Guildford Street
London, SE1 0ES
T 44 (0) 203 735 5060
E london@harleyhaddow.com
Edinburgh | London | Glasgow
harleyhaddow.com
Association for Consultancy and Engineering Member Firm

Project: 307685
**HORNIMAN MUSEUM
STAFF RECEPTION & REST
AREA REFURBISHMENT**

Drawing Title:
SMALL POWER & DATA LAYOUT

Scale @ A1 1:25	Date OCT 2021	Engineer AJ	Revision P03
--------------------	------------------	----------------	-----------------