



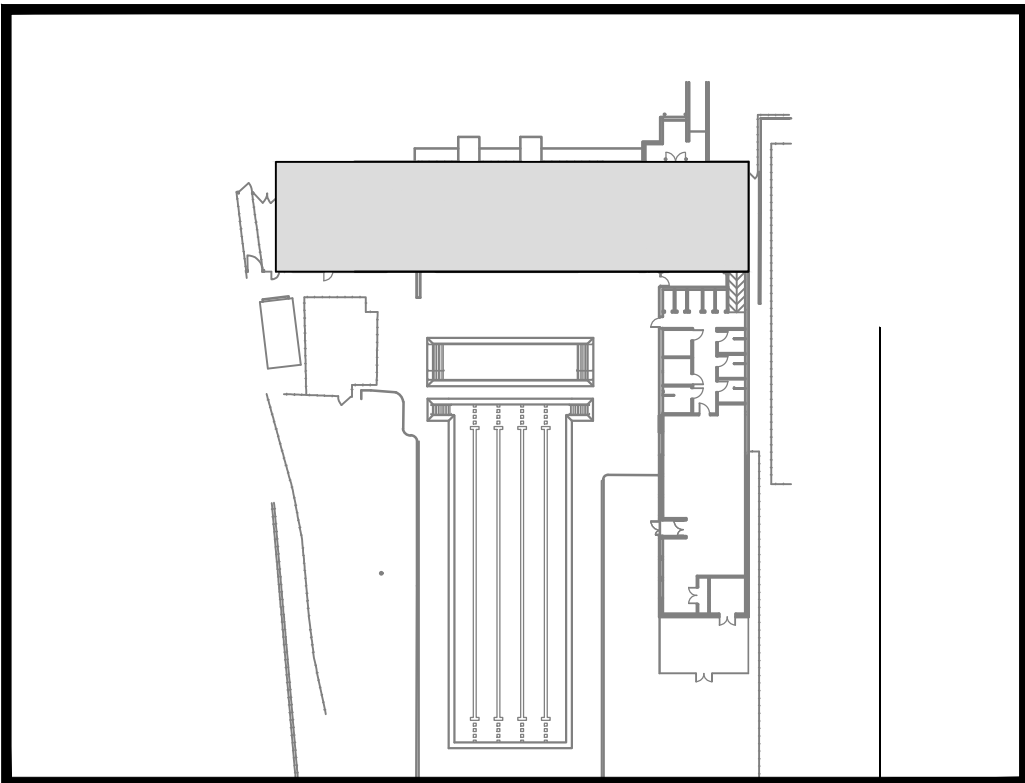

KEY PLAN (NTS)

ELECTRIC RADIANT PANEL SCHEDULE								
Ref	Location	Manufacturer	Type	Emitter				Output (w)
				Height (mm)	Length (mm)	Depth (mm)	Model	
RP01	Access WC 1	BN Thermic	RP3	25	595	595	RP3-03	300
RP02	Waiting Area	BN Thermic	RP3	25	1192	595	RP3-06	600
RP03	Waiting Area	BN Thermic	RP3	25	1192	595	RP3-06	600
RP04	Waiting Area	BN Thermic	RP3	25	1192	595	RP3-06	600
RP05	Corridor	BN Thermic	RP3	25	1192	595	RP3-06	600
RP06	Corridor to Pool	BN Thermic	RP3	25	595	595	RP3-03	300
RP07	Corridor to Pool	BN Thermic	RP3	25	595	595	RP3-03	300
RP08	Corridor to Pool	BN Thermic	RP3	25	595	595	RP3-03	300
RP09	Reception	BN Thermic	RP3	25	1192	595	RP3-06	600
RP10	Office	BN Thermic	RP3	25	595	595	RP3-03	300
RP11	Staff Room	BN Thermic	RP3	25	1192	595	RP3-06	600
RP12	Staff Room	BN Thermic	RP3	25	1192	595	RP3-06	600
RP13	Rest Room	BN Thermic	RP3	25	1192	595	RP3-06	600
RP14	Toilet	BN Thermic	RP3	25	595	595	RP3-03	300
RP15	Kitchenette	BN Thermic	RP3	25	595	595	RP3-03	300
RP16	Corridor to Changing Village	BN Thermic	RP3	25	1192	595	RP3-06	600
RP17	Corridor to Changing Village	BN Thermic	RP3	25	1192	595	RP3-06	600

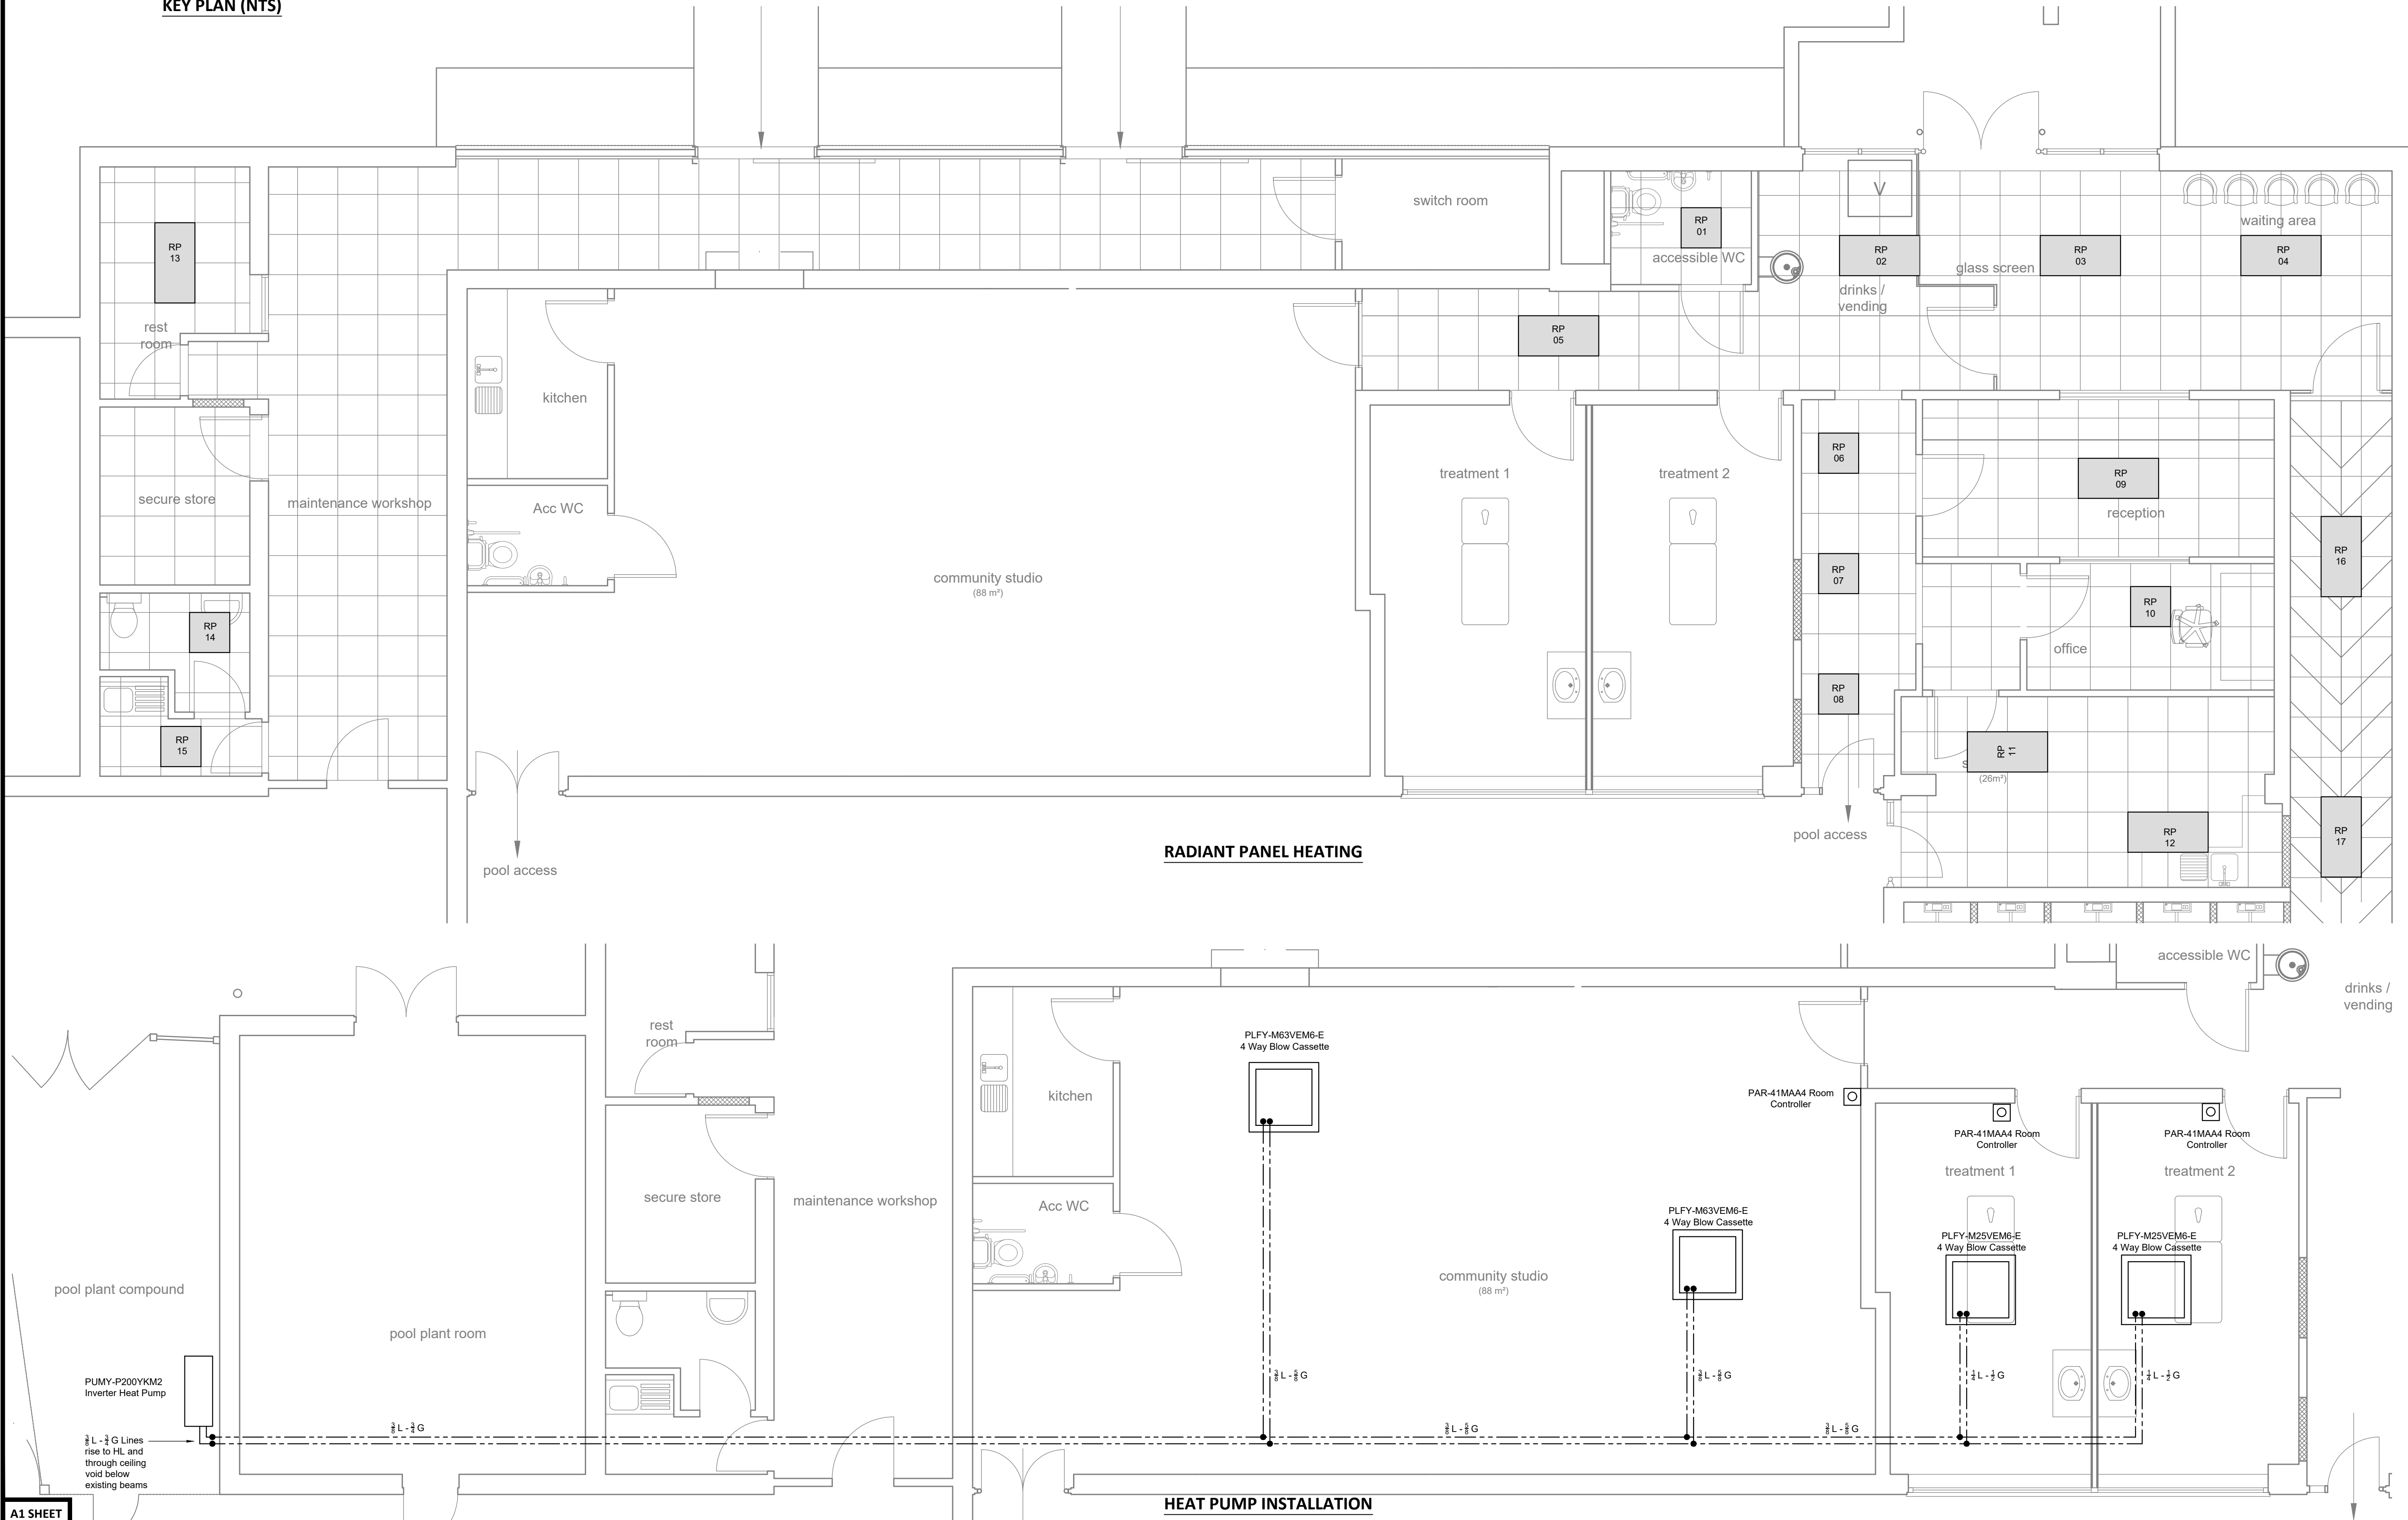

This drawing is not to be scaled. All dimensions to be checked on site and any discrepancies to be reported to PB Design and Consultancy Ltd. All material is produced on behalf of PB Design and Consultancy Ltd. All drawings to be read in conjunction with specification where applicable.

GENERAL NOTES

This drawing to be read in conjunction with the mechanical specification

Do not Scale from this drawing

DRAWING SPECIFIC NOTES

- All existing electric heaters to be removed.
- New radiant panels to be co-ordinated with lighting layouts.
- Heat Pump System as manufactured by Mitsubishi Electric Europe B.V., Travellers Lane, Hatfield, Herts, AL10 8XB
- All refrigerant pipework to be insulated and installed on suitable tray mounted below the existing roof beams.

LEGEND

- PIPEWORK CEILING OR ROOF VOID
- ELECTRIC RADIANT PANEL
- CEILING CASSETTE
- ROOM CONTROLLER
- LIQUID REFRIGERANT LINE
- GAS REFRIGERANT LINE

T01	11.09.24	Tender Issue
Rev	Date	Description

PB Design and Consultancy Ltd
Woodside Cottage, Wood Lane, Renhold, Bedford, MK41 0LT
Tel - 01772 2631594
e-mail - peter@pbdesignltd.co.uk

CLIENT
Ware Town Council
The Priory
High Street, Ware
Hertfordshire,
SG12 9AL

PROJECT
Ware Priory Lido
Priory Street, Ware
Hertfordshire,
SG12 0DE
Proposed Extension and Refurbishment

PROJECT NUMBER 240502

DRAWING TITLE
Proposed Electric Heating and Heat Pump Services
Plan 1 of 2

DATE	October 2024	SCALE	1:50
DRAWN BY	PM	CHK	PM
DRAWING No	240502-M01	REV	T01