

1. DO NOT SCALE THIS DRAWING

1. DO NOT SCALE THIS DRAWING.
2. DO NOT ALTER BY HAND.
3. THIS DRAWING IS TO BE READ IN CONJUNCTION WITH ALL OTHER RELEVANT DRAWINGS AND SPECIFICATIONS.
4. ALL DIMENSIONS ARE IN MILLIMETRES UNLESS STATED OTHERWISE.
5. FOR BUILDERS WORK DETAILS PLEASE SEE DRG. NO. 106-BW-201

AS Inst.	As Installed Issue.	CAT	20
Rev	Amendments	By	Date
Drawing Status: As Installed		Approval Status: N/A	

Drawing Status: As Installed	Approval Status: N/A
--	--------------------------------

AS Installed	N/A
--------------	-----



Sam Derry House,
London Road,
NEWARK, NOTTS, NG24 1JP
Tel: 01636 614300 Fax: 01636 605387
Email: design@derry-bs.co.uk




Corby East Midlands
International Swimming Pool

External Lighting Layout

Drawn By: C. Tomlinson	Engineer: L. O'Brien	Rec Copy Chk: R.A.I.
Primary Scale: 1:150	Size: A1	Date Created: June 2000

Drawing Number: 106-E-611	Revision: A1
-------------------------------------	------------------------

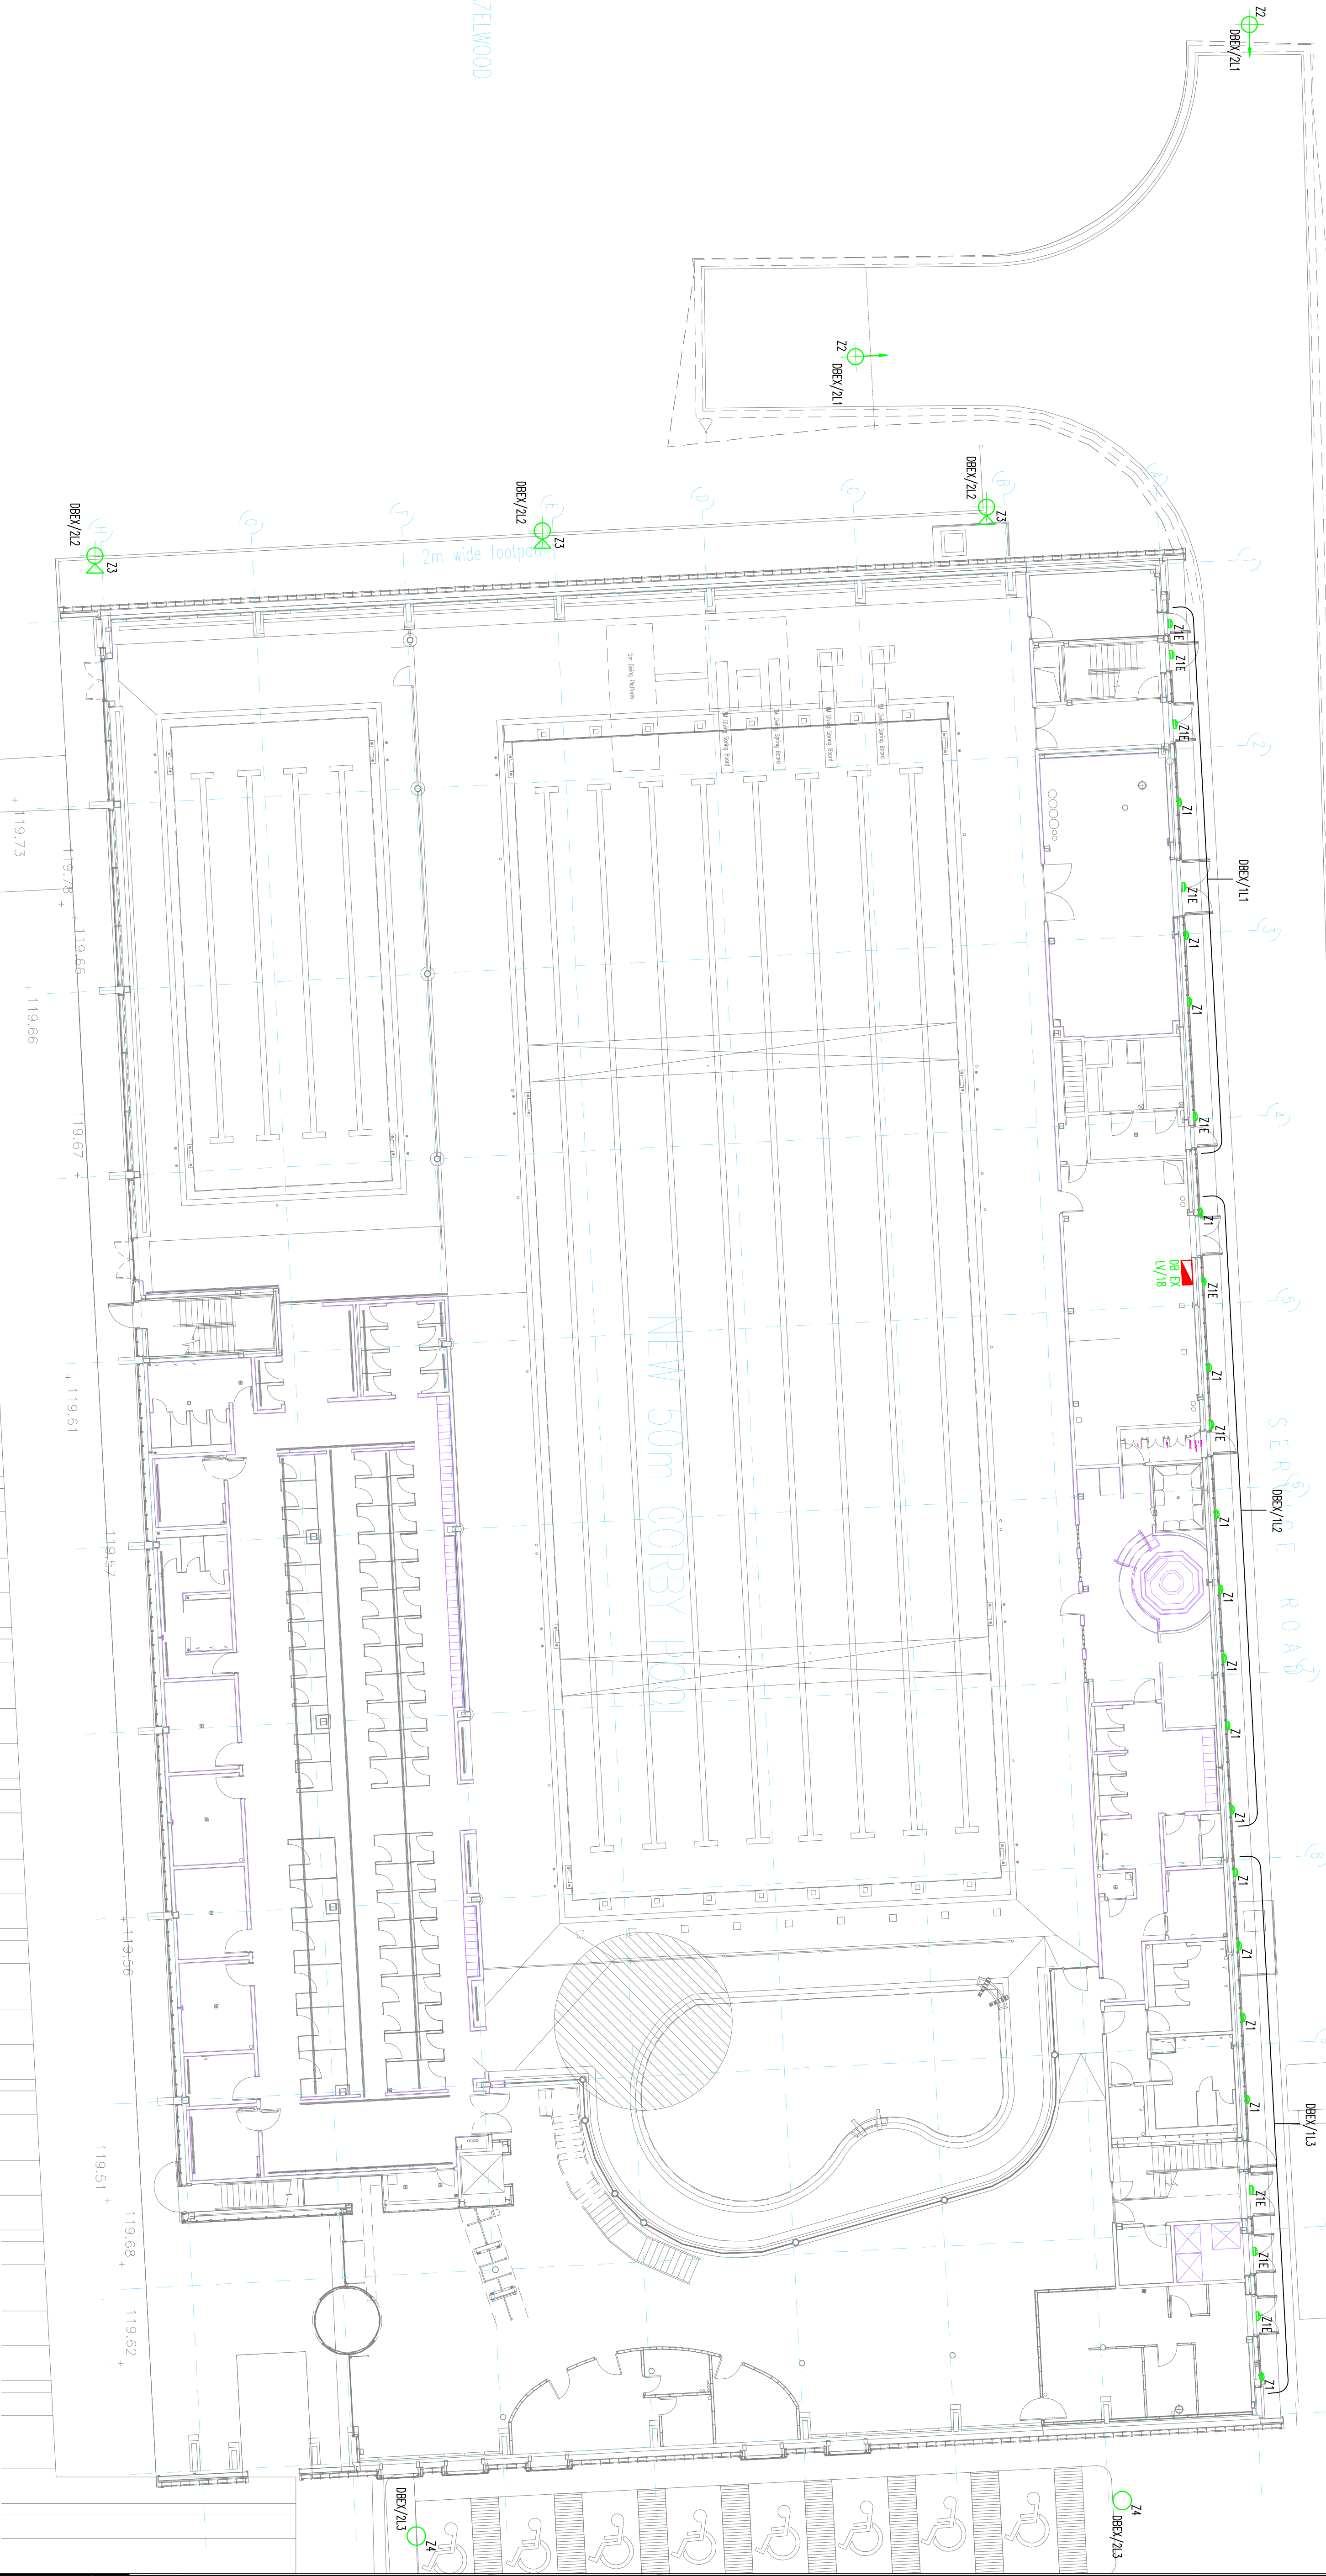

- NOTES:-**
1. ALL LIGHTING TO BE PHOTO CELL AND TIME CLOCK CONTROLLED
 2. CORRY WALK UNITS 24 SUPPLIED AND INSTALLED AS SEPARATE CONTRACT
 3. FEATURE LIGHTING BY WK SOLUTION FOR EXTERNAL GLULAM TO BE FITTED TO THE LCT COLUMN
 4. DISABLED PARKING COLUMNS TO BE AS 24 UNITS, BUT AS PART OF THIS CONTRACT. SUPPLIERS WOODHOUSE UK

LEGEND

- | | | |
|---|-----|---|
|  | Z1 | D.M. WINSTON ALP2082B32 28W 20
LARGE BILHAFO (BULGING MOUNT) |
|  | Z1E | D.M. WINSTON ALP2082B32 28W 20 LARGE
BILHAFO (BULGING MOUNT) |
|  | Z2 | D.M. WINSTON ML4C7F51025DOW 100W
COP-1 5-53 DIAMOND OPT. (SMALL
COLUMN) |
|  | Z3 | D.M. WINSTON ML4C7F51025DOW 100W
COP-1 31-35 DIAMOND OPT. (SMALL
COLUMN) + WINSTON 70W COP-1
(MOUNTED ON COLUMN BULGE LAMPS) |
|  | Z4 | COLUMN ESCORT FILL 9
9610000 AREA FLOOD 150W
HT-DEPT5/11/83D WHI |