


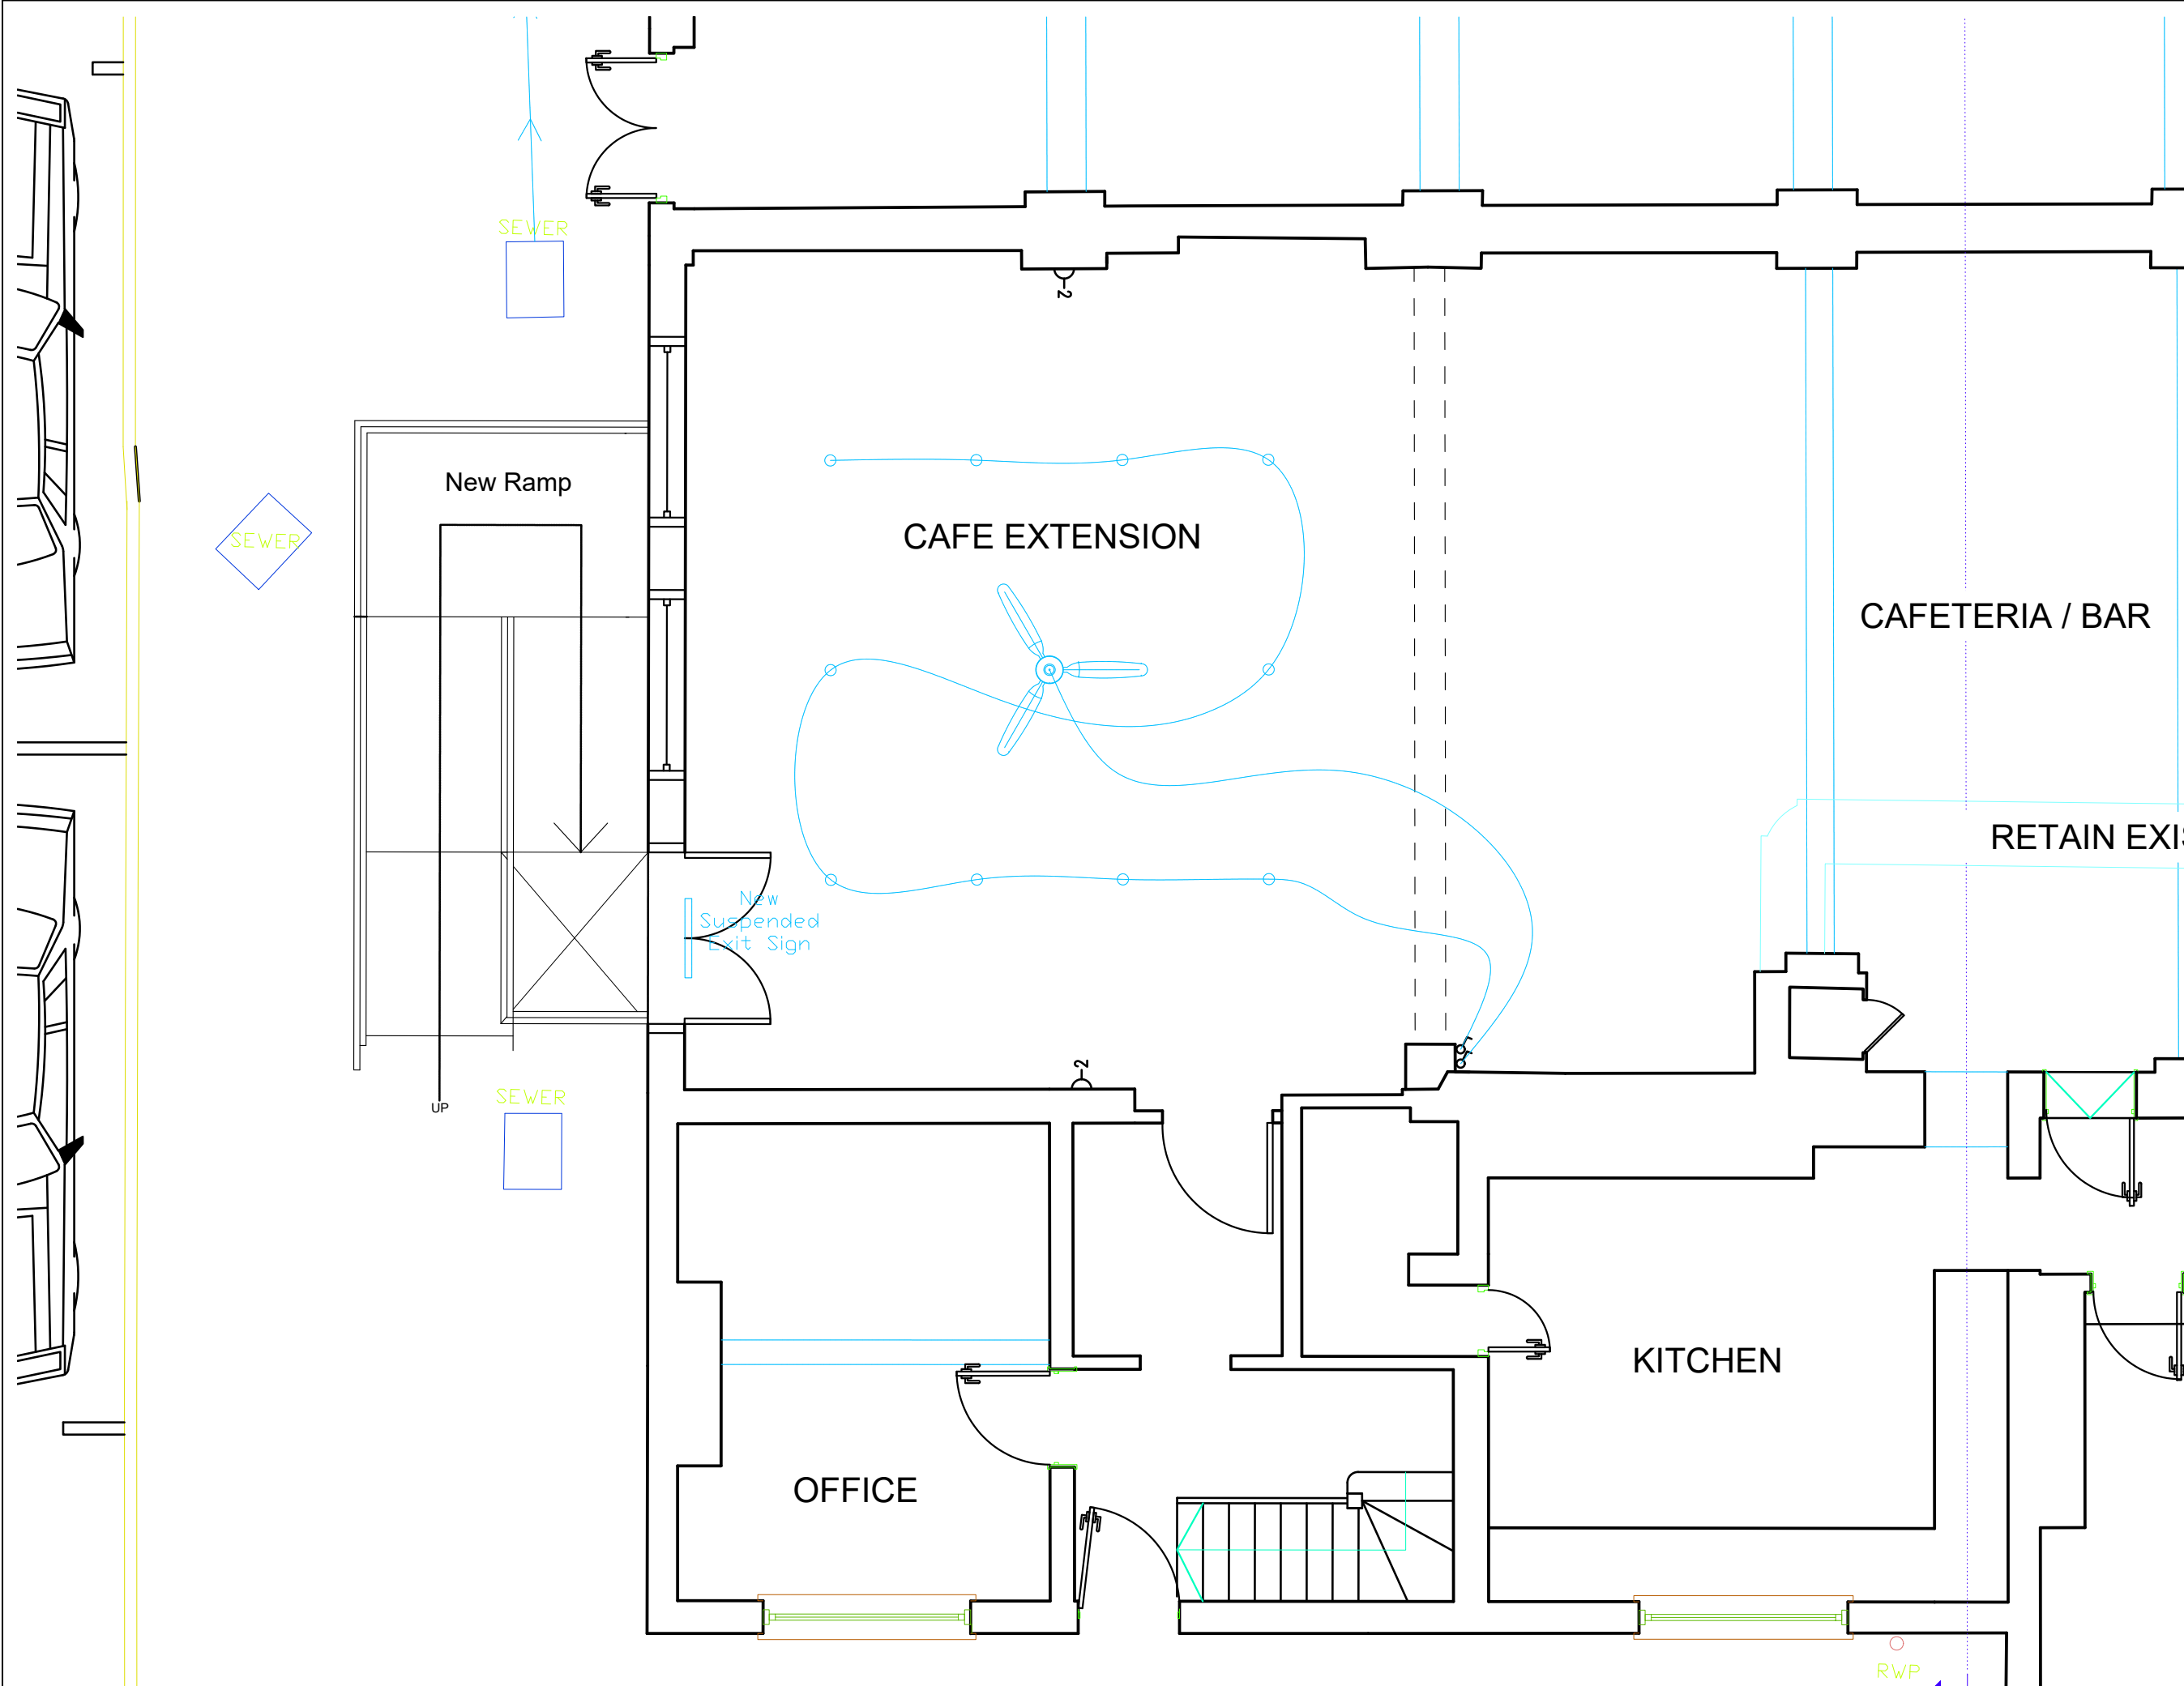

NOTES

- 1) ALL DIMENSIONS TO BE CHECKED ON SITE
- 2) ALL SCALED DIMENSIONS TAKEN FROM THIS DRAWING SHOULD BE CONFIRMED BY JOHNSON GILLIES LTD
- 3) JOHNSON GILLIES LTD SHALL BE INFORMED IN WRITING OF ANY DISCREPANCIES.
- 4) ALL DIMENSIONS ARE IN MILLIMETERS ONLY.

REVISIONS

No.	Date	Amendments	Initial

THIS DRAWING IS FOR THE FOLLOWING PURPOSE ONLY:
PRELIMINARY ☐ TENDER ☐ CONSTRUCTION ☐
SKETCH ☐ MEASURED SURVEY ☐ CONTRACT ☐

TITLE

Cafe Electrical Plan

CLIENT

Leigh-on-Sea Town Council

PROJECT NAME

Leigh Community Centre

JG Johnson Gillies Ltd
Chartered Building Surveyors & Building Consultants

Irongate House
30 Dukes Place
London
EC3A 7LP
T: +44 (0)20 7377 6247

Former HMS Essex
135 Ness Road
Shoeburyness
Essex SS3 9ES
T: +44 (0)1702 293413

E: info@johnsongillies.co.uk
W: www.johnsongillies.co.uk

UNITED KINGDOM
●LONDON●ESSEX●

DRAWN BY ZM	DATE Aug '19
SCALE 1/50@A3	CHECKED JG
DRAWING NO. 10275/T/04	REV. NO.