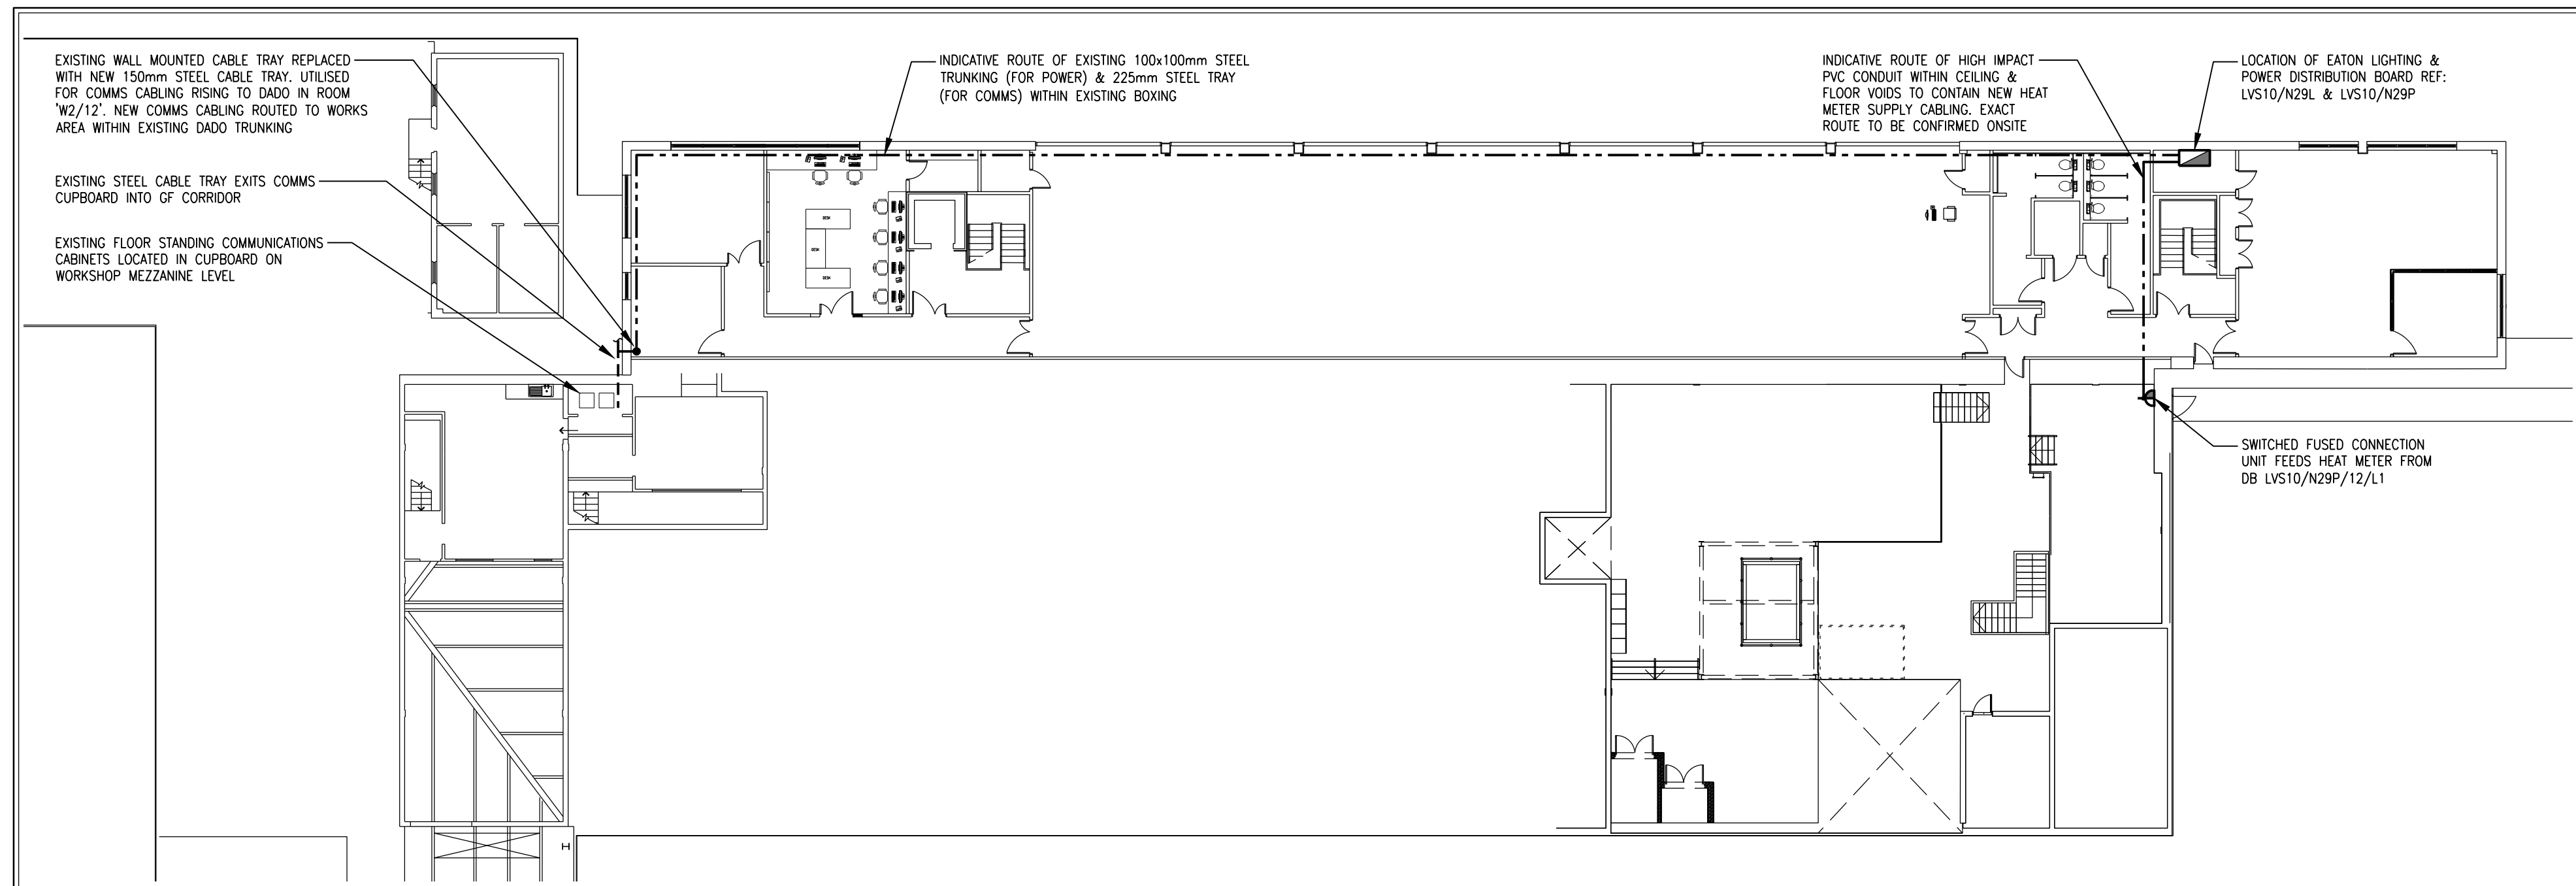


Do Not Scale

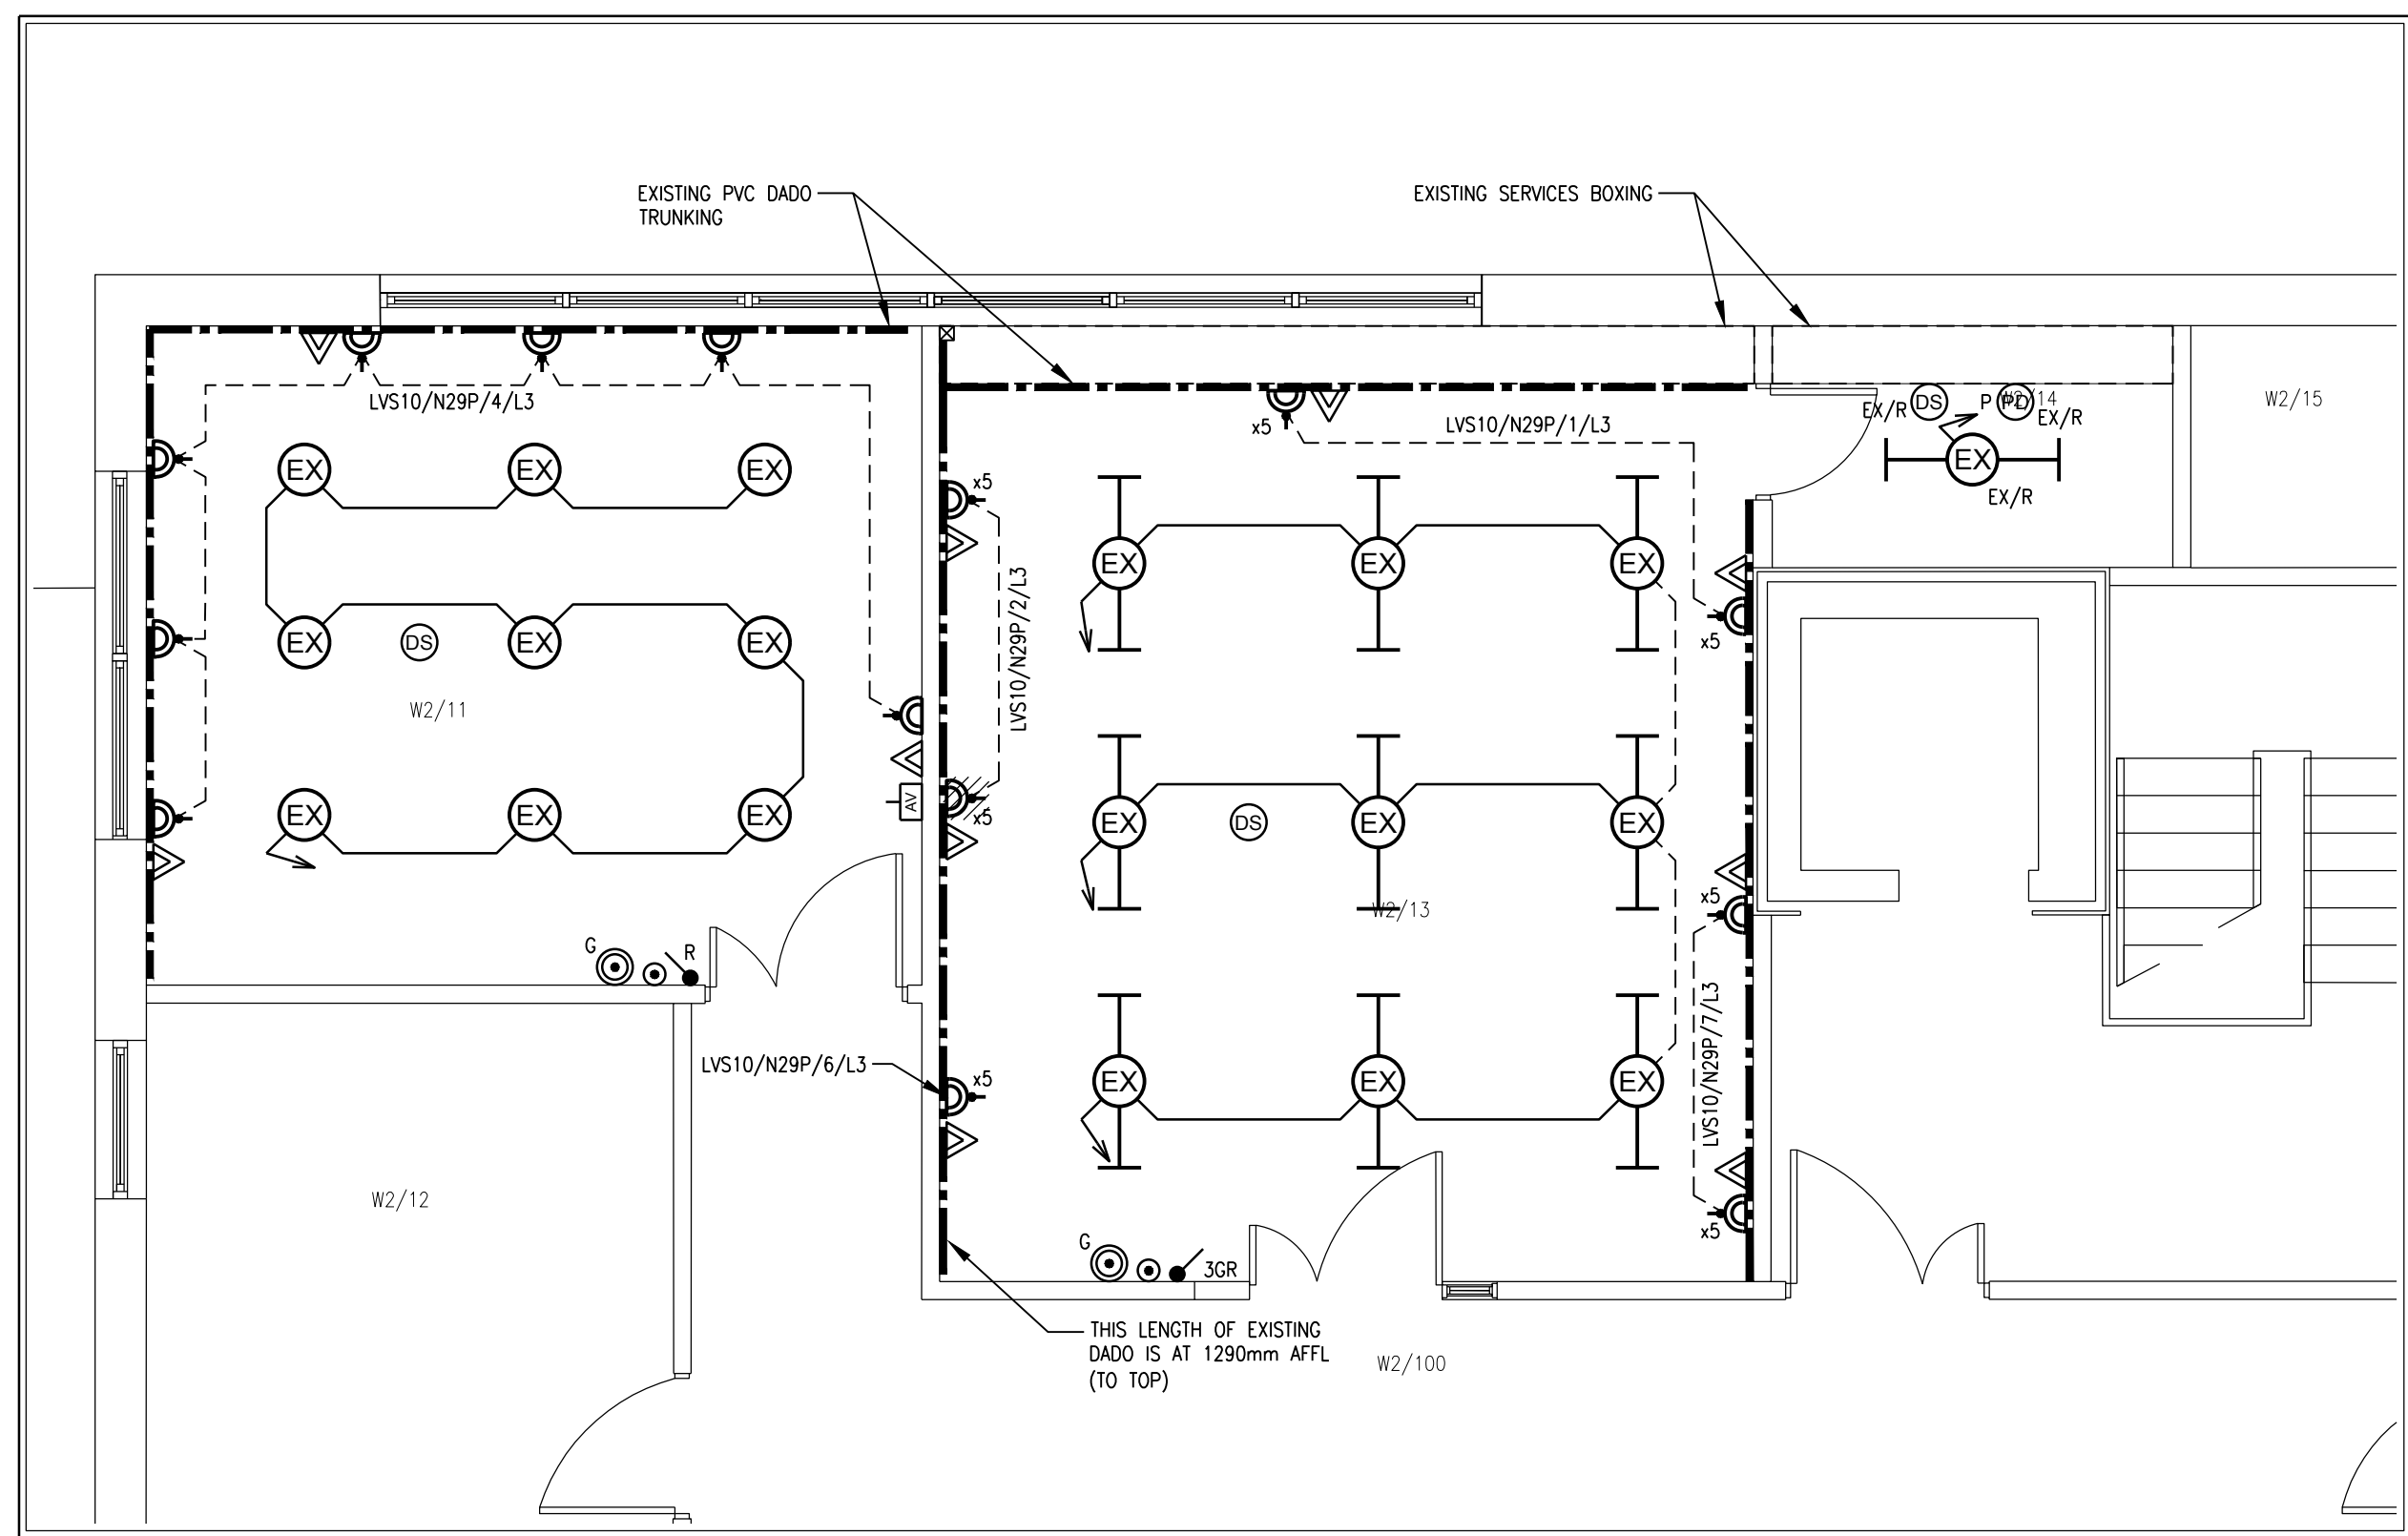
Copyright © 2018 tng Consulting Engineers Ltd.
This is not a working drawing. Refined dimensions shall be checked on site.
This drawing shall be read in conjunction with all relevant consultants and/or specialist's drawings/documents.
Any discrepancies or variations shall be notified to the engineer prior to commencement of works.

STANDARD NOTES

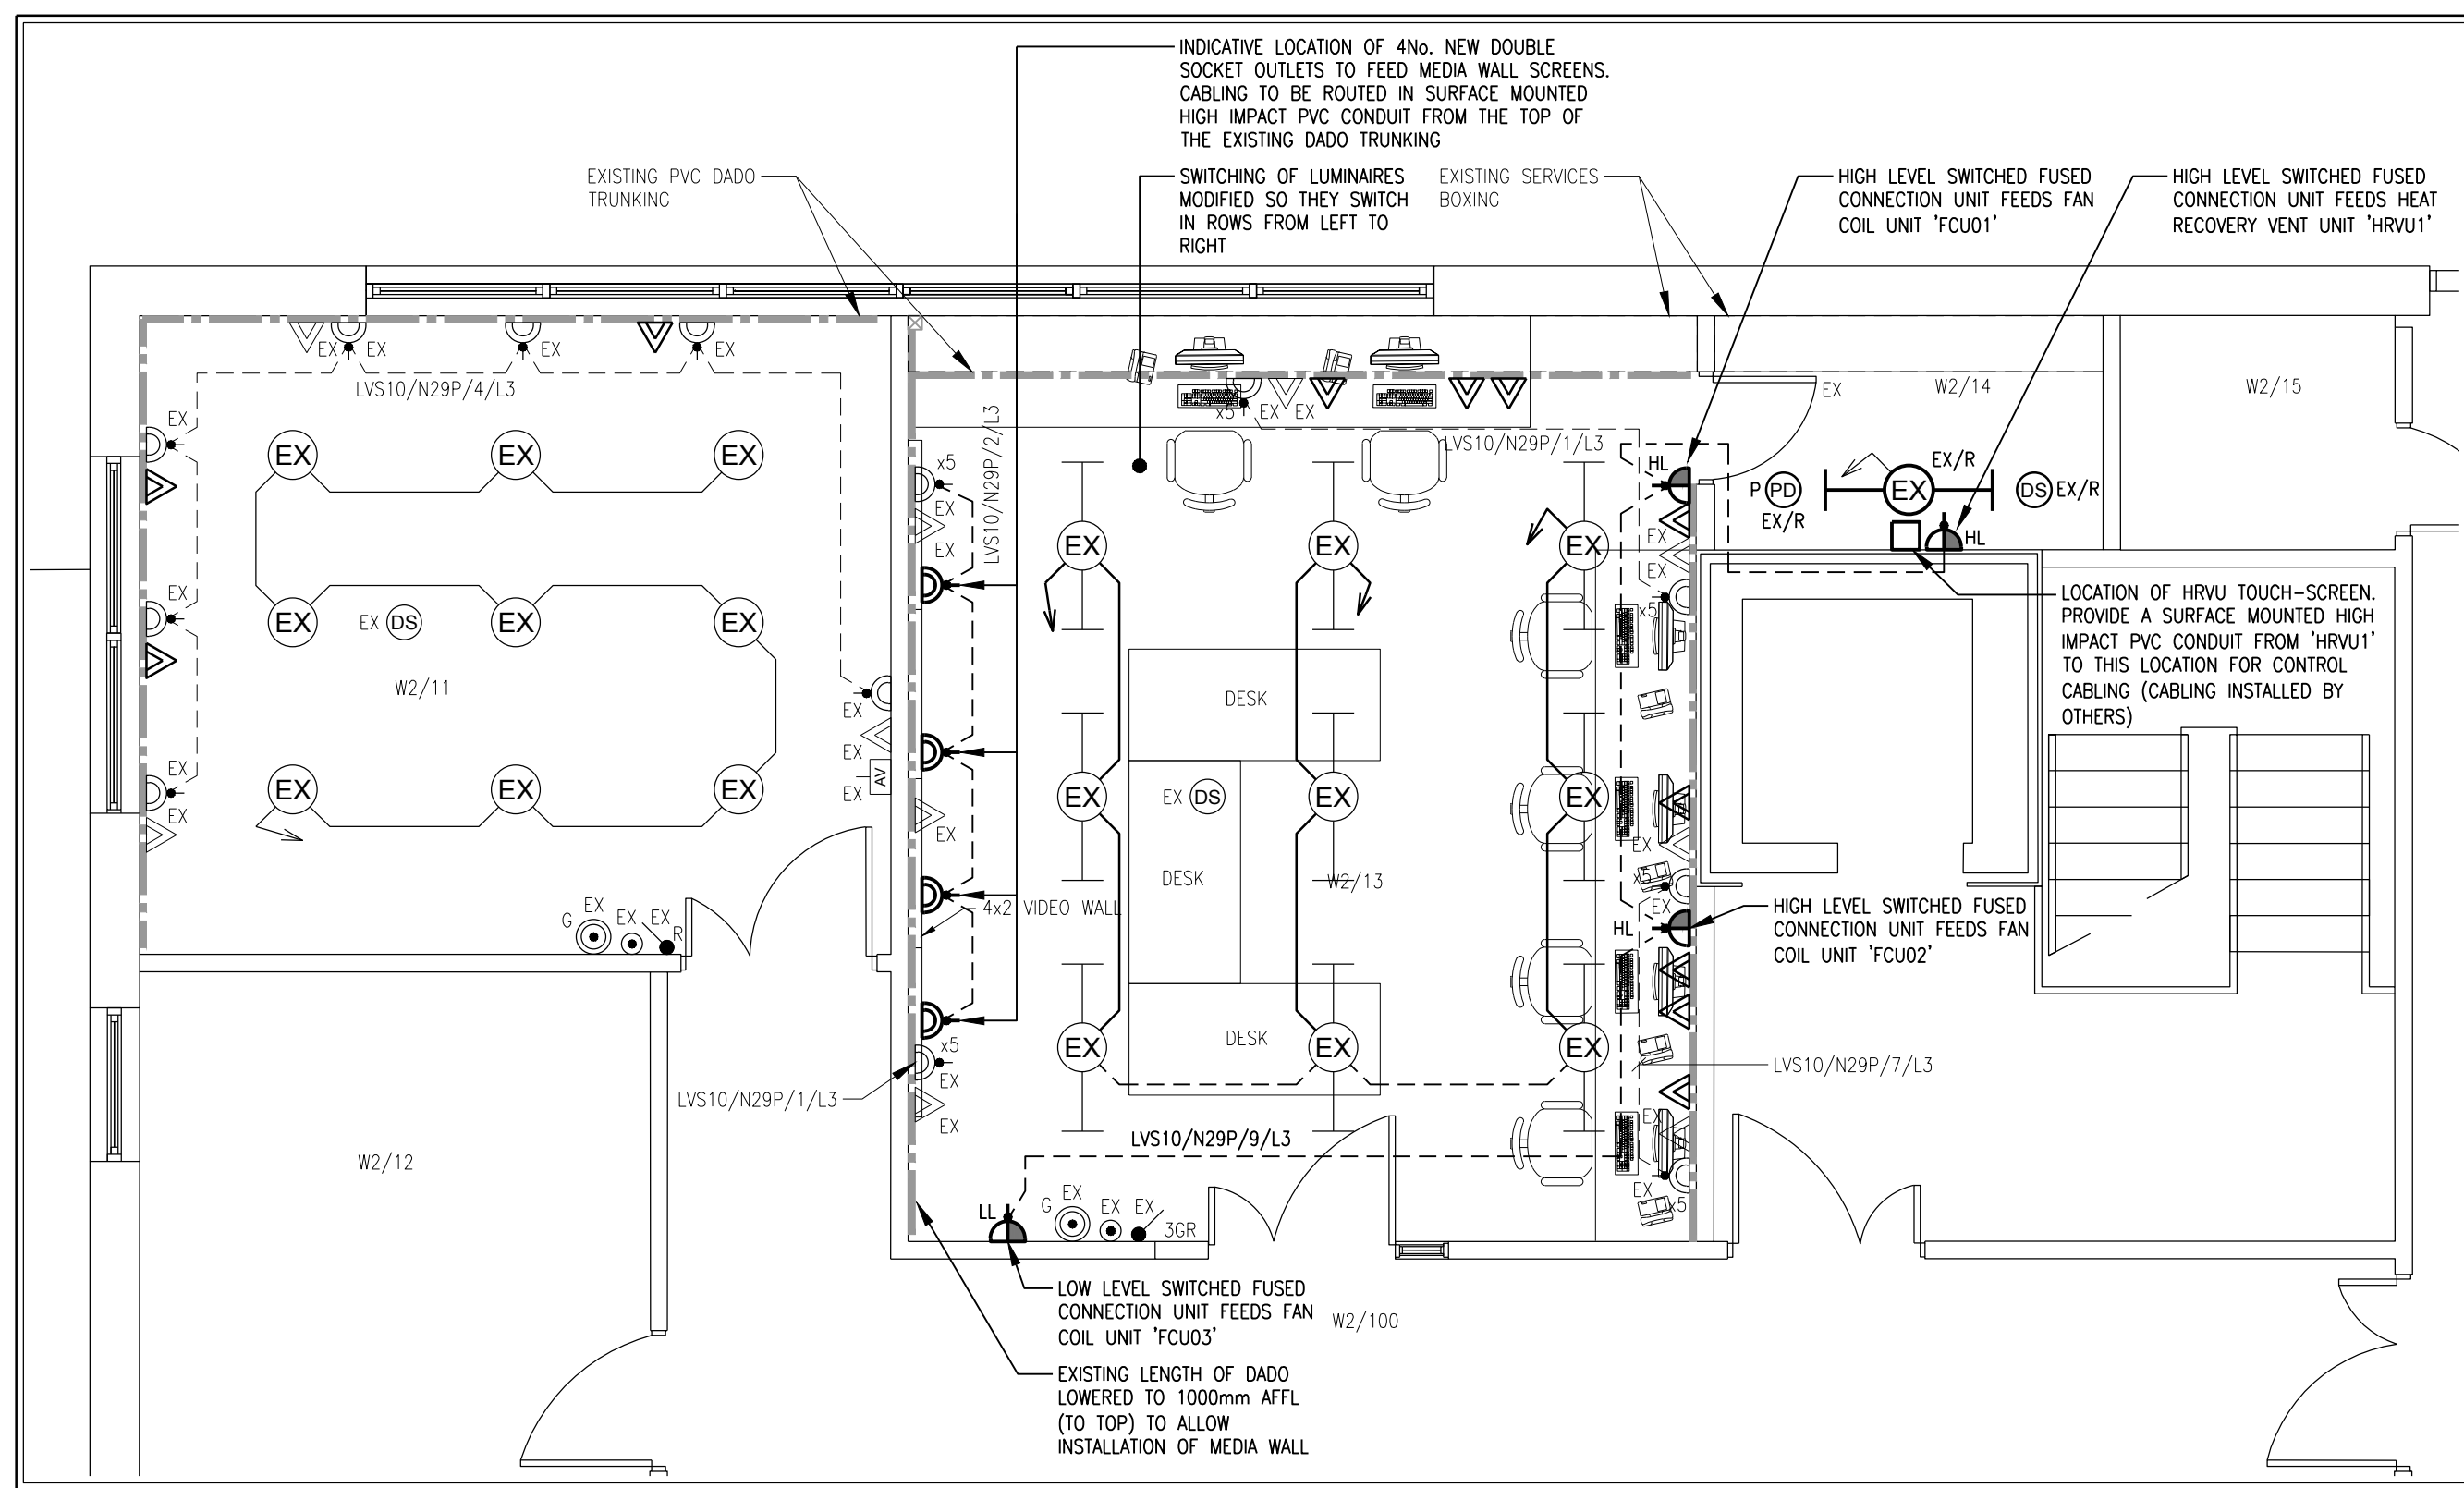
- FOR ELECTRICAL LEGEND, SEE DRAWING NO. E1(00)101.
- THIS DRAWING SHALL BE USED IN CONJUNCTION WITH THE LATEST ARCHITECTURAL DRAWINGS & ALL ASSOCIATED ROOM DETAIL DRAWINGS.
- THE ELECTRICAL CONTRACTOR SHALL CO-ORDINATE THEIR SERVICES LAYOUT IN CONJUNCTION WITH ALL OTHER TRADES. NO WORK SHALL COMMENCE UNTIL THE ELECTRICAL CONTRACTOR HAS VERIFIED THAT HIS SERVICES WILL NOT FOUL THOSE OF OTHER SERVICES & TRADES.

**PROPOSED ELECTRICAL ROUTES**

(SCALE 1:200)

**EXISTING ELECTRICAL SERVICES LAYOUT**

(SCALE 1:50)

**PROPOSED ELECTRICAL SERVICES LAYOUT**

(SCALE 1:50)

RESIDUAL RISKS

1. THERE ARE NO FORESEEN SIGNIFICANT RISKS.

**T1 TENDER ISSUE**

Rev. Description

BOS MD FEB'18

CAD ENG

Date



t: +44 (0)23 8022 5900 e: headoffice@tngce.co.uk
www.tngconsultingengineers.co.uk

Client



Project

MARSIC
SYNTHETIC ENVIRONMENT

Title

LEVEL 2
EXISTING & PROPOSED ELECTRICAL
SERVICES LAYOUT

Originators CAD/ENG

BOS/MD

Job No.

J2171109

Original Date

FEB'18

Drawing No.

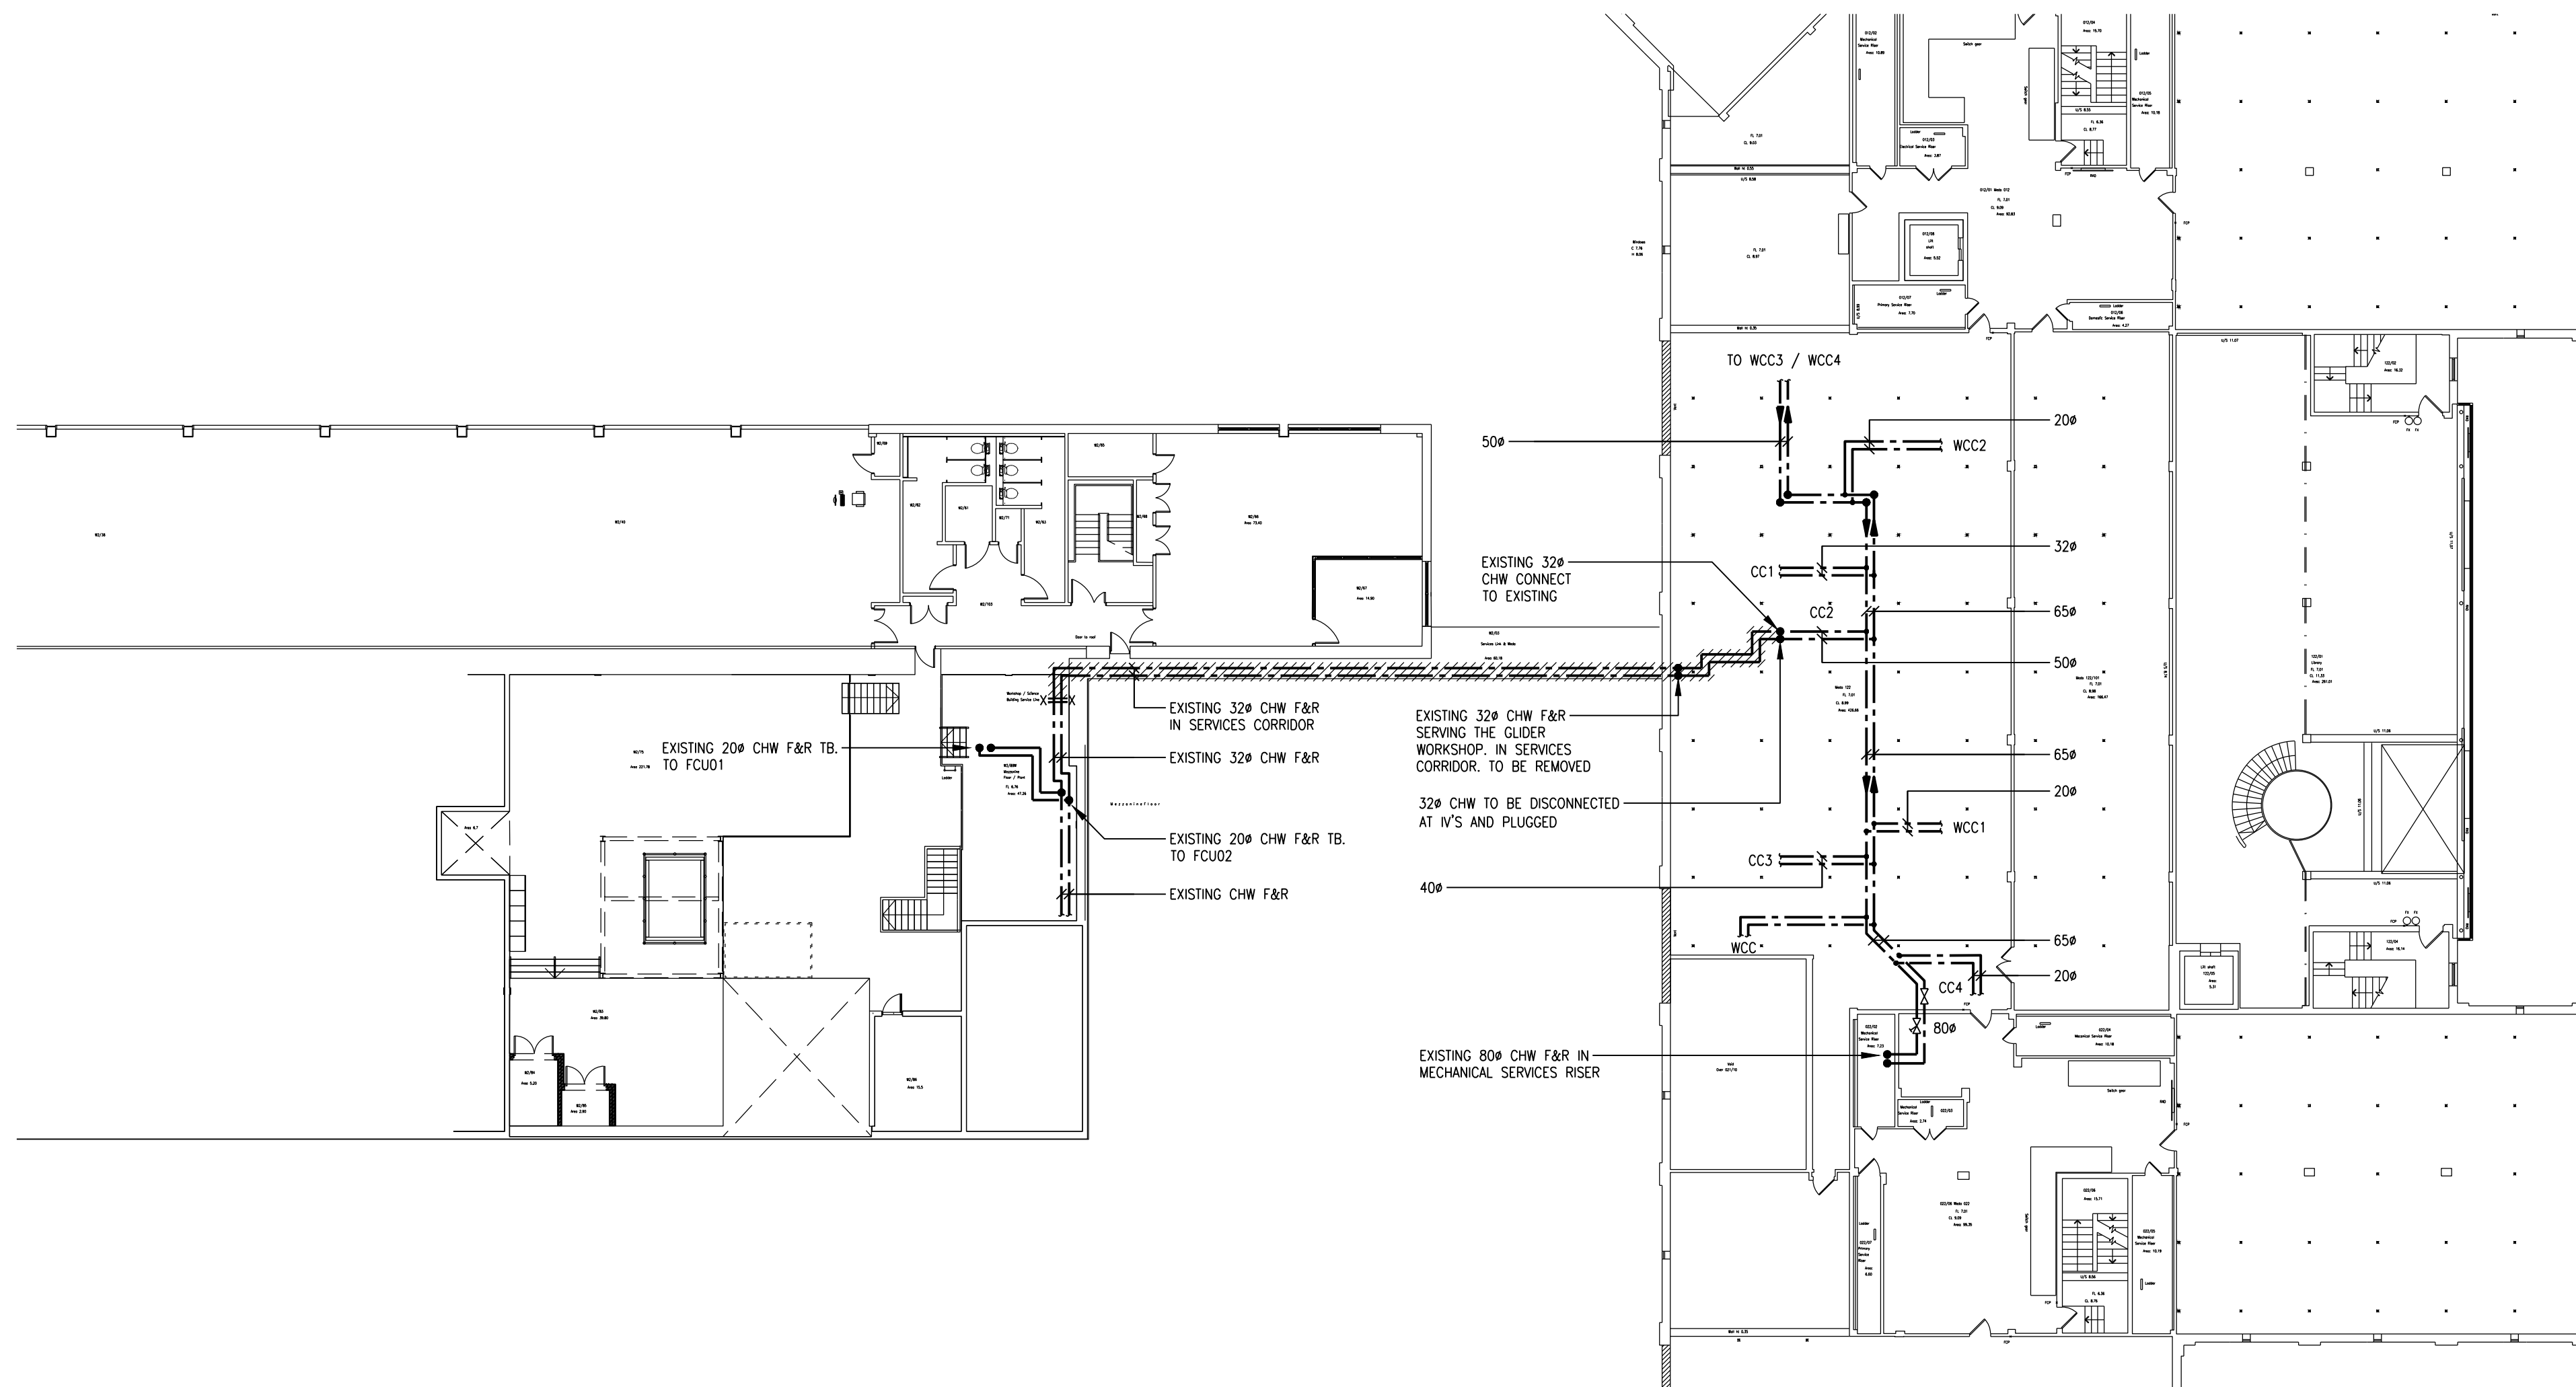
E9(02)901

Scale @ A1

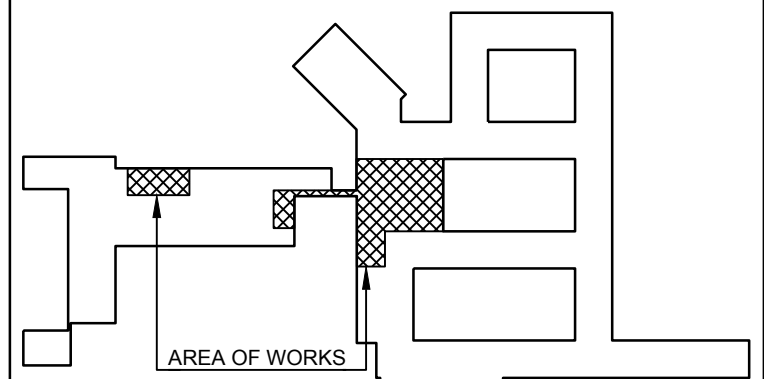
AS SHOWN

Revision

T1

**Do Not Scale**

Copyright © 2018 TNG Consulting Engineers Ltd.
This is not a working drawing. Rigged dimensions shall be checked on site.
This drawing shall be read in conjunction with all relevant consultants and/or specialist's drawings/documents.
Any discrepancies or variations shall be notified to the engineer prior to commencement of works.

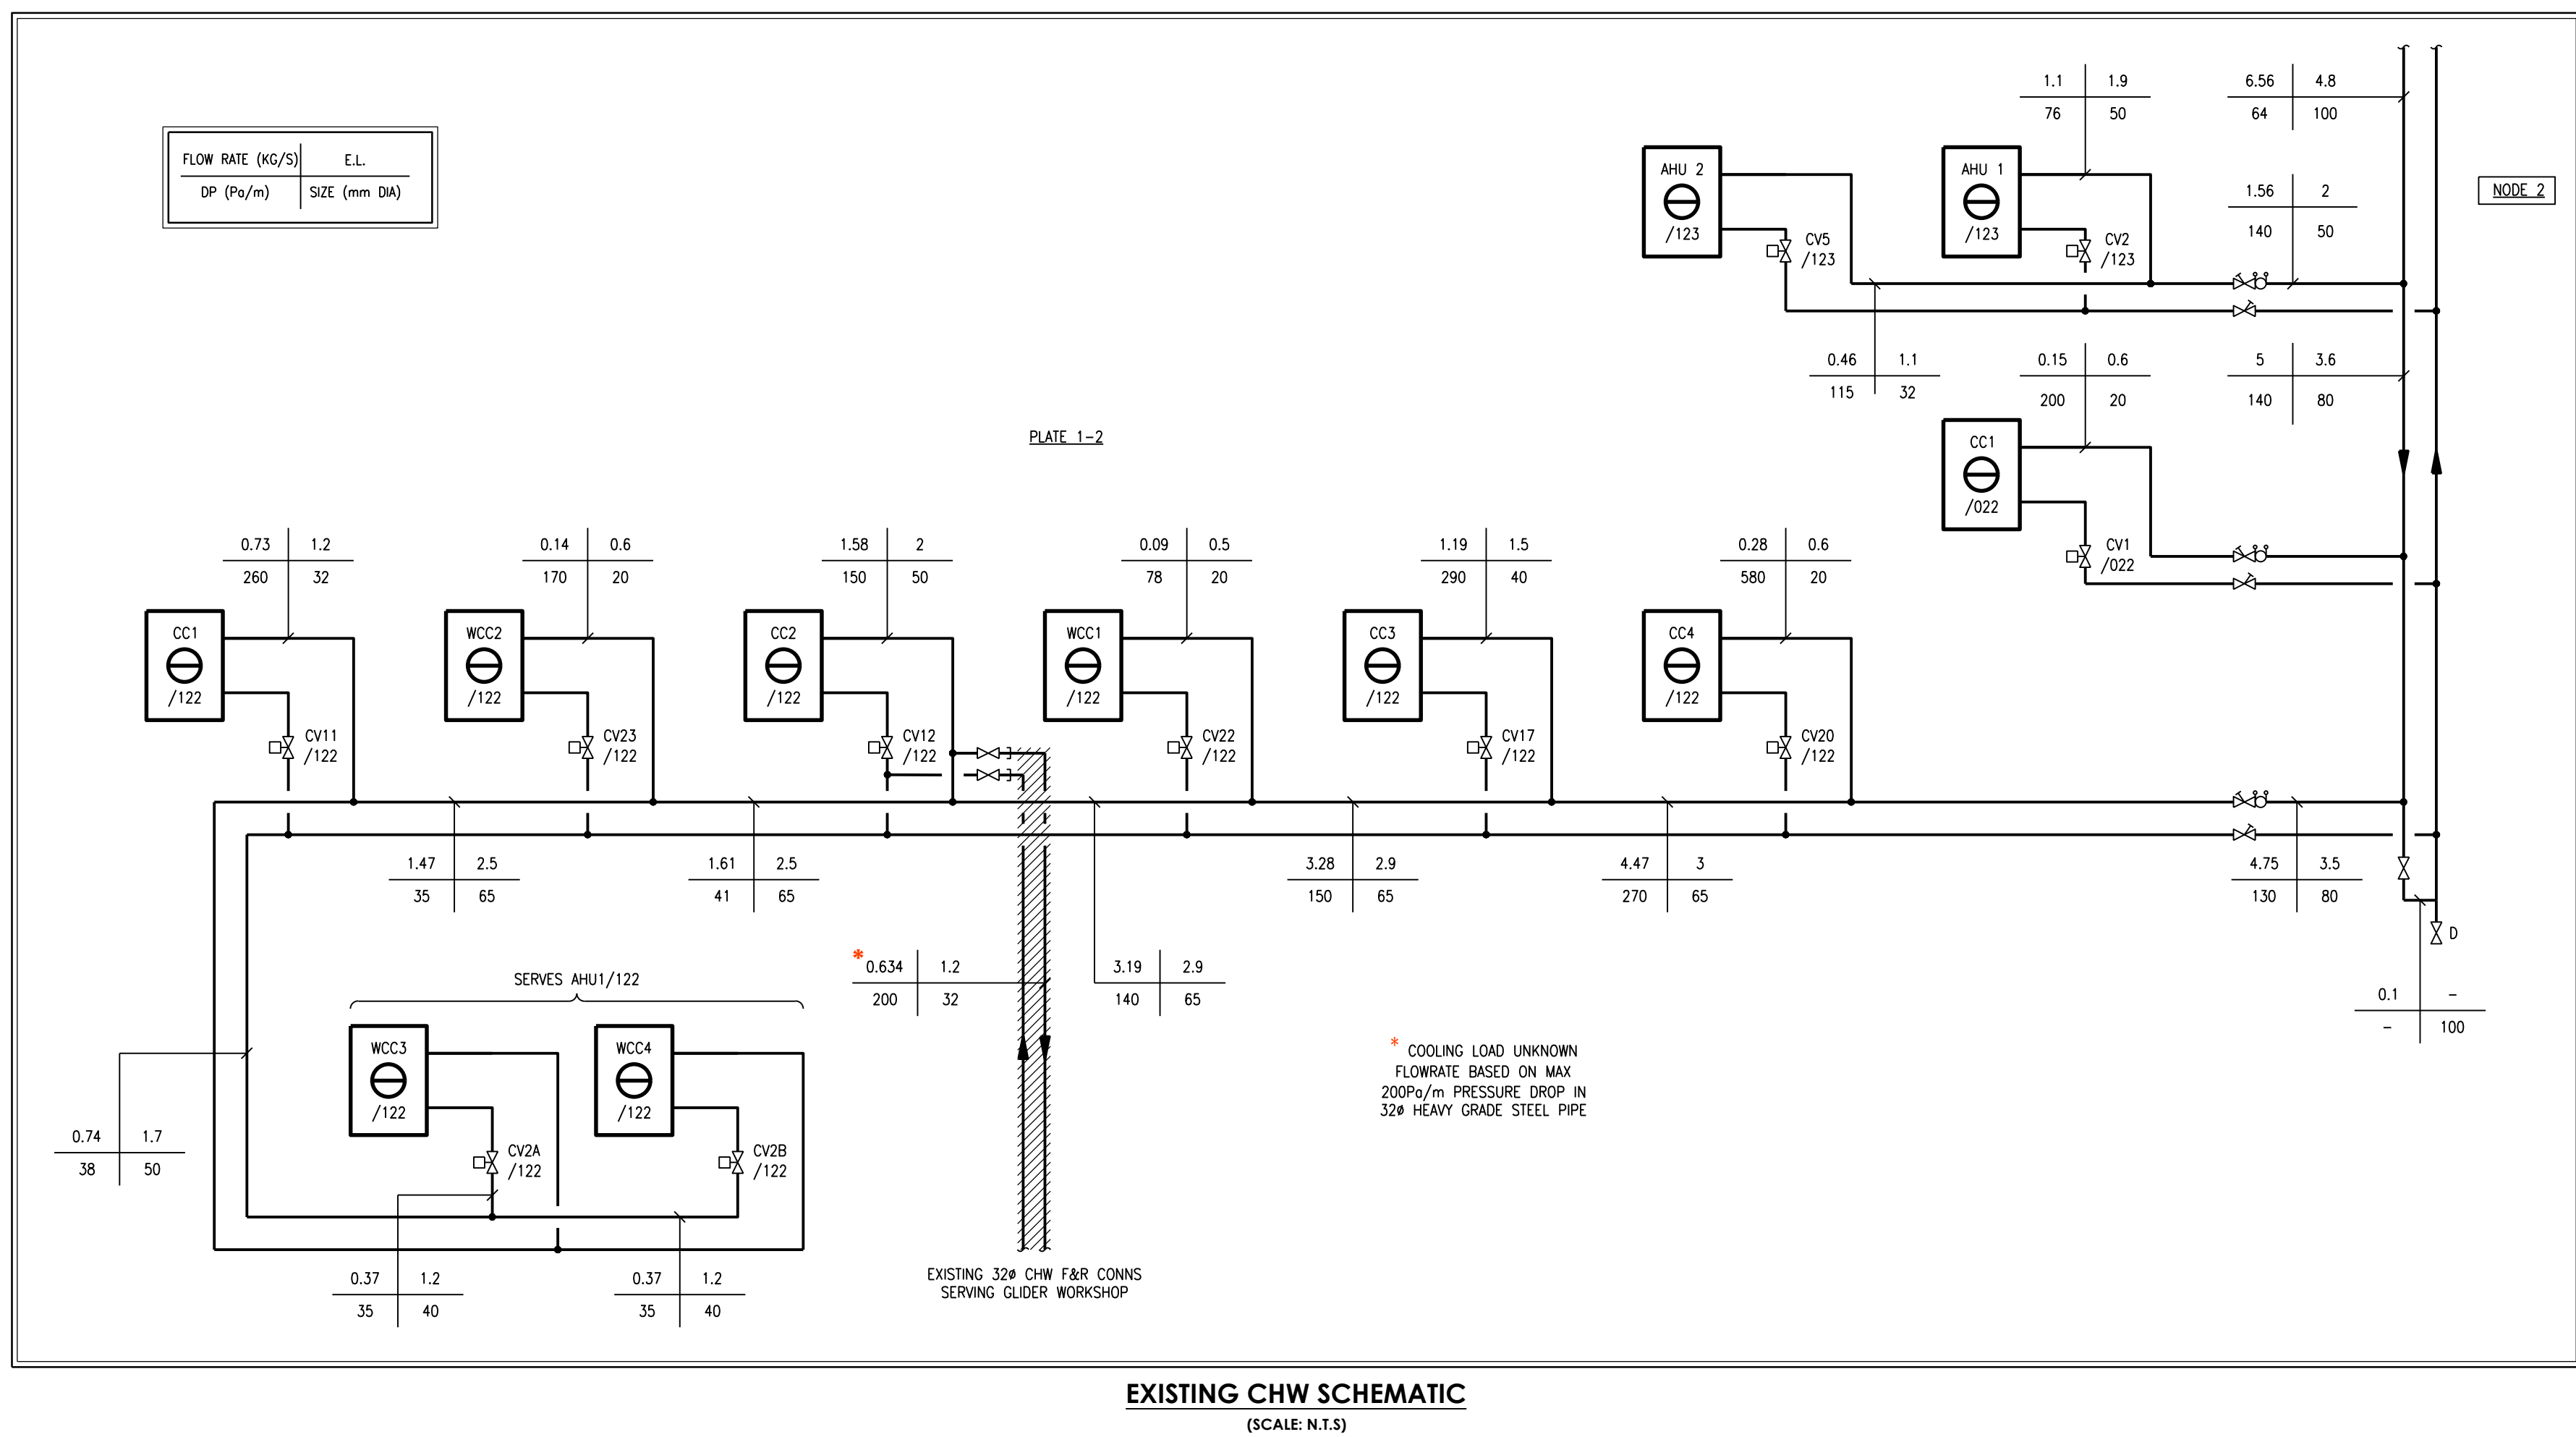
**NOCSS SCIENCE BUILDING NODE 1-2
LEVEL 2 LOCATION PLAN (N.T.S.)****STANDARD REMOVALS NOTES**

1. FOR MECHANICAL LEGEND, SEE PROJECT LEGEND DRAWING NO. M1(00)101.
2. ALL REMOVED ITEMS SHALL BE REMOVED FROM SITE DAILY. STORING OF WASTE WITHIN CONTRACT AREA SHALL NOT BE PERMITTED.
3. ACCESS TO AREAS OUTSIDE THE BOUNDARY OF WORKS SHALL ONLY BE OBTAINED FOLLOWING CLOSE LIAISON BY CONTRACTOR WITH ESTATES & THE USERS.
4. ALL REDUNDANT ITEMS INDICATED FOR REMOVAL SHALL BE REMOVED C/W ALL BRACKETS & HANGERS. TEMPORARY SUPPORTS SHALL BE PROVIDED WHERE NECESSARY.
5. ADDITIONAL SUPPORTS SHALL BE INSTALLED TO SUIT ANY PARTIALLY REMOVED SERVICES.

KEY

X — X POINT OF DISCONNECTION

//// SERVICES TO BE REMOVED

**T1 TENDER ISSUE**

Rev. Description SN/CPC FEB'18

CAD ENG Date



t: +44 (0)23 8022 5900 e: headoffice@tngce.co.uk
www.tngconsultingengineers.co.uk

Client



Project

**MARSIC
SYNTHETIC ENVIROMENT**

Title

**LEVEL 2
CHILLED WATER INSTALLATION
INDICATING REMOVALS**

**RESIDUAL
RISKS**

1. THERE ARE NO FORESEEN
SIGNIFICANT RISKS.

Originators CAD/ENG

SN/CPC

Original Date

FEB'18

Scale @ A1

1:200

Job No.

J2171109

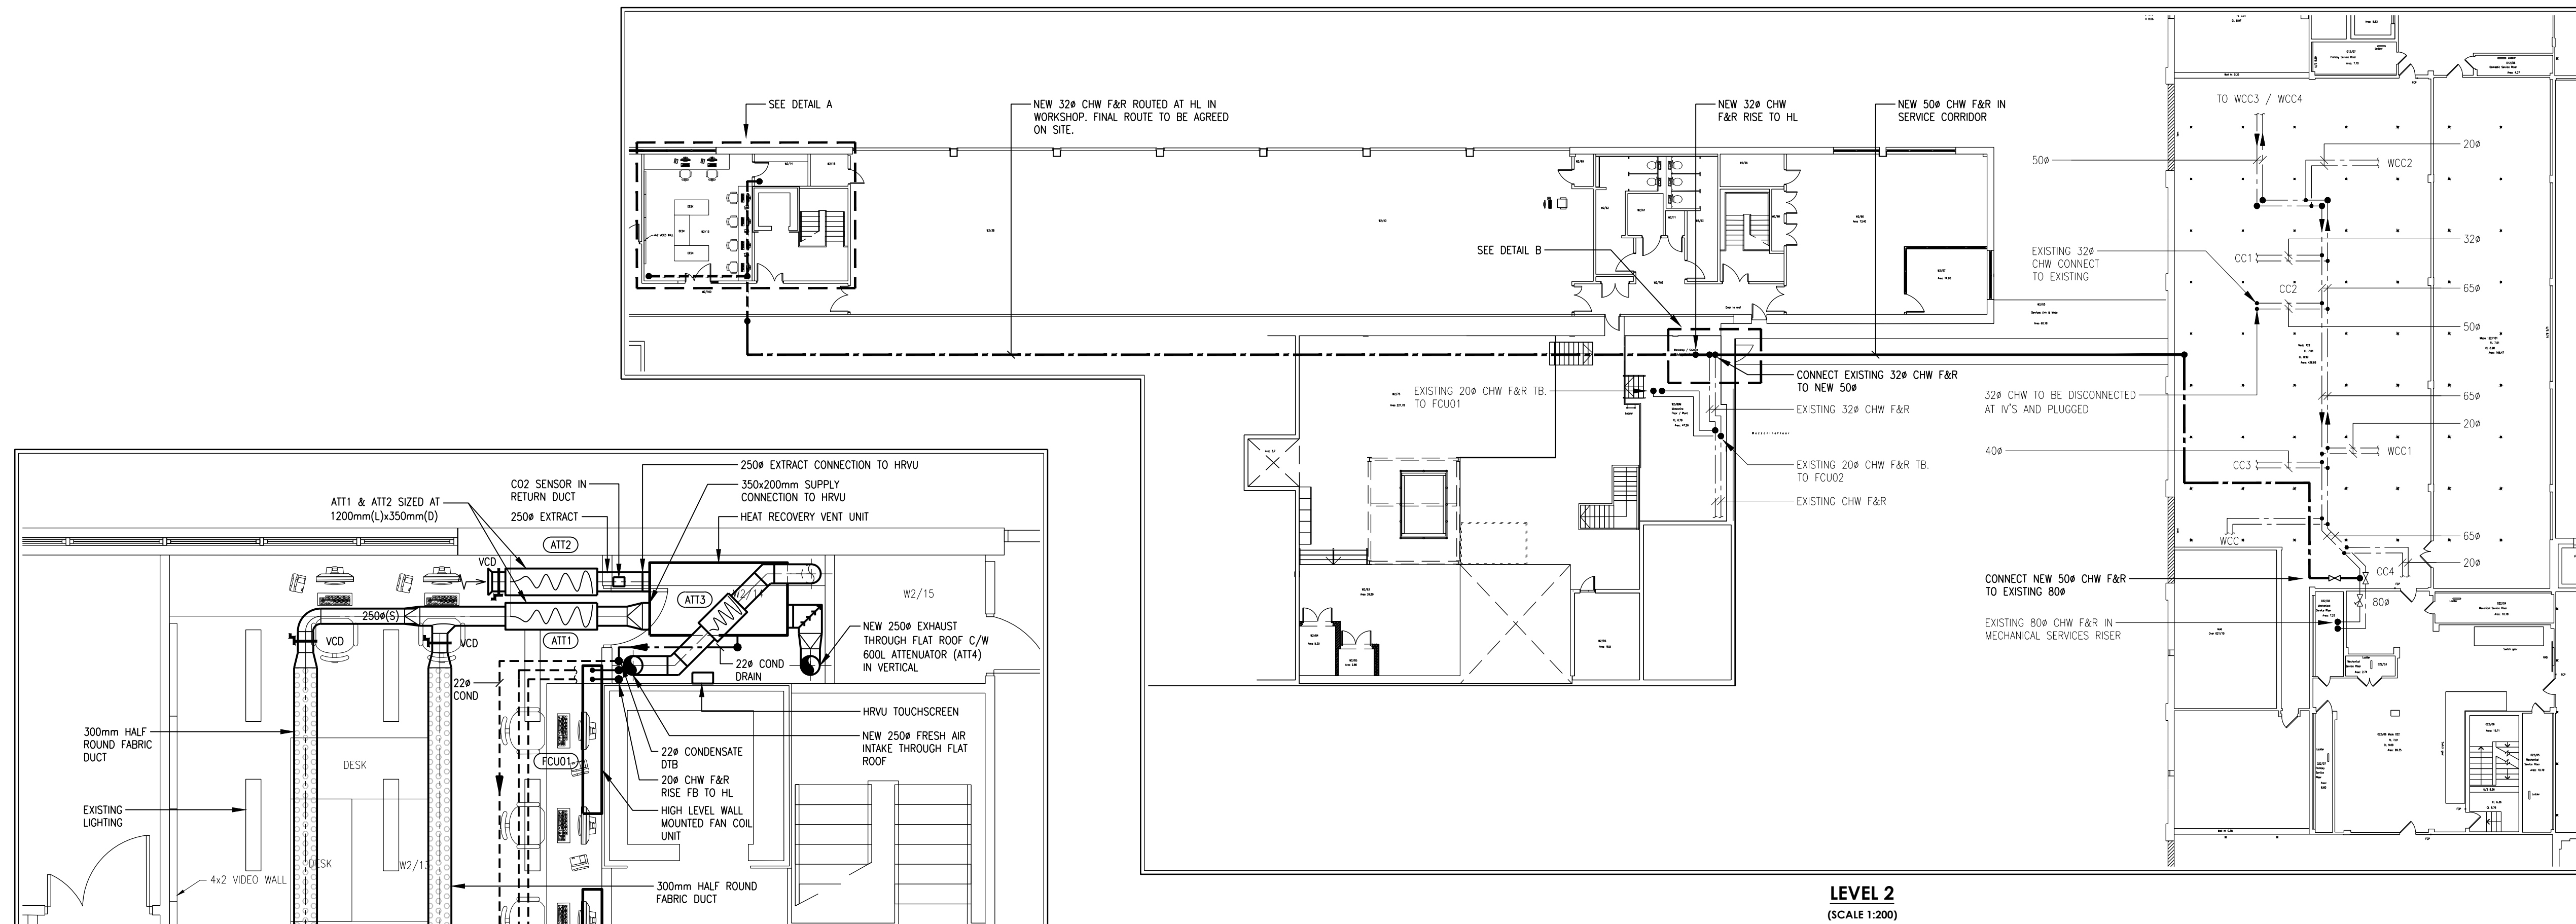
Drawing No.

M3(L2)301

Revision

T1

0 10 20 30 40 50 60 70 80 90 100mm
Natural Scale



LEVEL 2
(SCALE 1:200)