



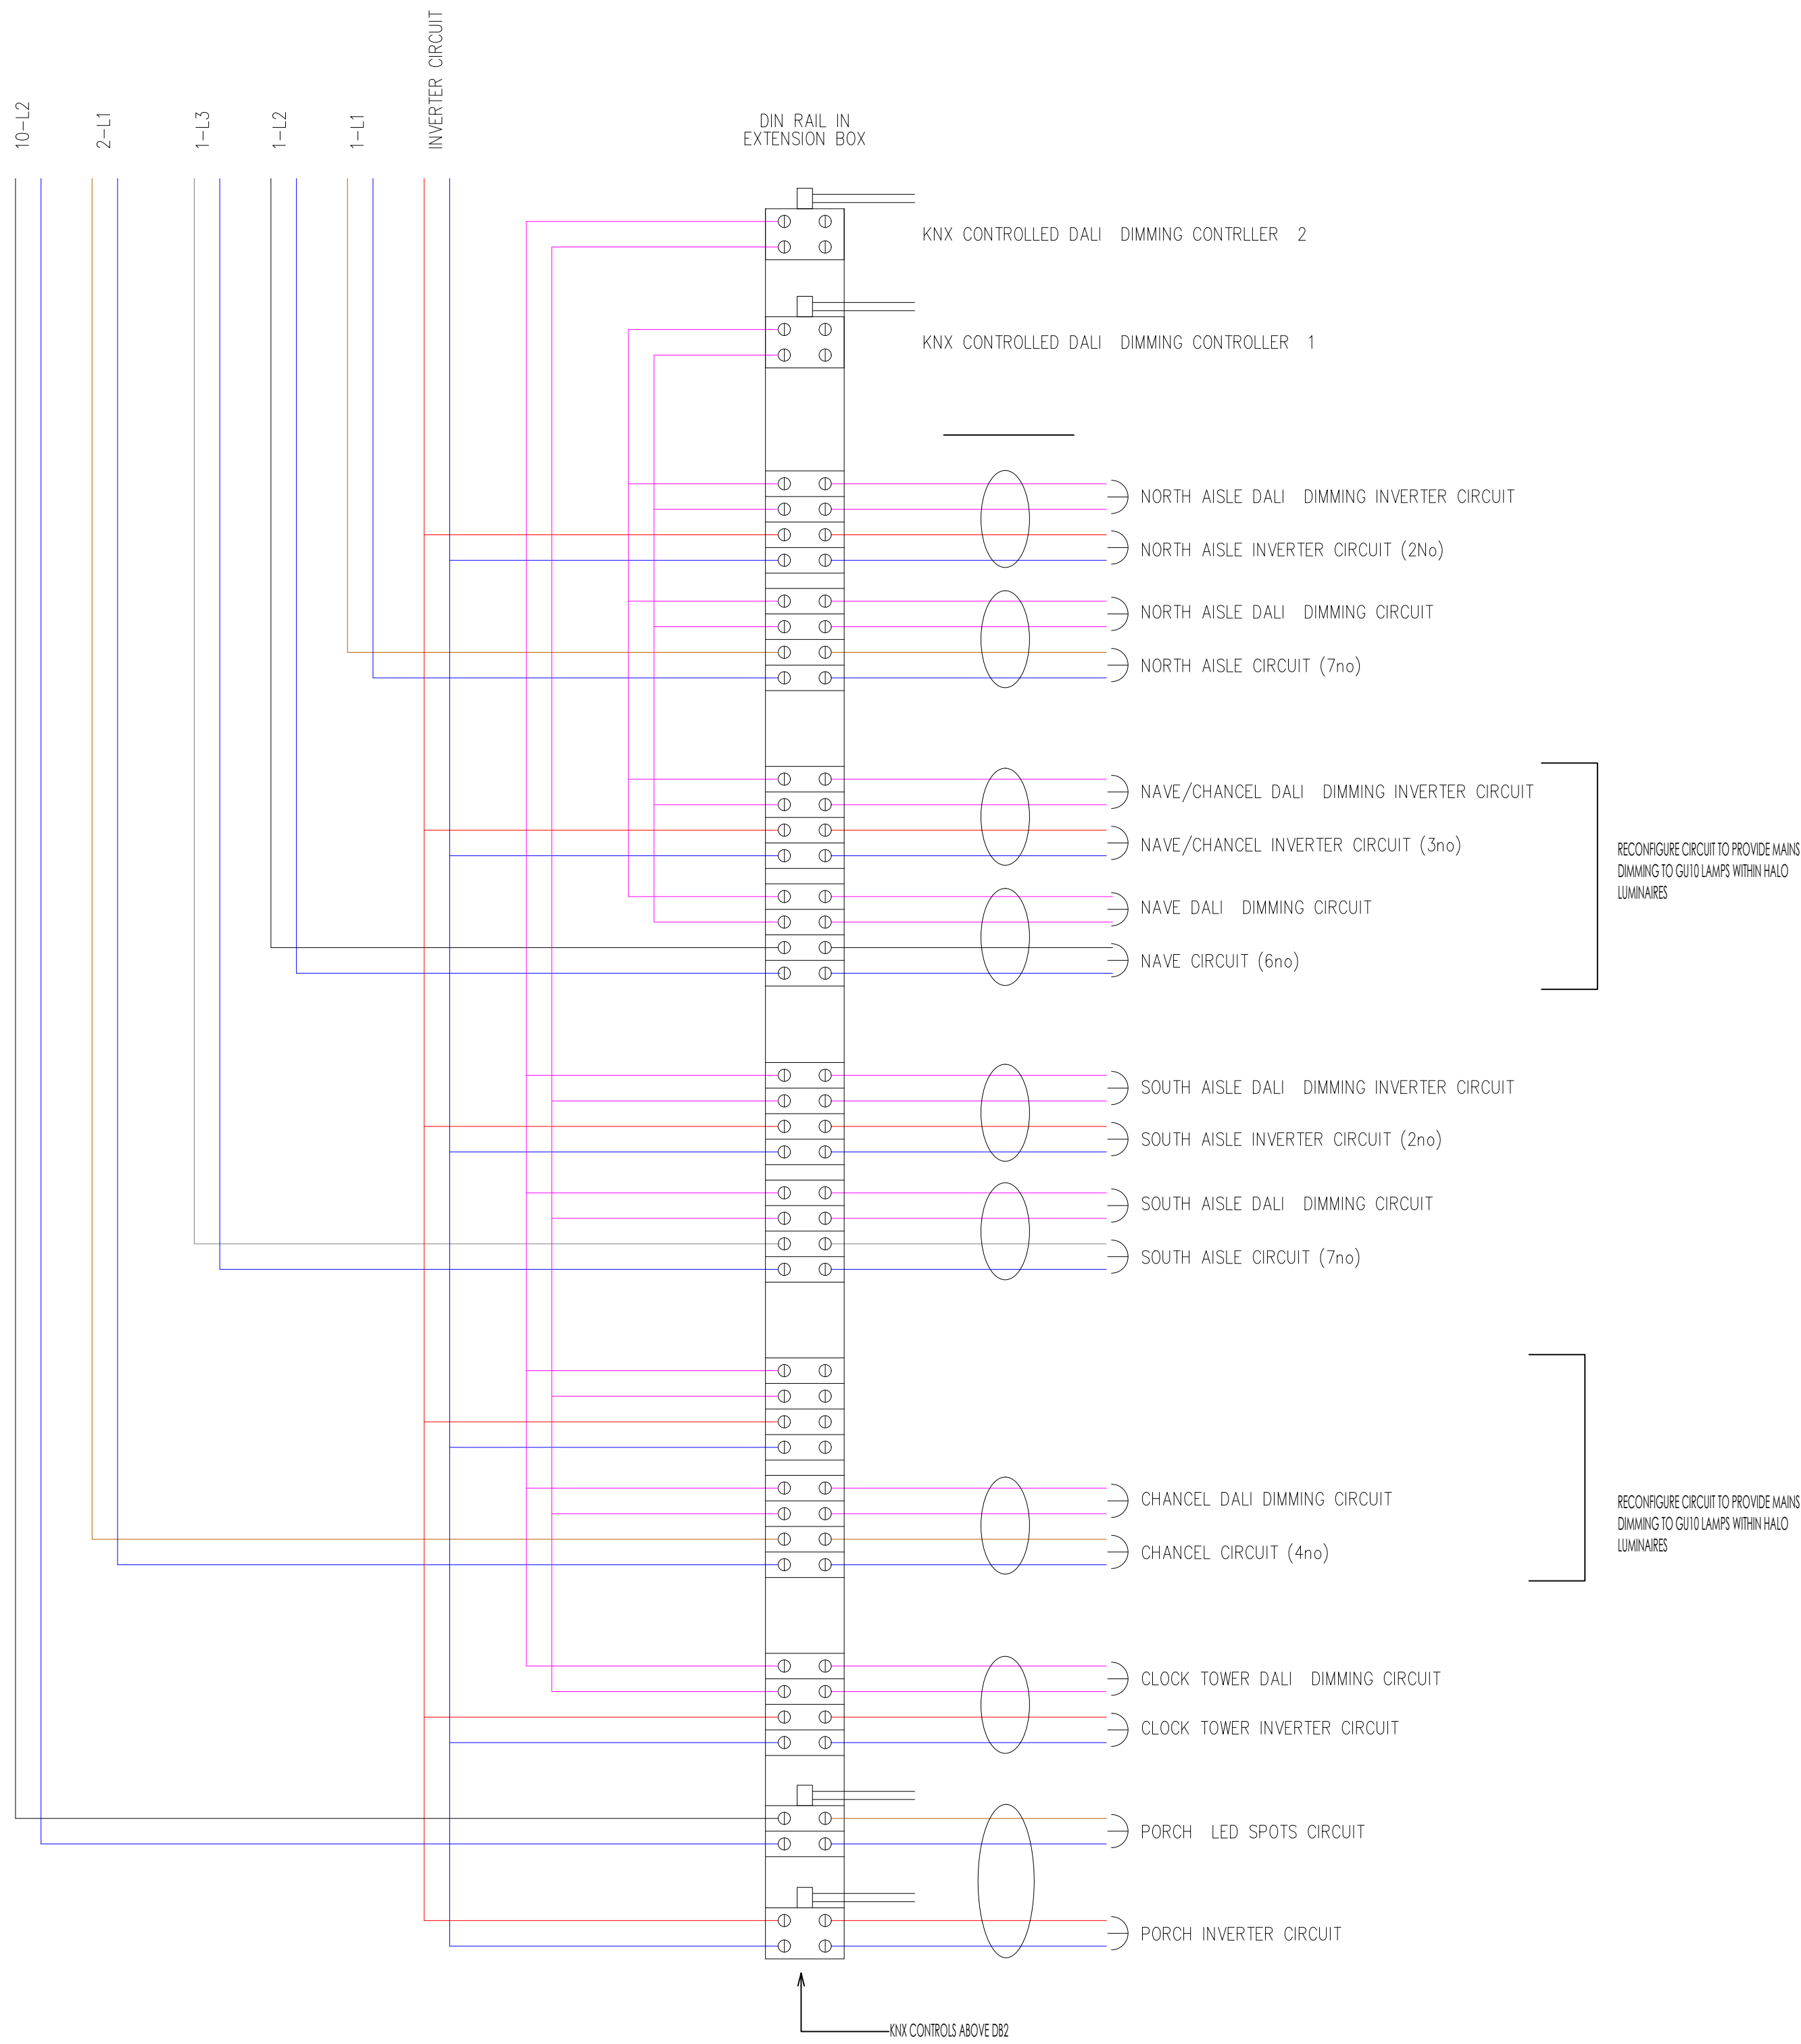

EXISTING

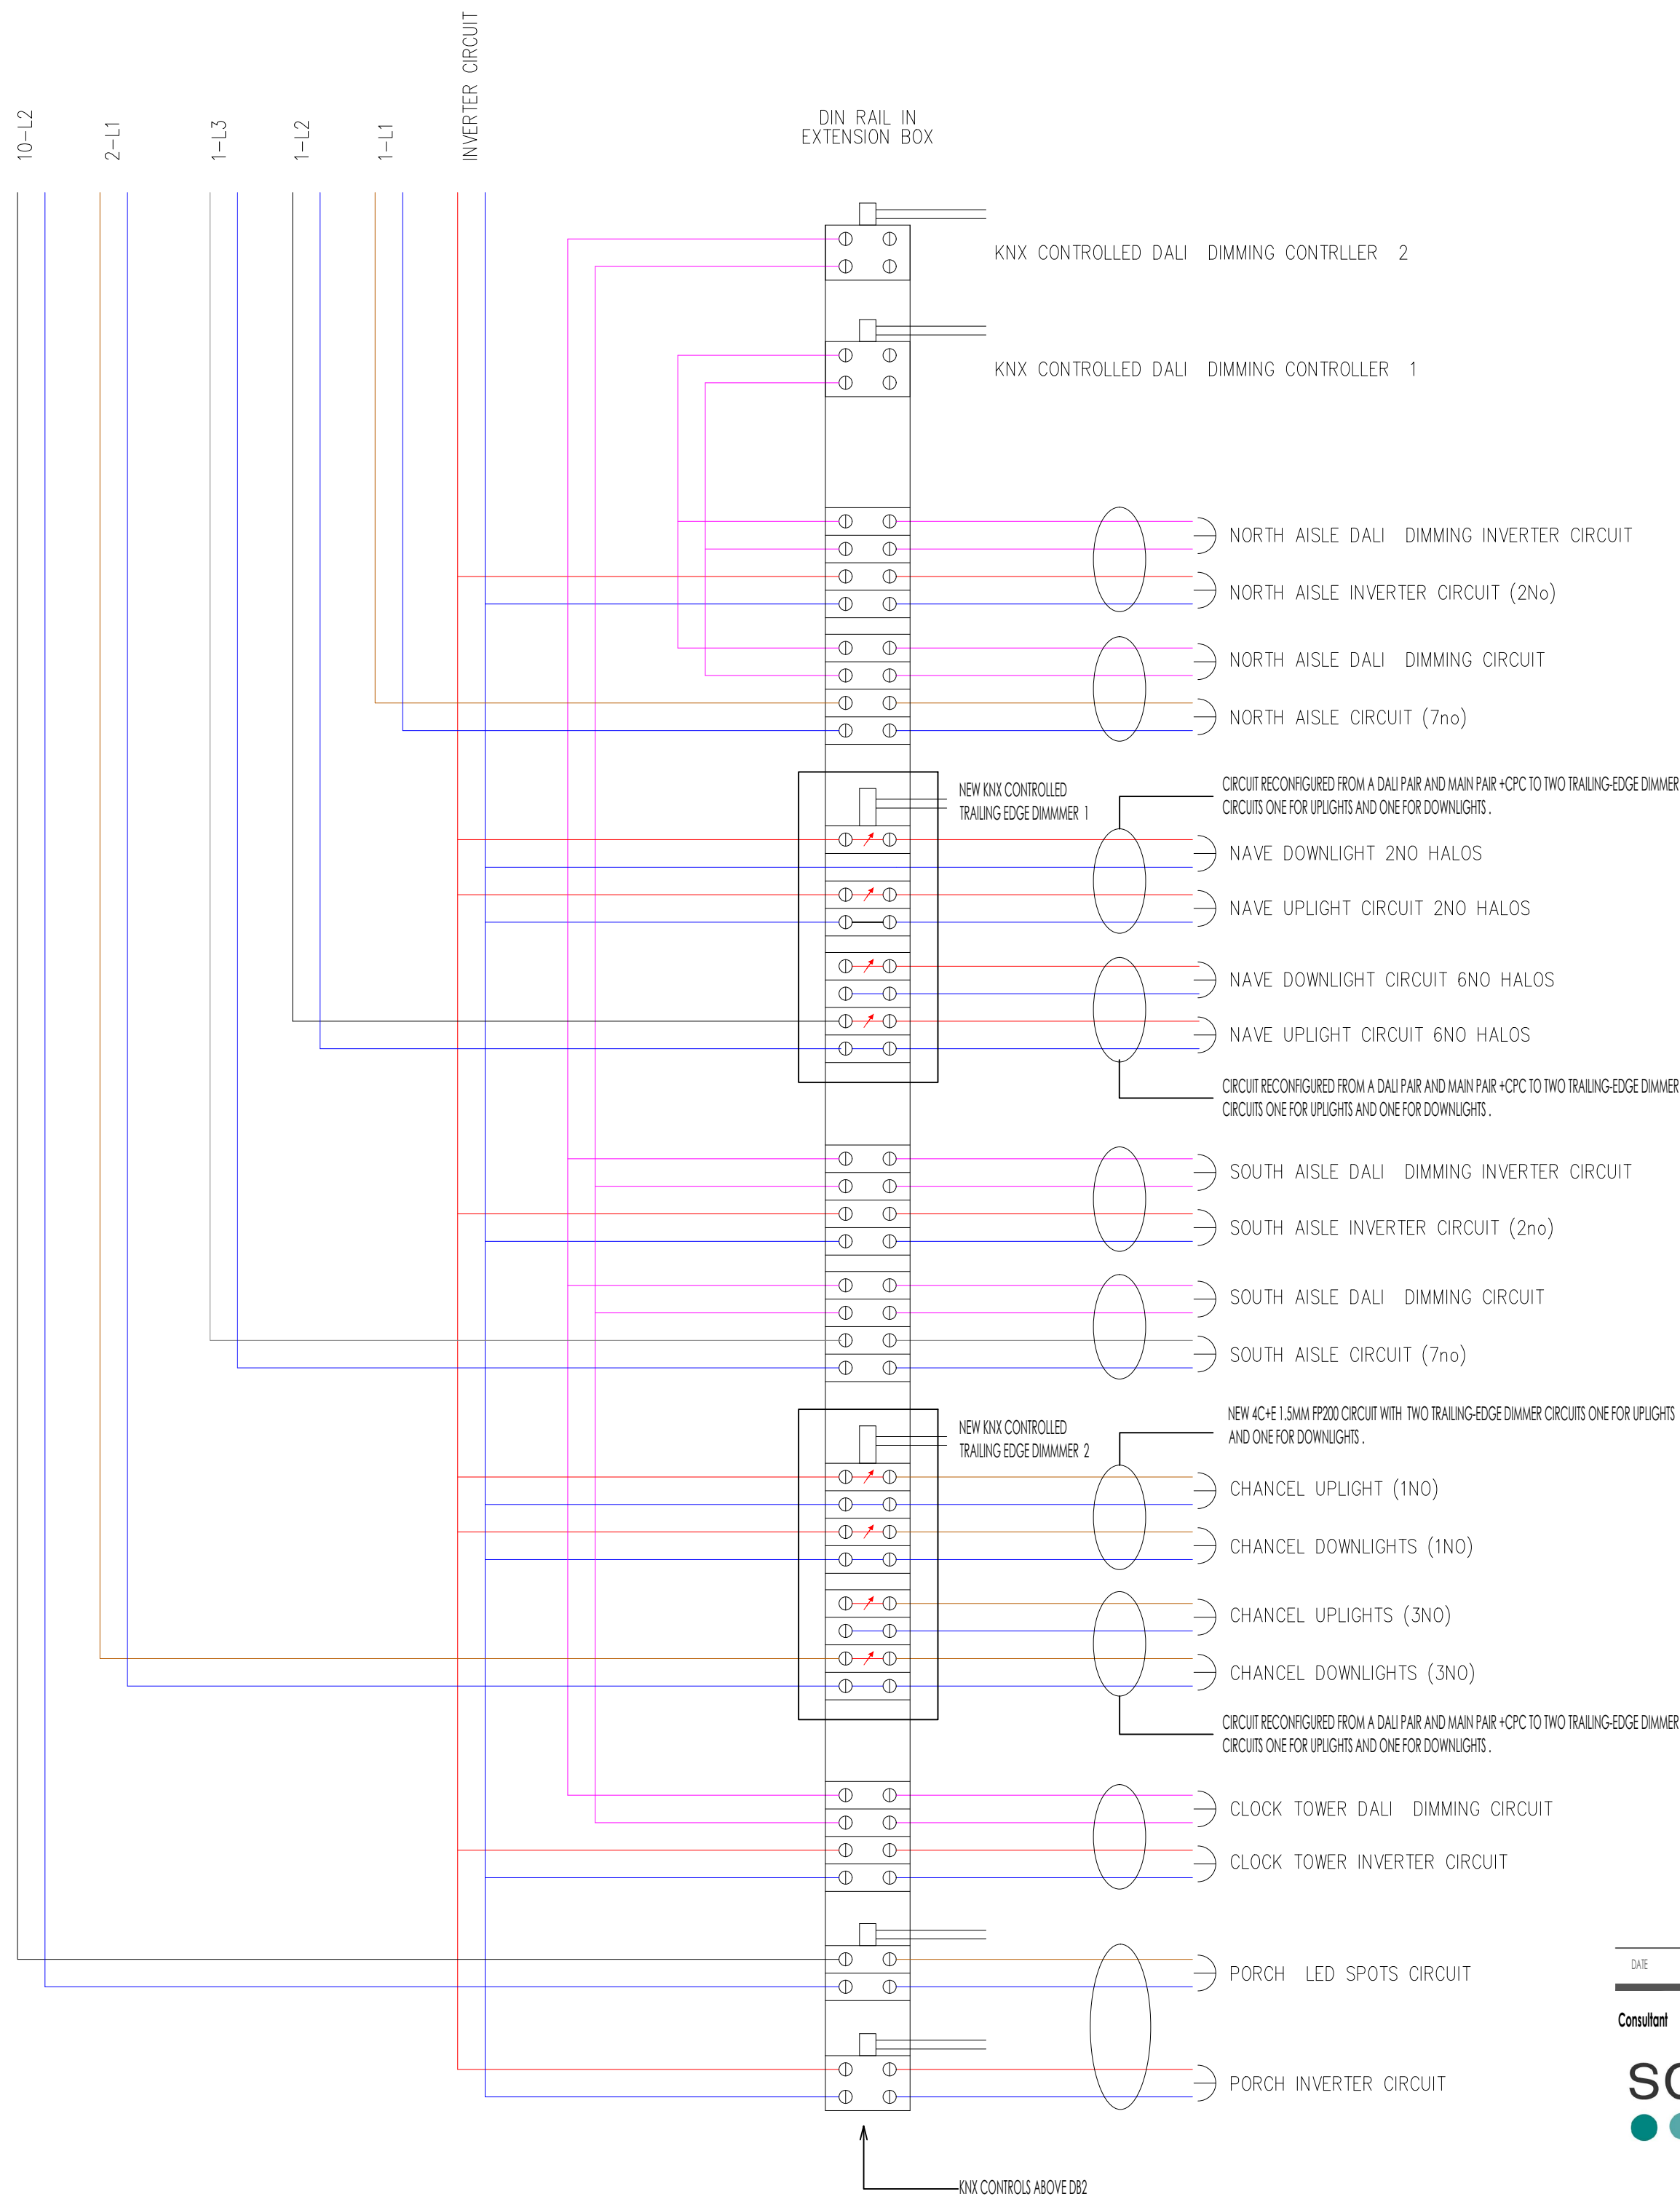

PROPOSED

DATE	REV	DESCRIPTION
------	-----	-------------

Consultant

screen & forster services design consultancy

Screen & Forster Services Design Consultancy Ltd
20 Portland Terrace, Jesmond
Newcastle upon Tyne, NE2 1GQ
T+44 (0) 191 281 4809

Client

Tyne & Wear Building Preservation Trust
John Marley Lodge John Marley Centre, Muscott Grove, Benwell,
Newcastle upon Tyne, NE15 6TT


Project

St Mary's Heritage Centre
Oakwellgate, Gateshead NE8 2AU
Infra-Red Heating and Lighting Replacement

Title

Existing and proposed KNX(DALI) control schematic with
proposed modifications for new IR Halo lamps

Drawing No.	Revision	Developed by
1438 (63) 01	00	MSC
Scale @ A1	Date	
NTS	NOV 2024	

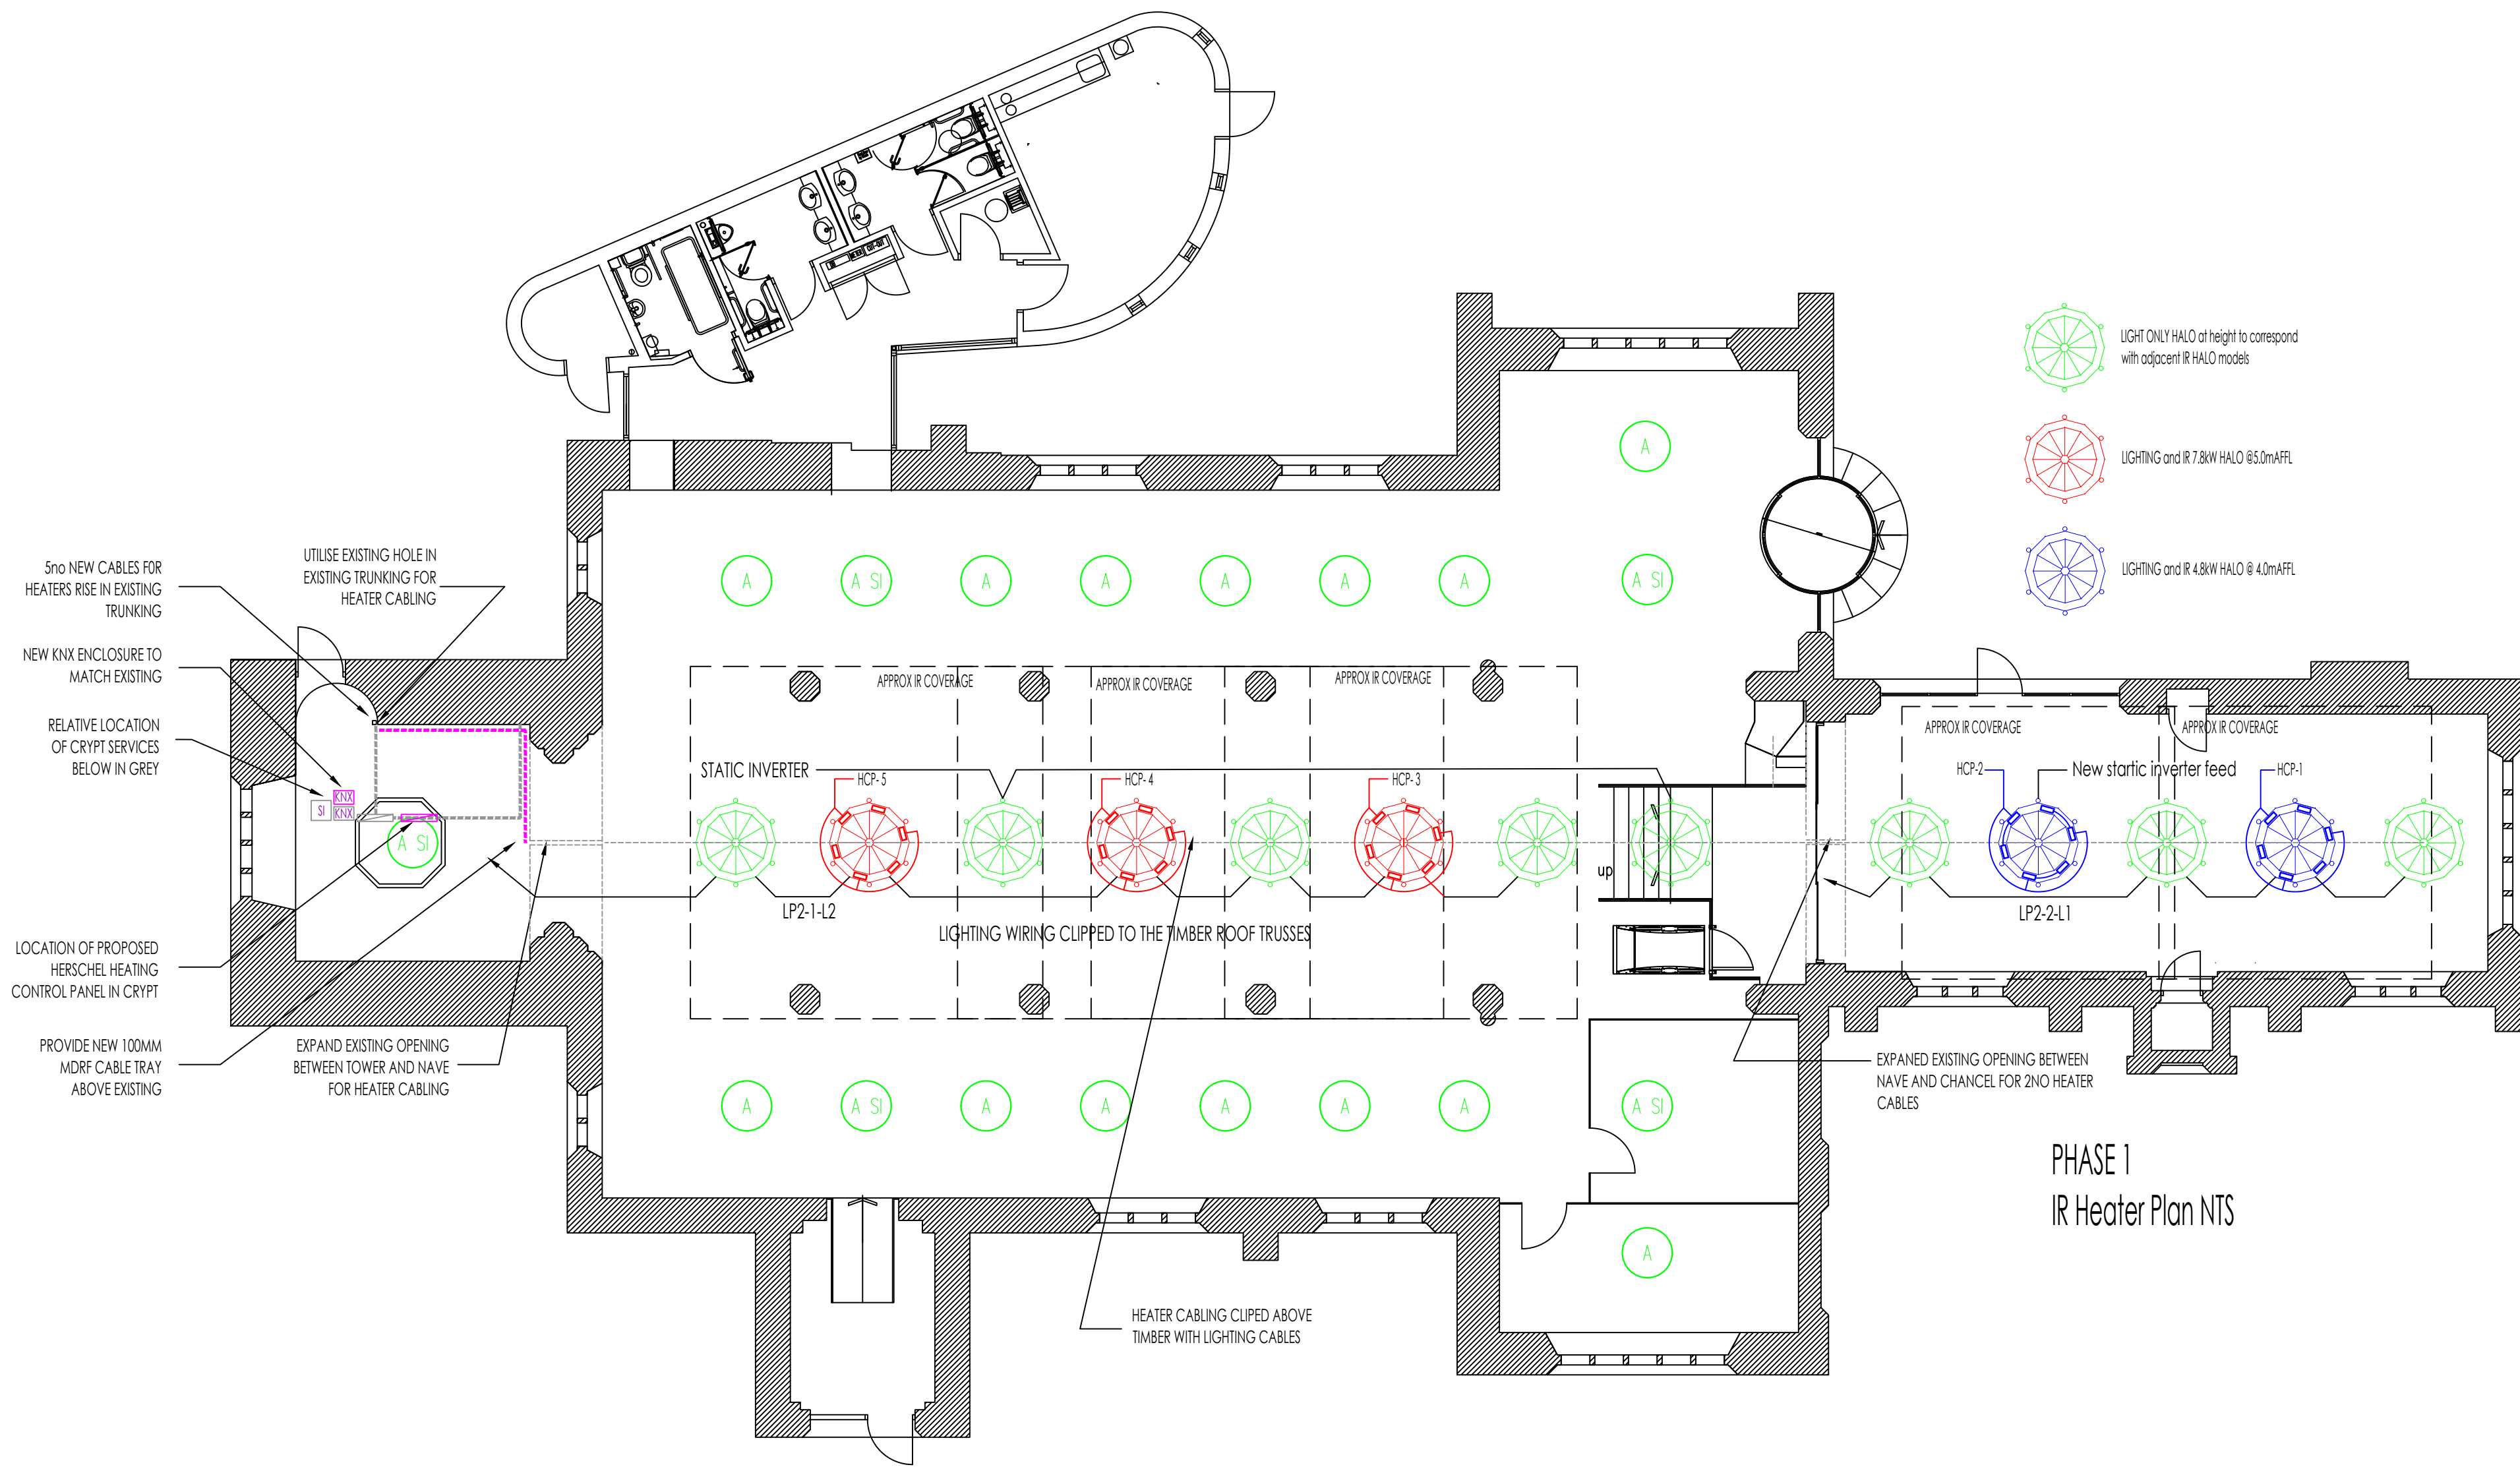

DATE	REV	DESCRIPTION

Consultant

screen & forster
services design consultancy

Screen & Forster Services Design Consultancy Ltd
20 Portland Terrace, Jesmond
Newcastle upon Tyne, NE2 1QG
T+44 (0) 191 281 4807


Client Tyne & Wear Building Preservation Trust
John Marley Lodge John Marley Centre, Muscott Grove, Benwell,
Newcastle upon Tyne, NE15 6TT

Project St Mary's Heritage Centre
Oakwellgate, Gateshead NE8 2AU
Infra-Red Heating and Lighting Replacement

Title Proposed Phase 1 - IR Heating and Lighting Replacement

Drawing No. 1458 (63) 02
Revision 00
Developed by MSC

Scale @ A1 1:100
Date NOV 2024

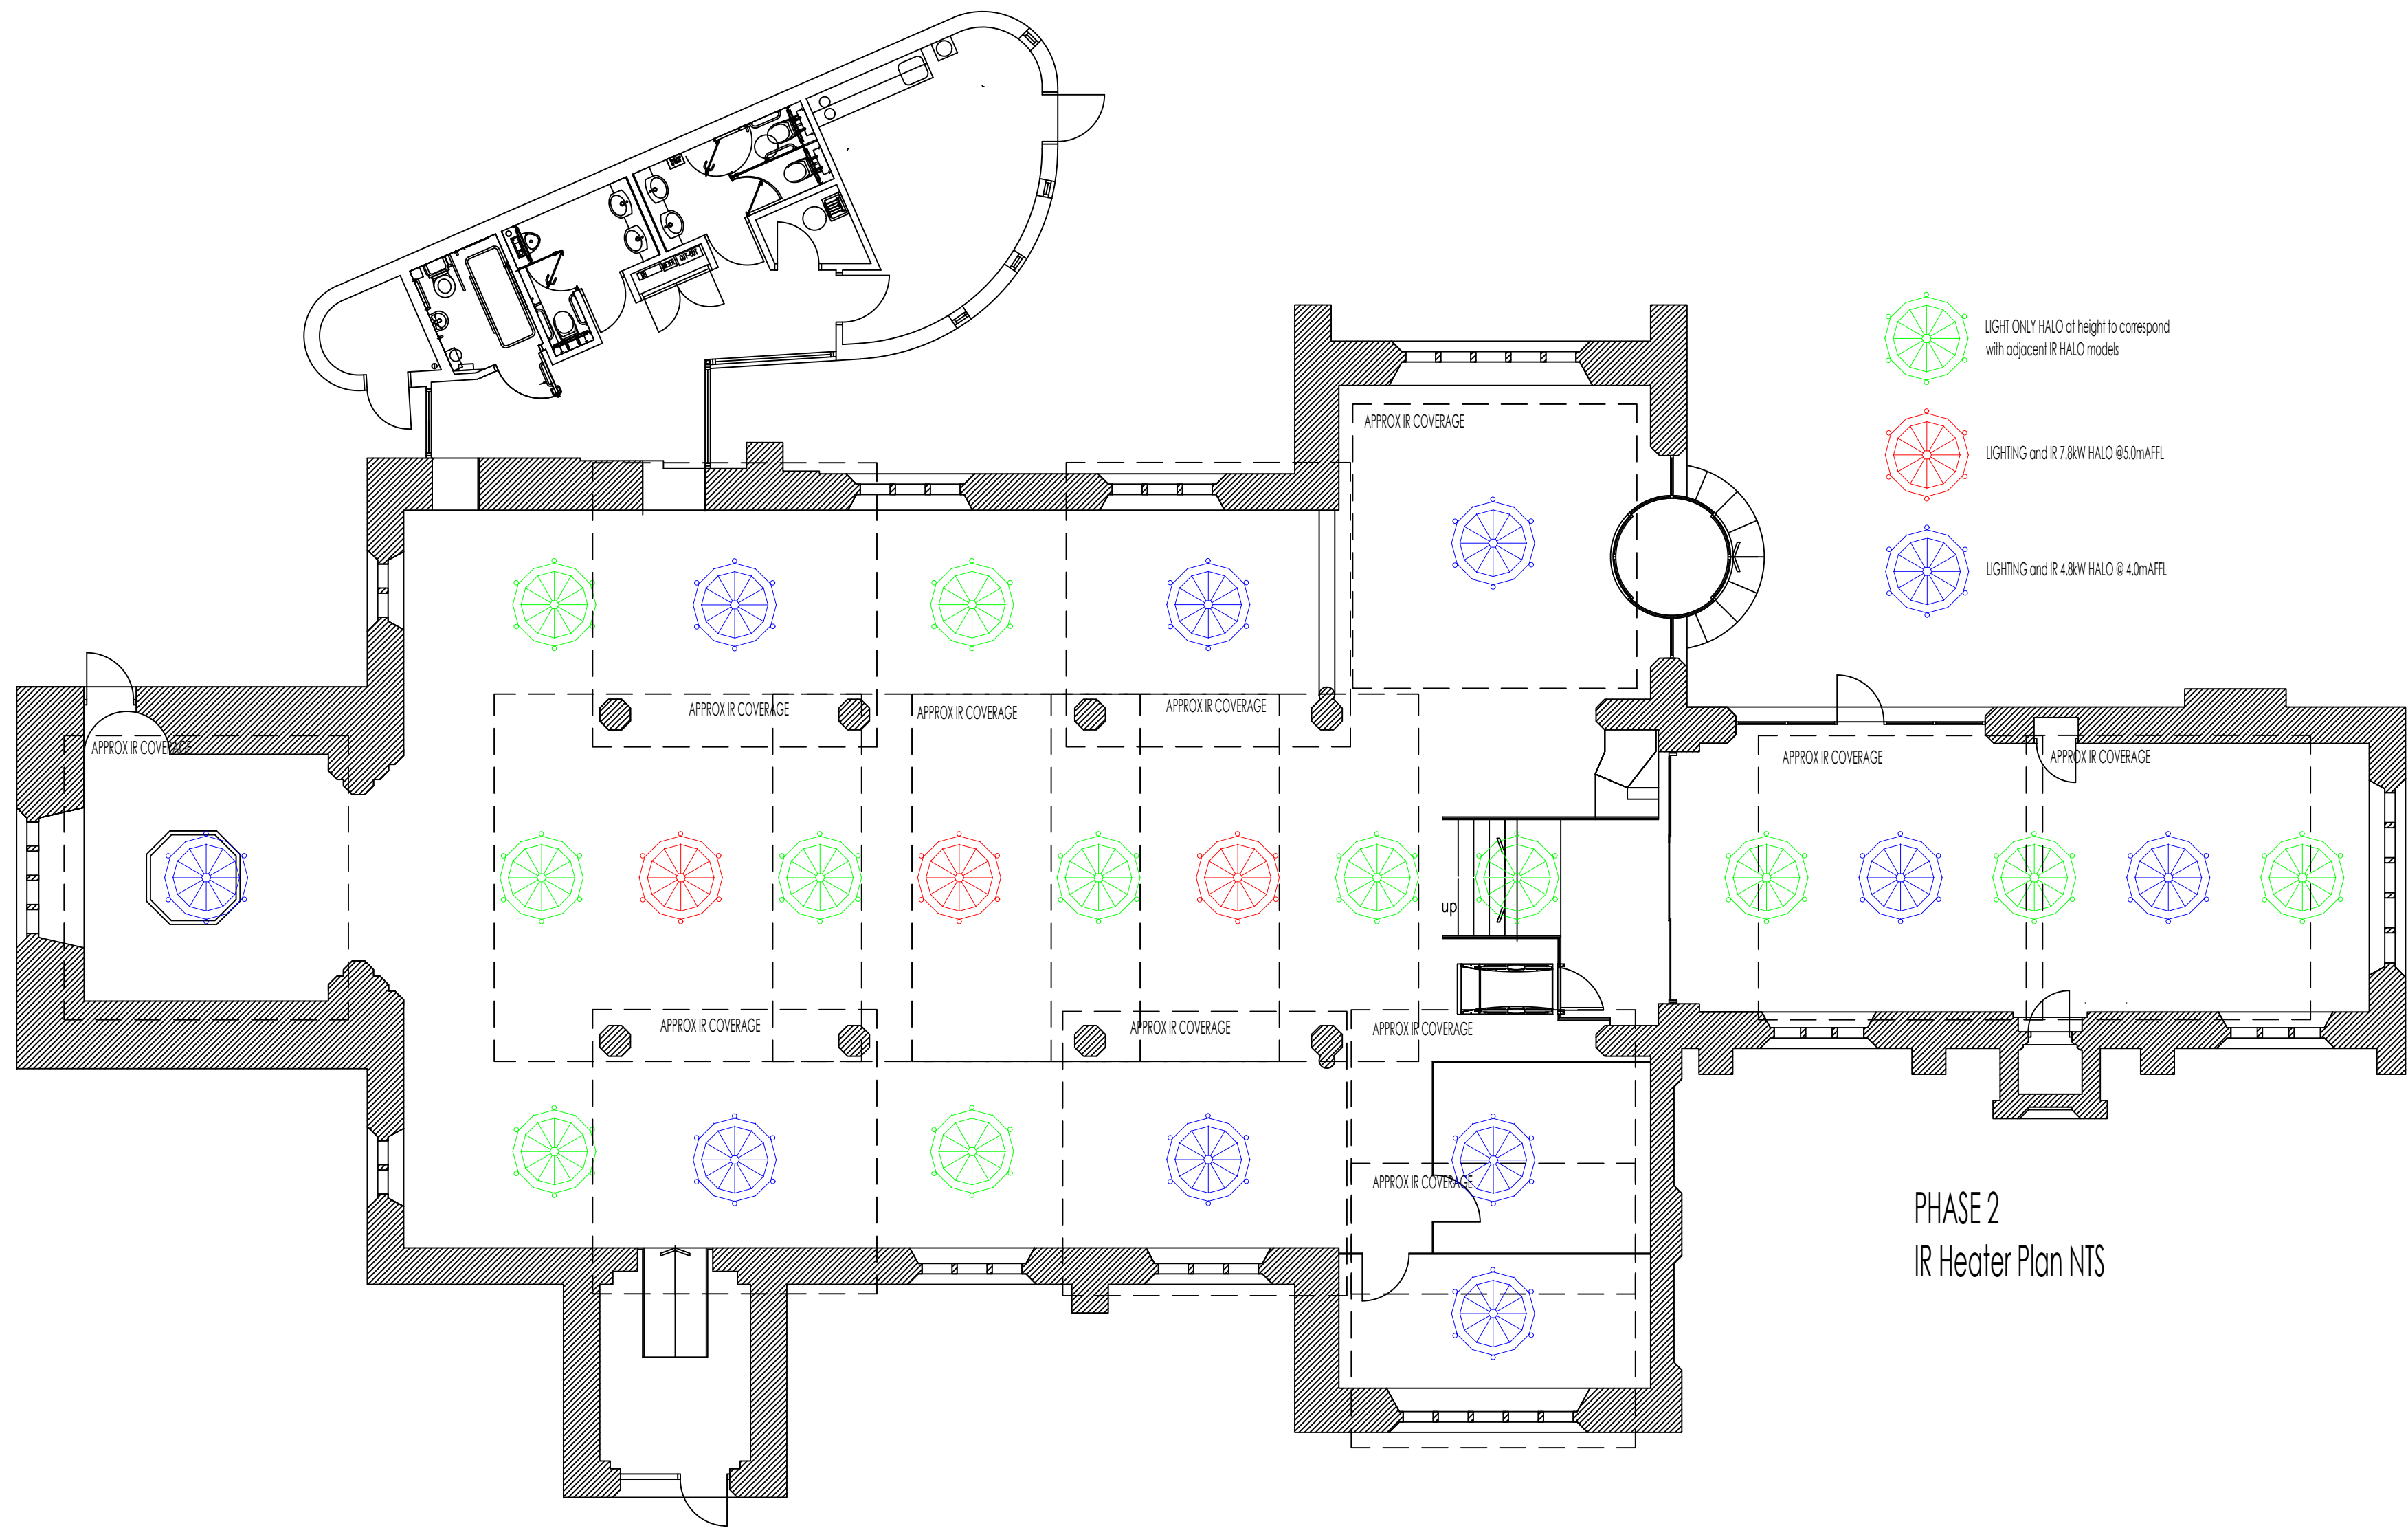

FOR CONSERVATION APPROVAL ONLY - NOT PART OF WORKS

PHASE 2
IR Heater Plan NTS

DATE	REV	DESCRIPTION

Consultant

screen & forster
services design consultancy

Screen & Forster Services Design Consultancy Ltd
20 Portland Terrace, Jesmond
Newcastle upon Tyne, NE2 1QG
T+44 (0) 191 281 4809

Client

Tyne & Wear Building Preservation Trust
John Marley Lodge John Marley Centre, Muscott Grove, Benwell,
Newcastle upon Tyne, NE15 6TT




Project

 St Mary's Heritage Centre
Oakwellgate, Gateshead NE8 2AU
Infra-Red Heating and Lighting Replacement

Title

Proposed Phase 2 - IR Heating and Lighting Replacement

Drawing No.	Revision	Developed by
1458 (63) 03	00	MSC
Scale @ A1	Date	
1:100	NOV 2024	

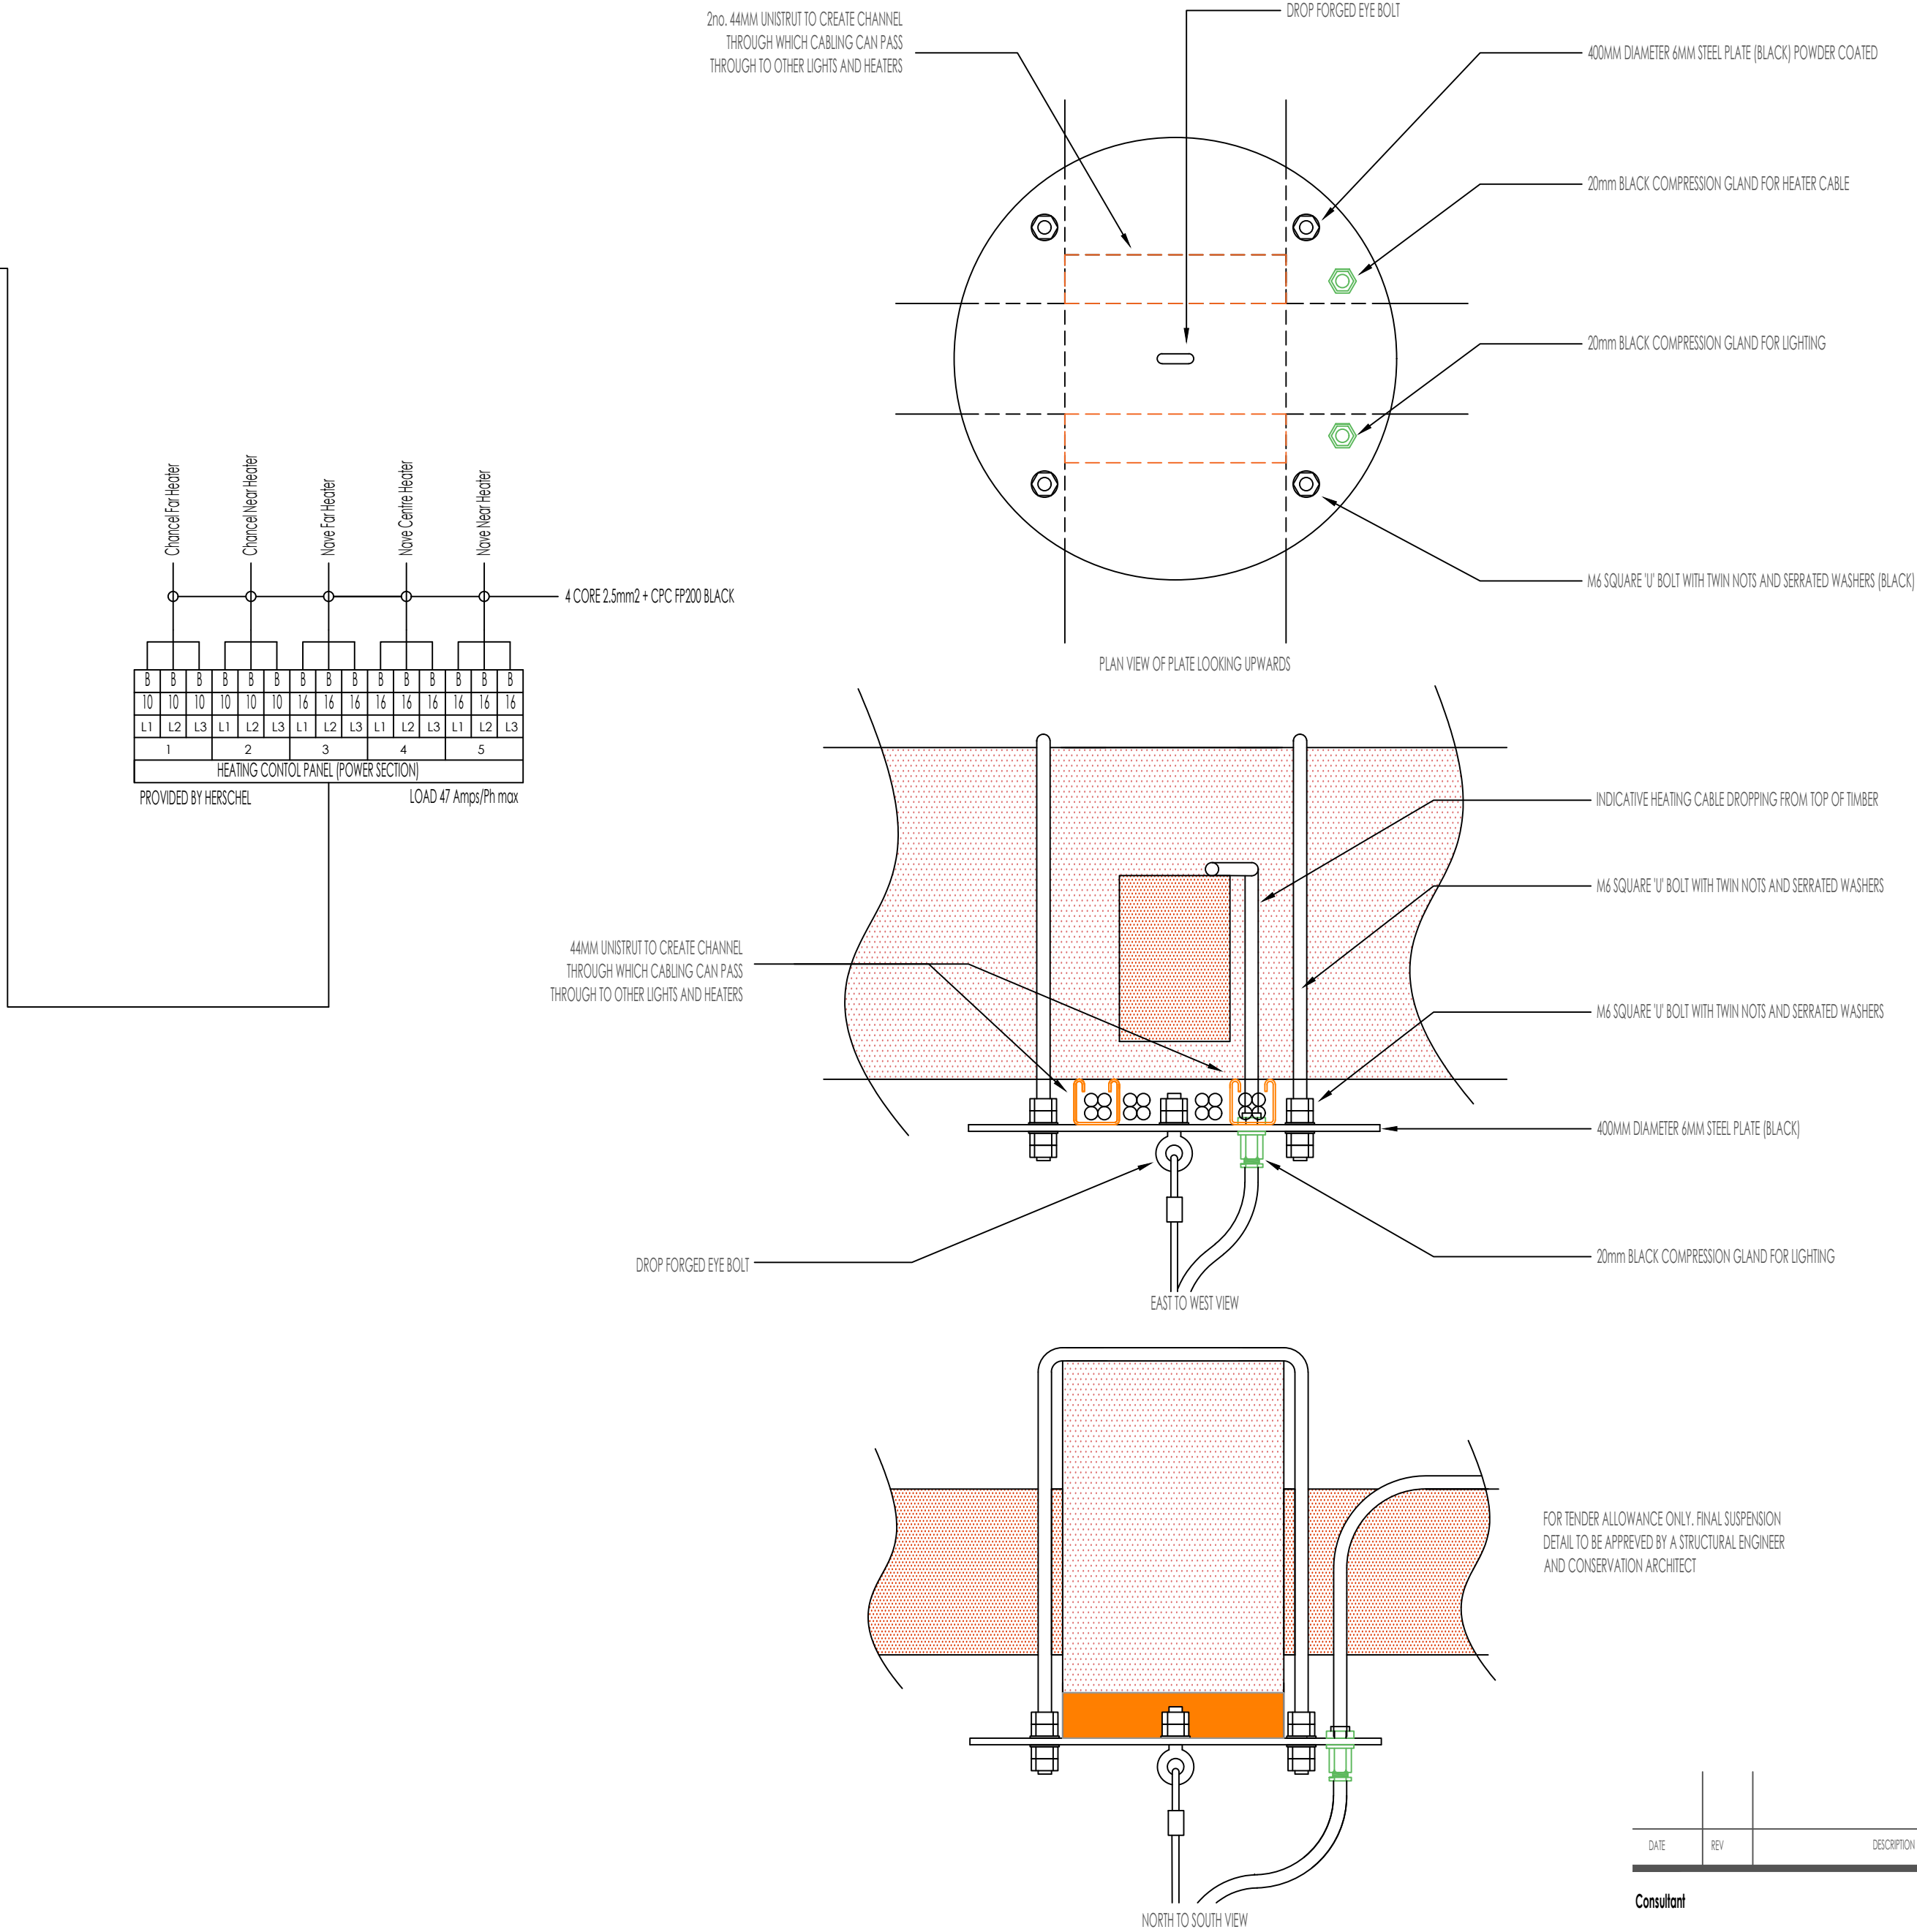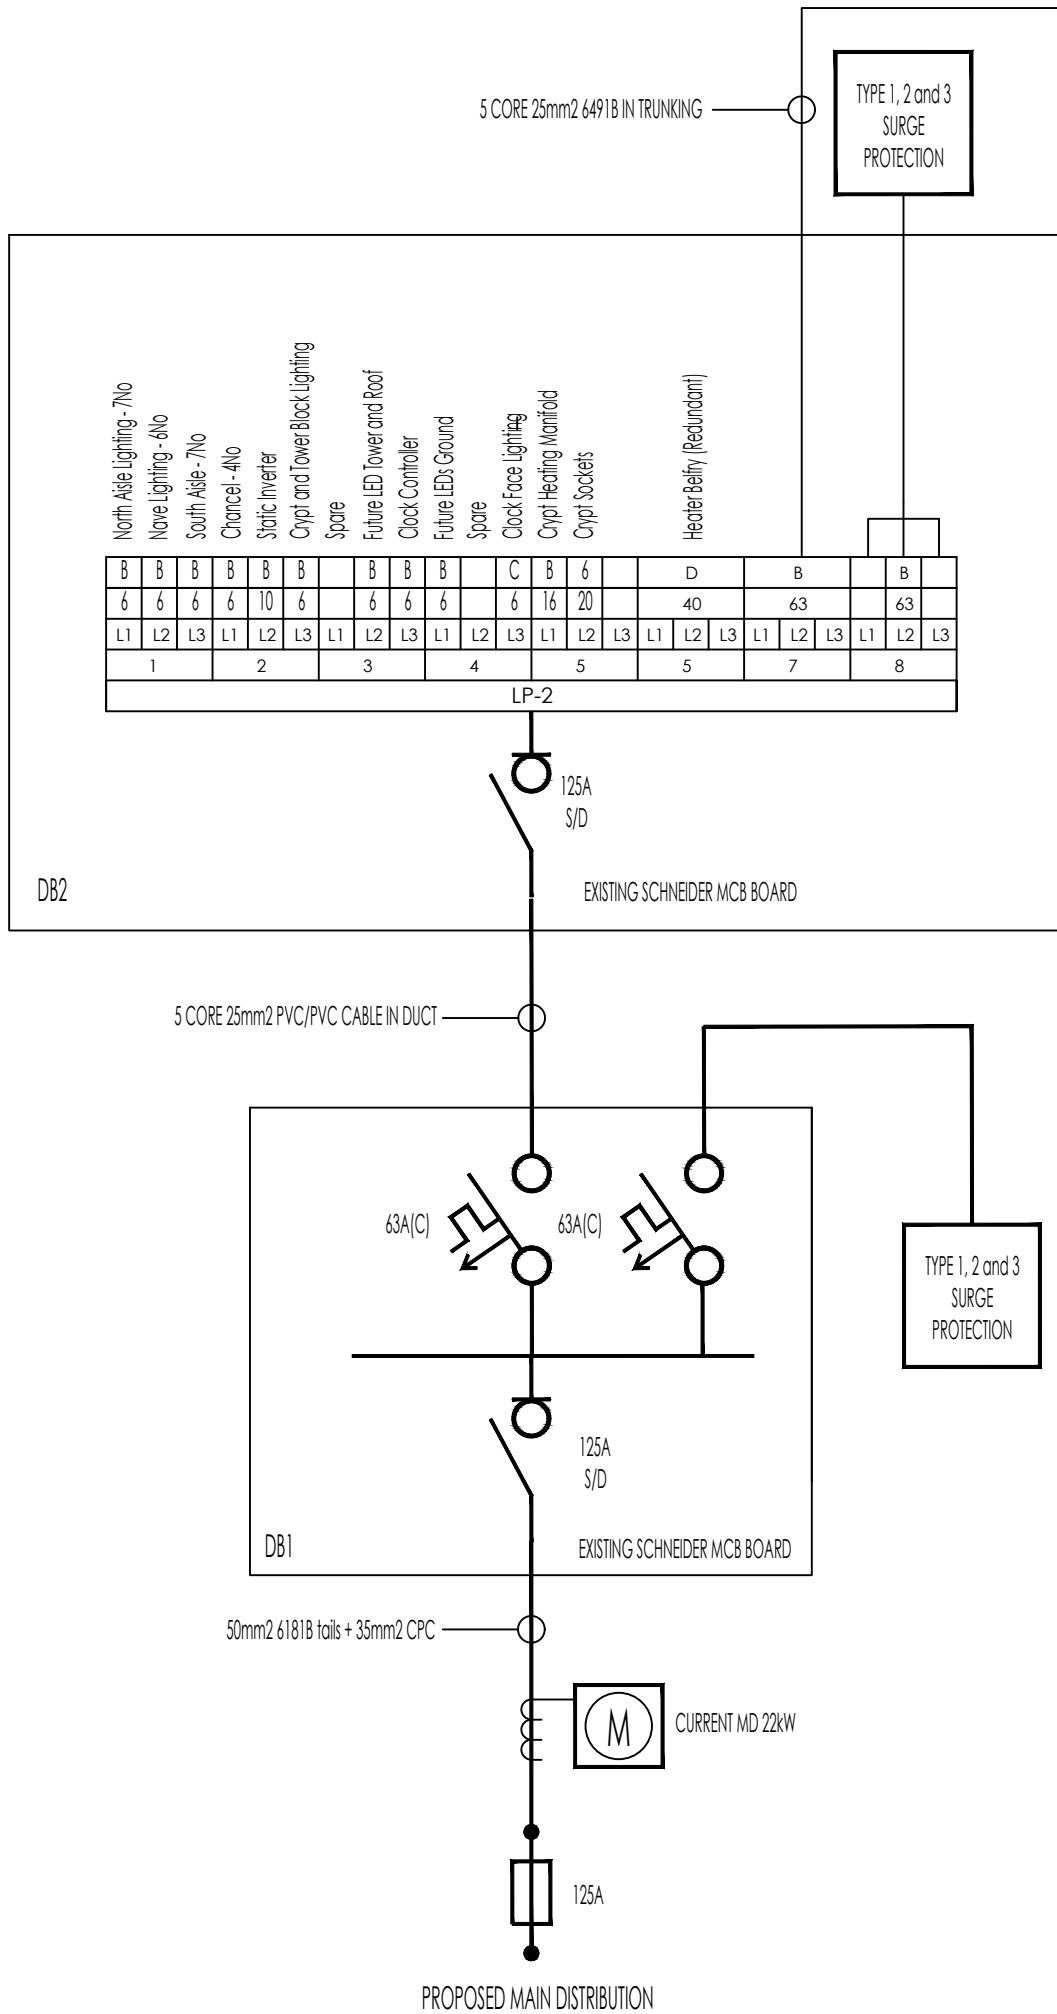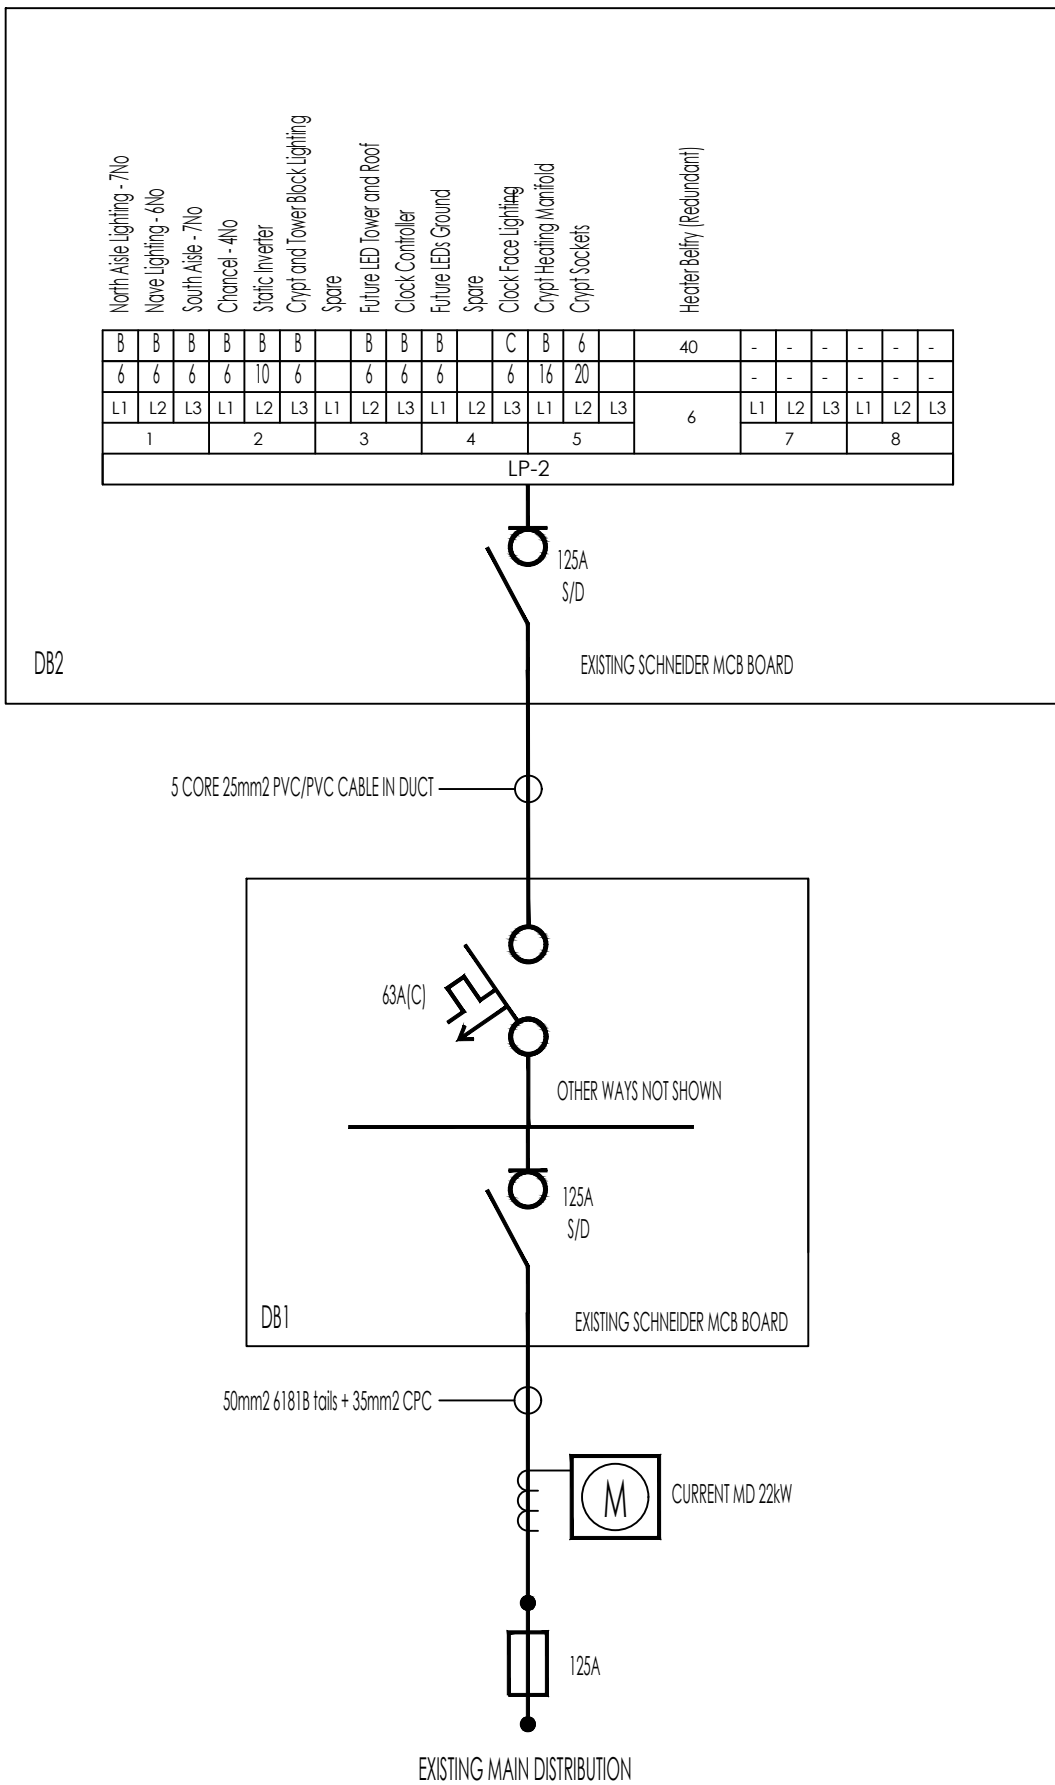

DATE	REV	DESCRIPTION

Consultant

screen & forster

services design consultancy

Screen & Forster Services Design Consultancy Ltd
20 Portland Terrace, Jesmond
Newcastle upon Tyne, NE2 1QG
T +44 (0) 191 281 4809

Client

Tyne & Wear Building Preservation Trust
John Marley Lodge John Marley Centre, Muscott Grove, Benwell,
Newcastle upon Tyne, NE15 6TT

Project

St Mary's Heritage Centre
Oakwellgate, Gateshead NE8 2AU
Infra-Red Heating and Lighting Replacement

Title

Existing and proposed distribution and indicative suspension arrangement for 108kg

Drawing No. 1458 (63) 04	Revision 00	Developed by MSC
Scale @ A1 NTS	Date NOV 2024	