



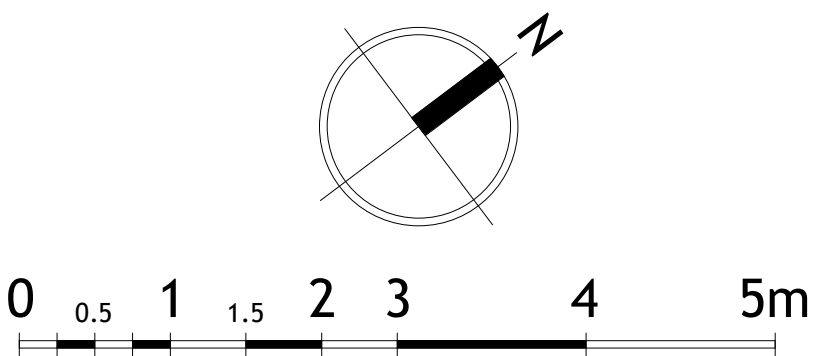

Status: Contract Status

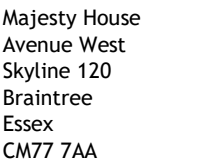

W: www.barker-associates.co.uk
E: mail@barker-associates.co.uk

T: 01279 647111
F: 01279 647027

Client:

Braintree District Council

Project:

I-Construct - Innovation Hub
Springwood Drive
Braintree
CM7 2YN

Title:

Proposed First Floor Plan

Scale @A1:	Date:	Drawn:	Checked:
1 : 50	04/04/19	EH/PP	EH

Drawing no.: P19-094 - BA-XX-01-DR-A-0201	Revision: PR05
--	-------------------

1 01_First Floor Plan
Scale 1 : 50