
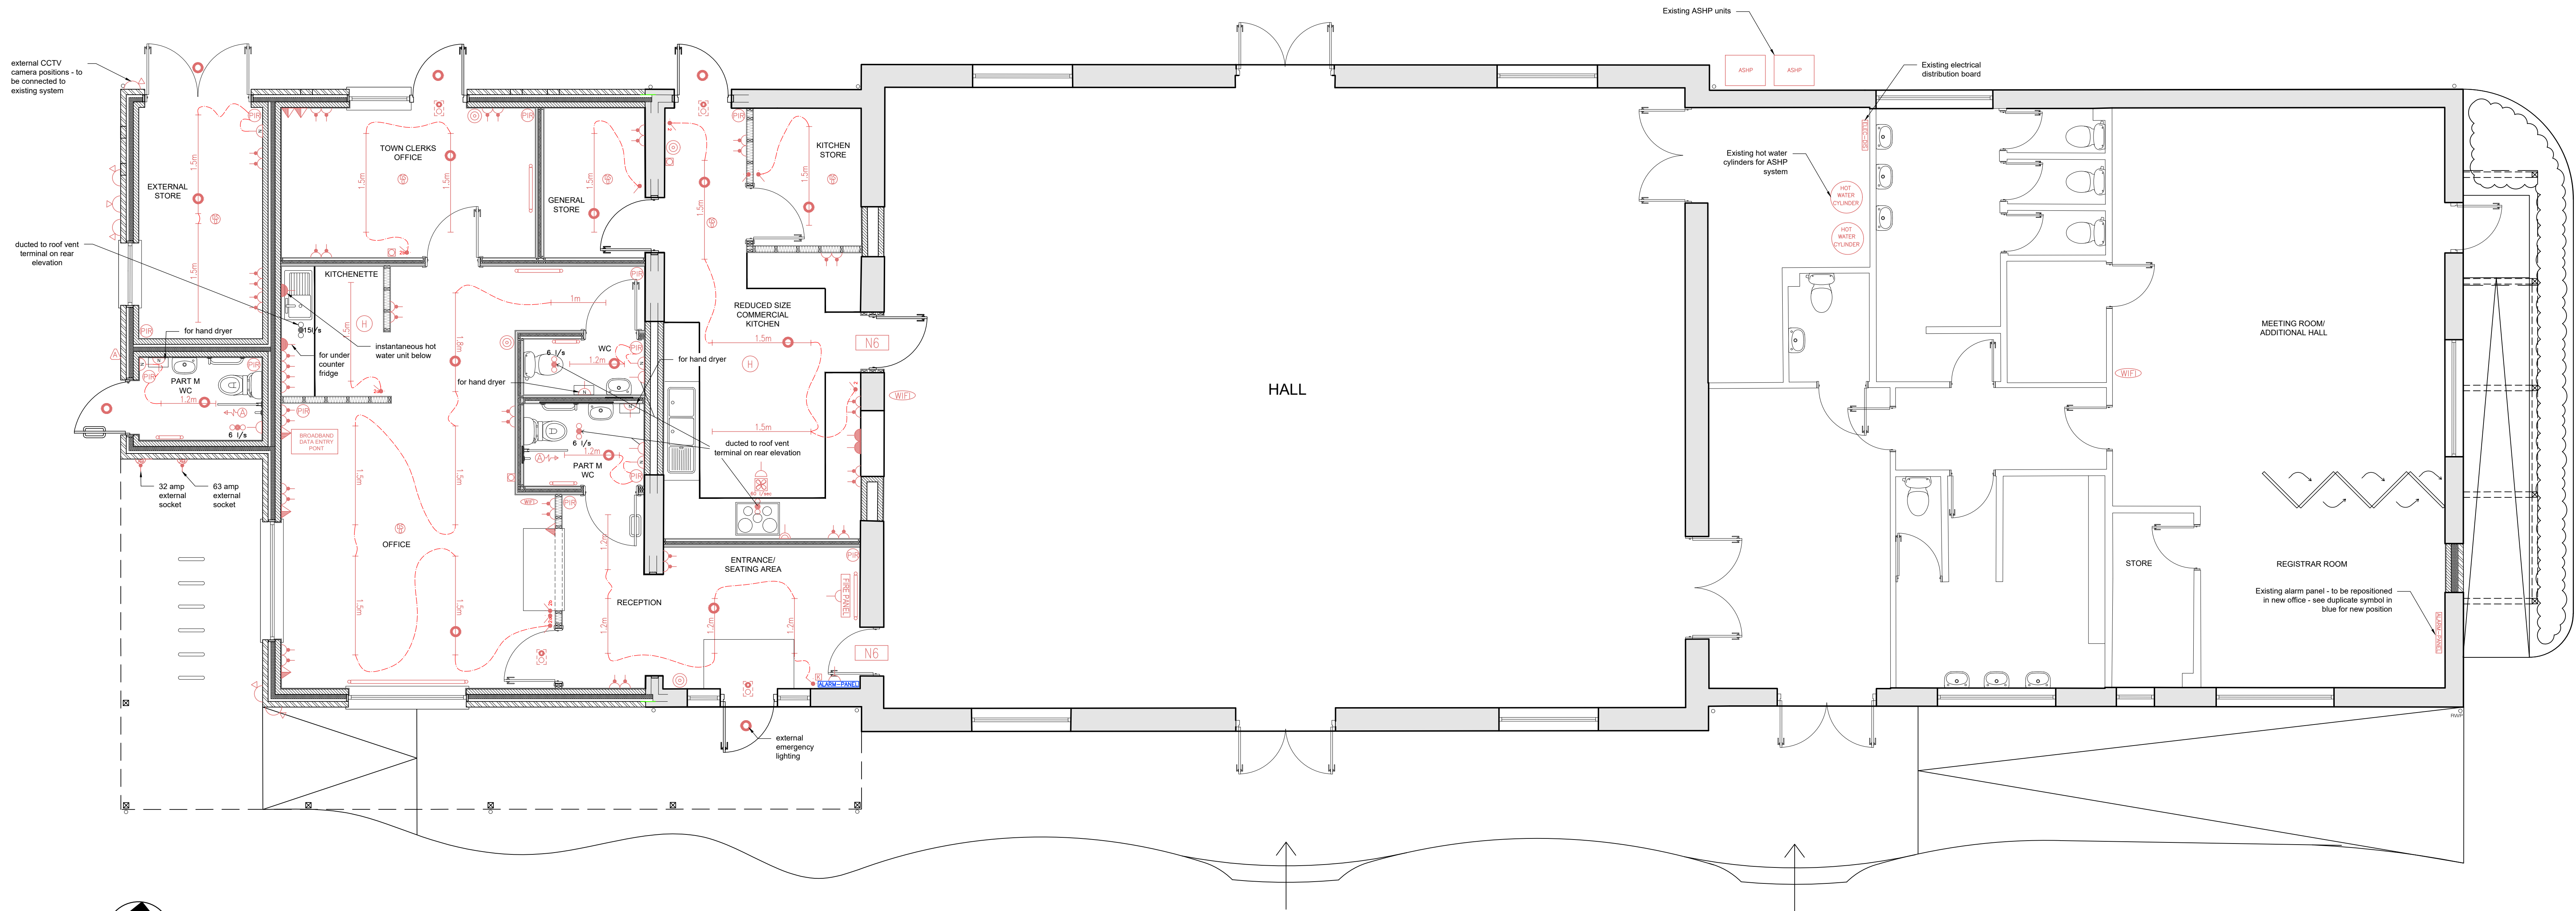


REPRODUCING THESE DRAWINGS BY PRINTING OR COPYING MAY LEAD TO ERRORS. PLEASE REFER TO SCALE BAR. DO NOT SCALE OFF THESE DRAWINGS FOR CONSTRUCTION PURPOSES. IF ANY DISCREPANCIES ARE FOUND, PLEASE CONTACT WESTERN DESIGN ARCHITECTS IMMEDIATELY.

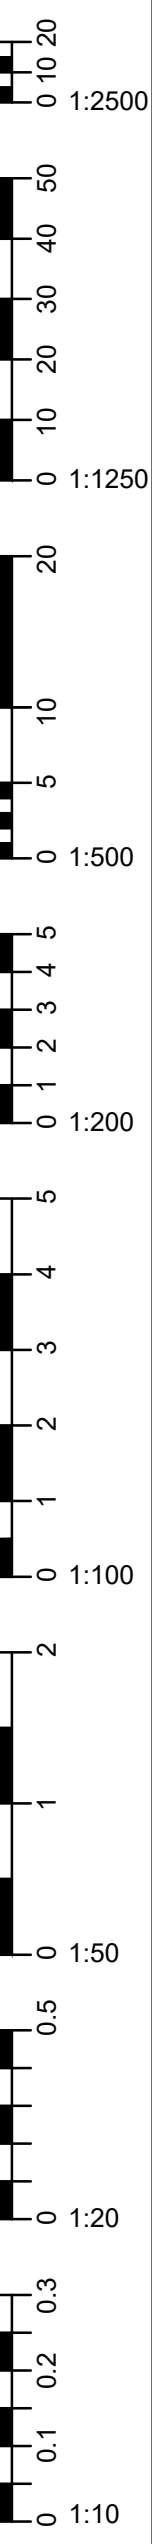

Mechanical and Electrical layout
1:50@A0

ELECTRICAL KEY	
	RADIATOR
	LED STRIP LIGHT - LENGTH
	THERMOSTAT
	COOKER HOOD EXTRACT FAN
	MECHANICAL VENT figures indicate litres per sec
	ELEC DISTRIBUTION BOARD
	ALARM PANEL KEYPAD
	ALARM SOUNDER
	WiFi ROUTER CONNECTION
	DOUBLE DATA OUTLET
	DETECTOR - SMOKE 'OPTICAL' (WAKS POWERED, INTERLINKED)
	HEAT DETECTOR
	MAINTAINED EMERGENCY LIGHTING IN accordance with BS228-1
	FIRE DOOR NOTICE
	FIRE PANEL
	BREAK GLASS EMERGENCY CALL POINT
	FIRE EXIT WITH EMERGENCY LIGHT
	ALARM PASSIVE INFRA RED DETECTOR
	ALARM PANEL
	ALARM PULL CORD
	LIGHT SWITCH - 1/2/3 WAY
	13A DOUBLE SOCKET
	13A SWITCHED SPUR OUTLET WITH NEON INDICATOR
	13A SWITCHED SPUR OUTLET WITHOUT INDICATOR
	OUTLET BELOW WORKTOP, SWITCHED ABOVE
	COOKER OUTLET WITH SWITCHED SOCKET
	'EX' - EXTERNAL SOCKET
	EXTERNAL CCTV CAMERA
	WiFi BOOSTER

DESIGNERS RISK ASSESSMENT-
HEALTH AND SAFETY
THE CONSTRUCTION (DESIGN AND MANAGEMENT) REGULATIONS 2015
A design and risk assessment Drawing COM1 should form part of our drawing package. If you have not received this from us by post, email or by collection please contact us for a copy before moving forward with the project.

B	Revised light fittings omitted - WiFi boosters added	MW	MS	02.10.25
A	ECOA added and associated MBE	MS	MS	23.09.25

REV	REVISION DETAILS	BY	CHKD	DATE
-----	------------------	----	------	------

WDA
westerndesignarchitects.com
Western Design Architects
12 The Granary, Hinton Business Park, Tarrant Hinton, Dorset, DT11 8JF
T: 01208 800073 E: info@westerndesign.co.uk

CLIENT
Chickerell Town Council

PROJECT
Willowbed Hall, Chickerell

DRAWING TITLE
Mechanical and Electrical layout

DRAWN BY RS	DESIGNED BY MW	DATE 12.08.2025
----------------	-------------------	--------------------

SCALE 1:50@A0	JOB NO. 2425051
------------------	--------------------

DRAWING NO. 106	REVISIONS B
--------------------	----------------

BUILDING REGULATIONS

THIS DRAWING IS COPYRIGHT © Western Design Ltd 2025