


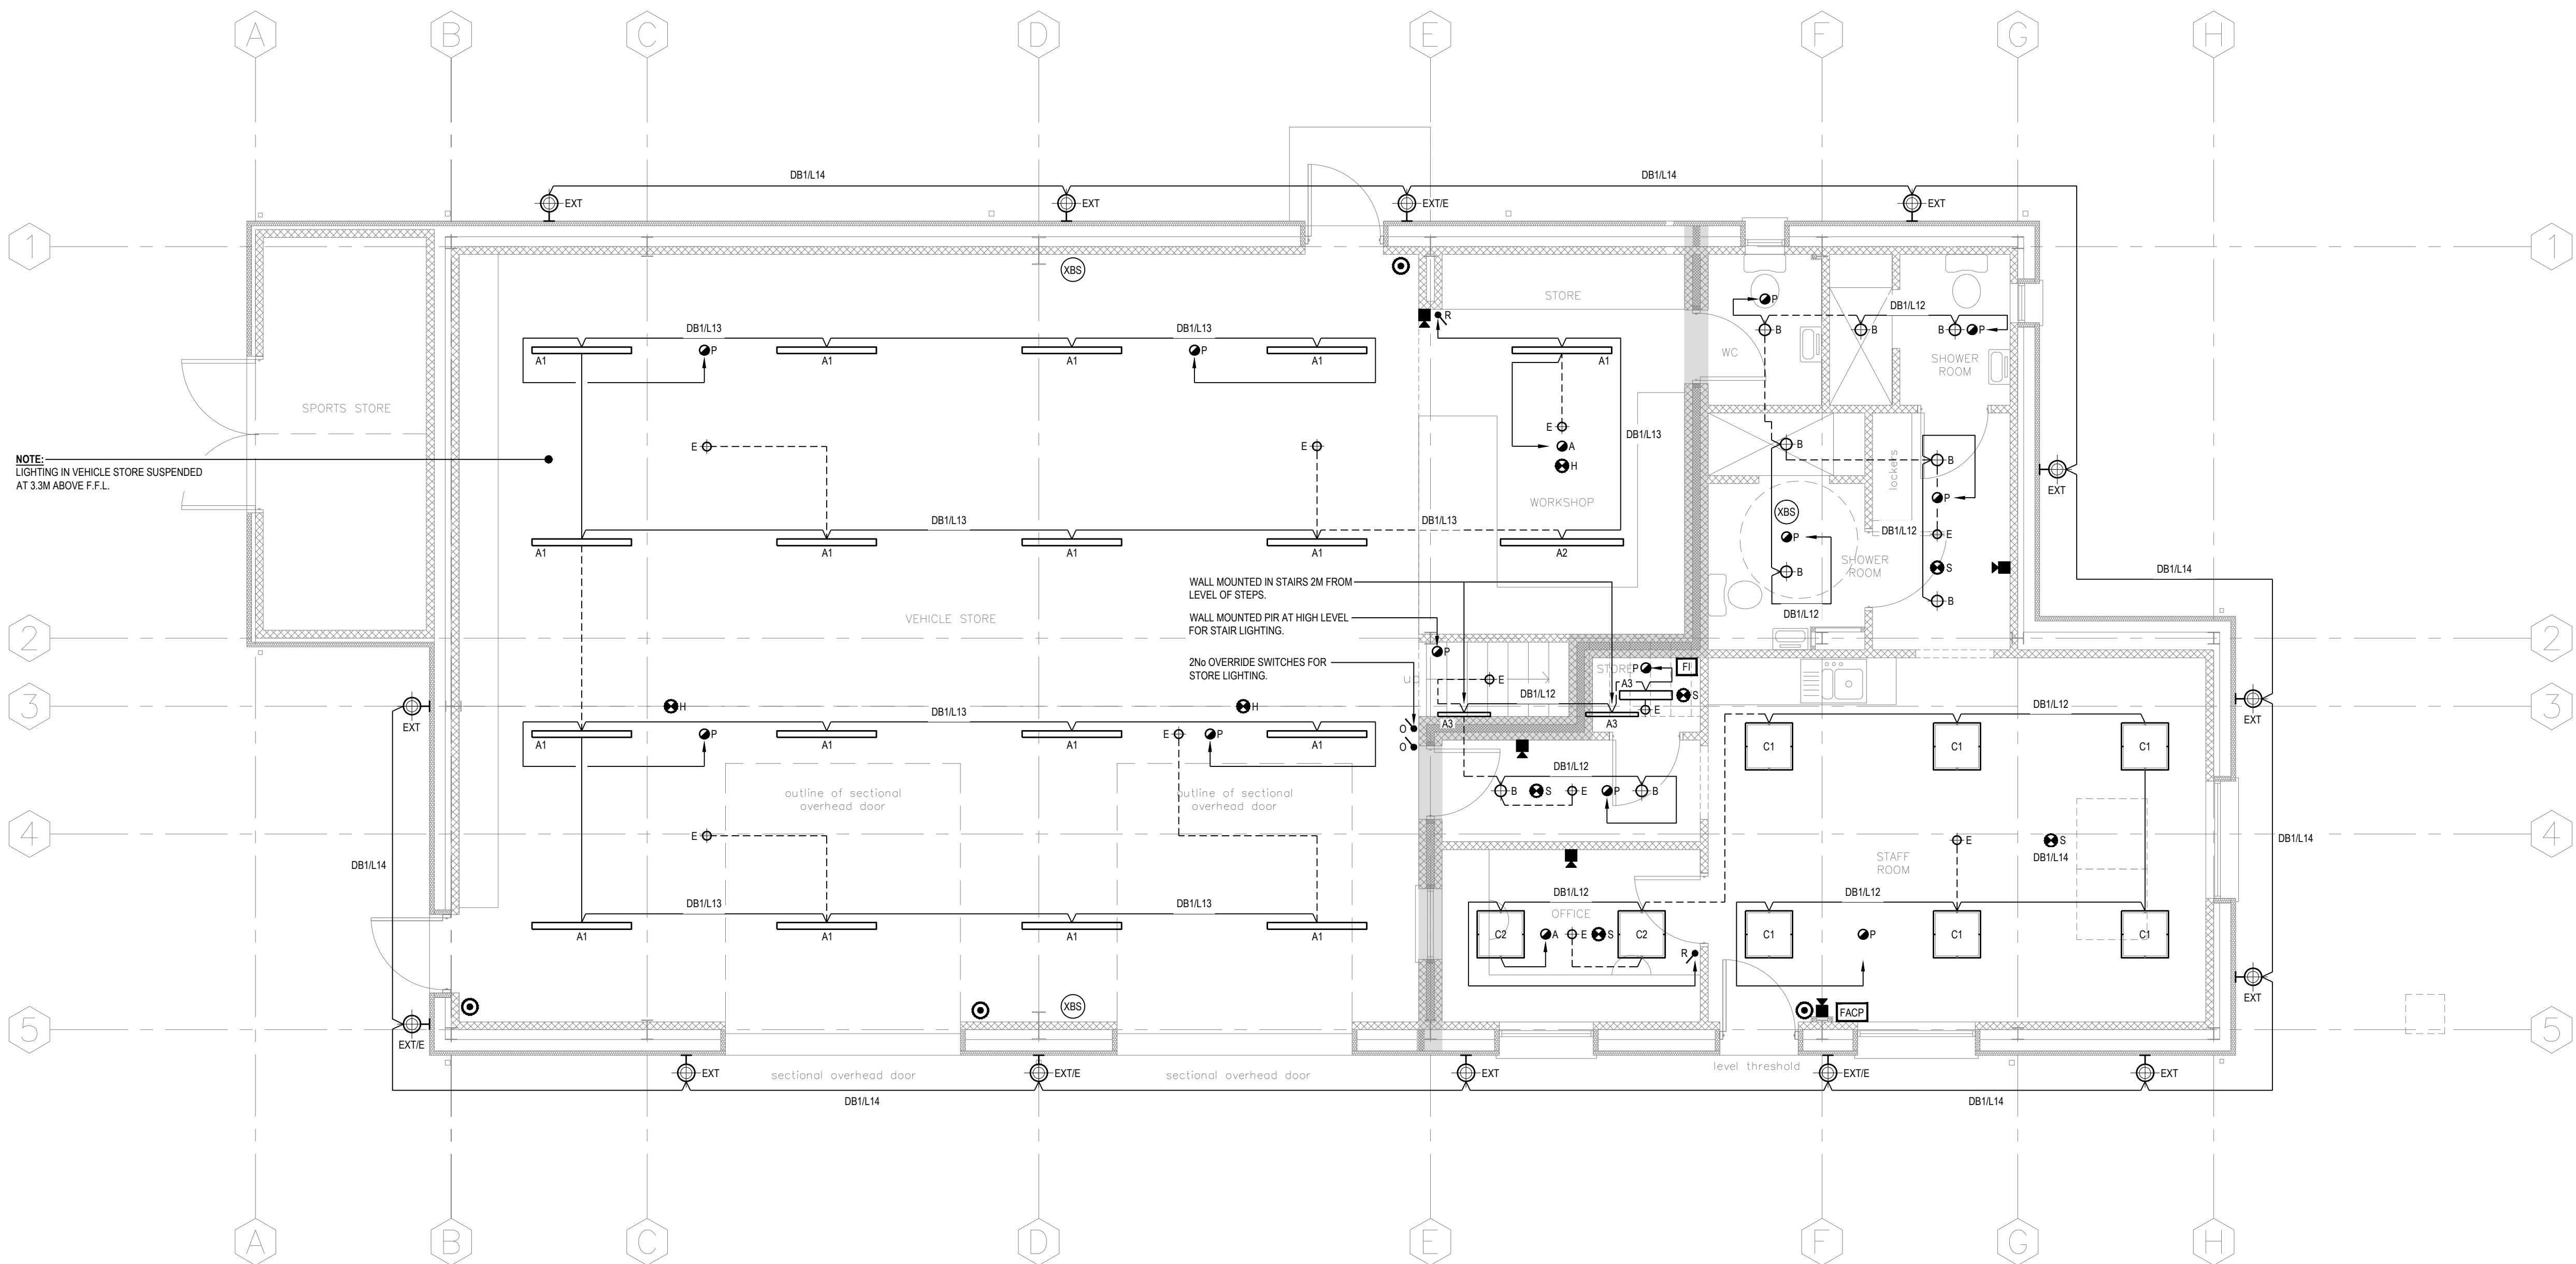

NOTE:
LIGHTING IN VEHICLE STORE SUSPENDED
AT 3.3M ABOVE F.F.L.


- NOTES:
- DO NOT SCALE FROM THIS DRAWING.
 - THE CONTRACTOR IS TO VERIFY ALL DIMENSIONS, TOLERANCES, AND REFERENCES ON SITE PRIOR TO COMMENCEMENT OF THE WORKS.
 - THE CONTRACTOR IS TO CONSULT THE LATEST ASBESTOS REGISTER AND ANY OTHER ASBESTOS REPORTS THAT MAY HAVE BEEN PRODUCED FOR THIS PROJECT PRIOR TO COMMENCEMENT OF THE WORKS.
 - THIS DRAWING IS TO BE READ IN CONJUNCTION WITH THE WRITTEN SPECIFICATION AND ALL OTHER SPECIFIC PROJECT/ DESIGN DOCUMENTATION.
 - FINAL POSITIONS OF ALL CONTROLLERS AND SENSORS ARE TO BE AGREED ON SITE PRIOR TO COMMENCEMENT OF THE WORKS.

T	27.04.18	TENDER ISSUE	PSB
REV	DATE	AMMENDMENTS	APP

PSB Consulting Engineers (Oxford) Ltd

SUITE 4 MERCHANT HOUSE
5 EAST ST HELEN STREET
ABINGDON
OXFORDSHIRE
OX14 5EG
TEL: 01235 408425
EMAIL: info@psbconsulting.co.uk
WWW: psbconsulting.co.uk

 CLIENT



ARCHITECT



PROJECT

EDMONDS PARK
OUTDOOR SERVICES DEPOT

TITLE

GROUND FLOOR
PROPOSED LIGHTING, EMERGENCY
LIGHTING & FIRE ALARM LAYOUT

DRAWING NUMBER: 1320.01/E001/T

SCALE	SIZE	DWN	CKD	APP	DATE	REV
1:50	A1	PSB	PQ	PSB	27.04.2018	T

LIGHTING LEGEND	
	15/20A 1 GANG 1 WAY LIGHTING SWITCH. G - DENOTES NUMBER OF GANGS.
	15/20A 1 GANG 2 WAY LIGHTING SWITCH. G - DENOTES NUMBER OF GANGS.
	15/20A 1 GANG 1 WAY DIMMABLE LIGHTING SWITCH. G - DENOTES NUMBER OF GANGS.
	15/20A 1 GANG 1 WAY RETRACTIVE SWITCH. G - DENOTES NUMBER OF GANGS.
	KEY SWITCH.
	ABSENCE DETECTOR.
	PRESENCE DETECTOR.
	LOCAL DISTRIBUTION BOARD.

FIRE ALARM LEGEND	
	POINT SMOKE DETECTOR.
	POINT HEAT DETECTOR.
	FIRE ALARM SOUNDER
	XENON BEACON.
	BASE MOUNTED FIRE ALARM XENON BEACON & SOUNDER.
	FIRE ALARM INTERFACE UNIT.
	FIRE ALARM CALL POINT.
	FIRE ALARM CONTROL PANEL.

FEILO SYLVANIA LIGHTING SCHEDULE OF LUMINAIRES	
A1	SYLPROOF SUPERIA LED G3 1200mm SINGLE 4K REF 0048693.
A2	SYLPROOF SUPERIA LED G3 1500mm SINGLE 4K REF 0048712.
A3	SYLPROOF SUPERIA LED G3 600mm SINGLE 4K REF 0048689.
B	ASCENT 100 II ARCH 1800 4K STD 160 + IP54 PC COVER REF 2060555 + 2039013.
C1	START FLAT PANEL LED LOW OUTPUT 600 3000K G2 + SM FRAME REF 0047642 + 3036809.
C2	START FLAT PANEL LED LOW OUTPUT 600 4000K G2 + SM FRAME REF 0047643 + 3036809.
E	ROUTELED II OPEN AREA + SM ACCESSORY REF 2059459 + 2059462.

APOLLO LIGHTING SCHEDULE OF LUMINAIRES	
EXT	ROMAN EXTERIOR LUMINAIRE COMPLETE WITH MICROWAVE SENSOR.
EXT/E	AS TYPE 'EXT' BUT FITTED WITH 3 HOUR NON MAINTAINED EMERGENCY INTEGRAL BATTERY INVERTER UNIT.