



David Bullen Limited
Chartered Building Surveyors



Tel: (01493) 842 168
e.mail: info@dbsurveyors.co.uk

CLIENT: Great & Little Plumstead Parish Council

DRG. No: 441-B-013

PROJECT:
New Recreational Facilities
Great Plumstead


DRG. SCALE: 1:100

DATE: MAY 2024

PAGE SIZE: ISO A1

DRAWING TITLE: Indicative Electrical Layout

REVISIONS:

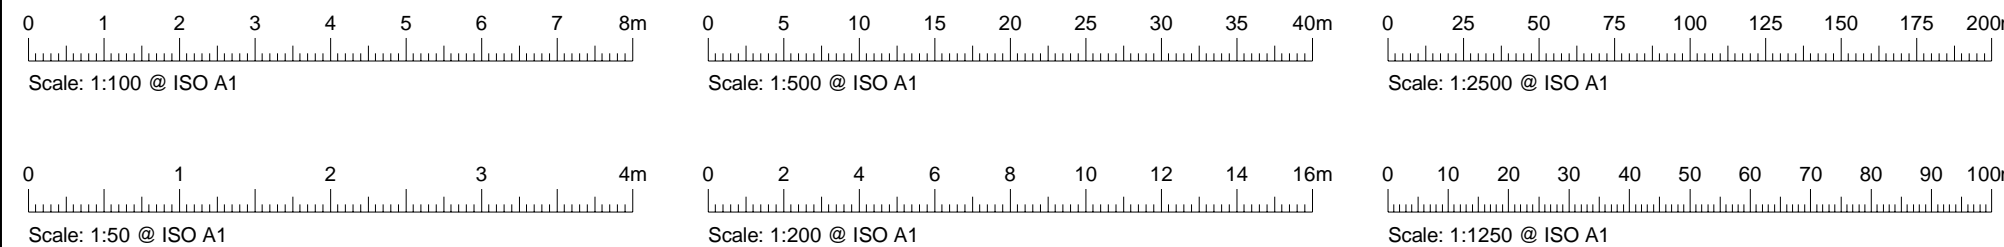

These scales are provided for guidance only and should not be relied upon for taking accurate measurements off the drawing.
Should you wish to check any dimensions, please call us and we will be able to confirm exact measurement data as required.