





1 LOCATION PLAN.
1:1250

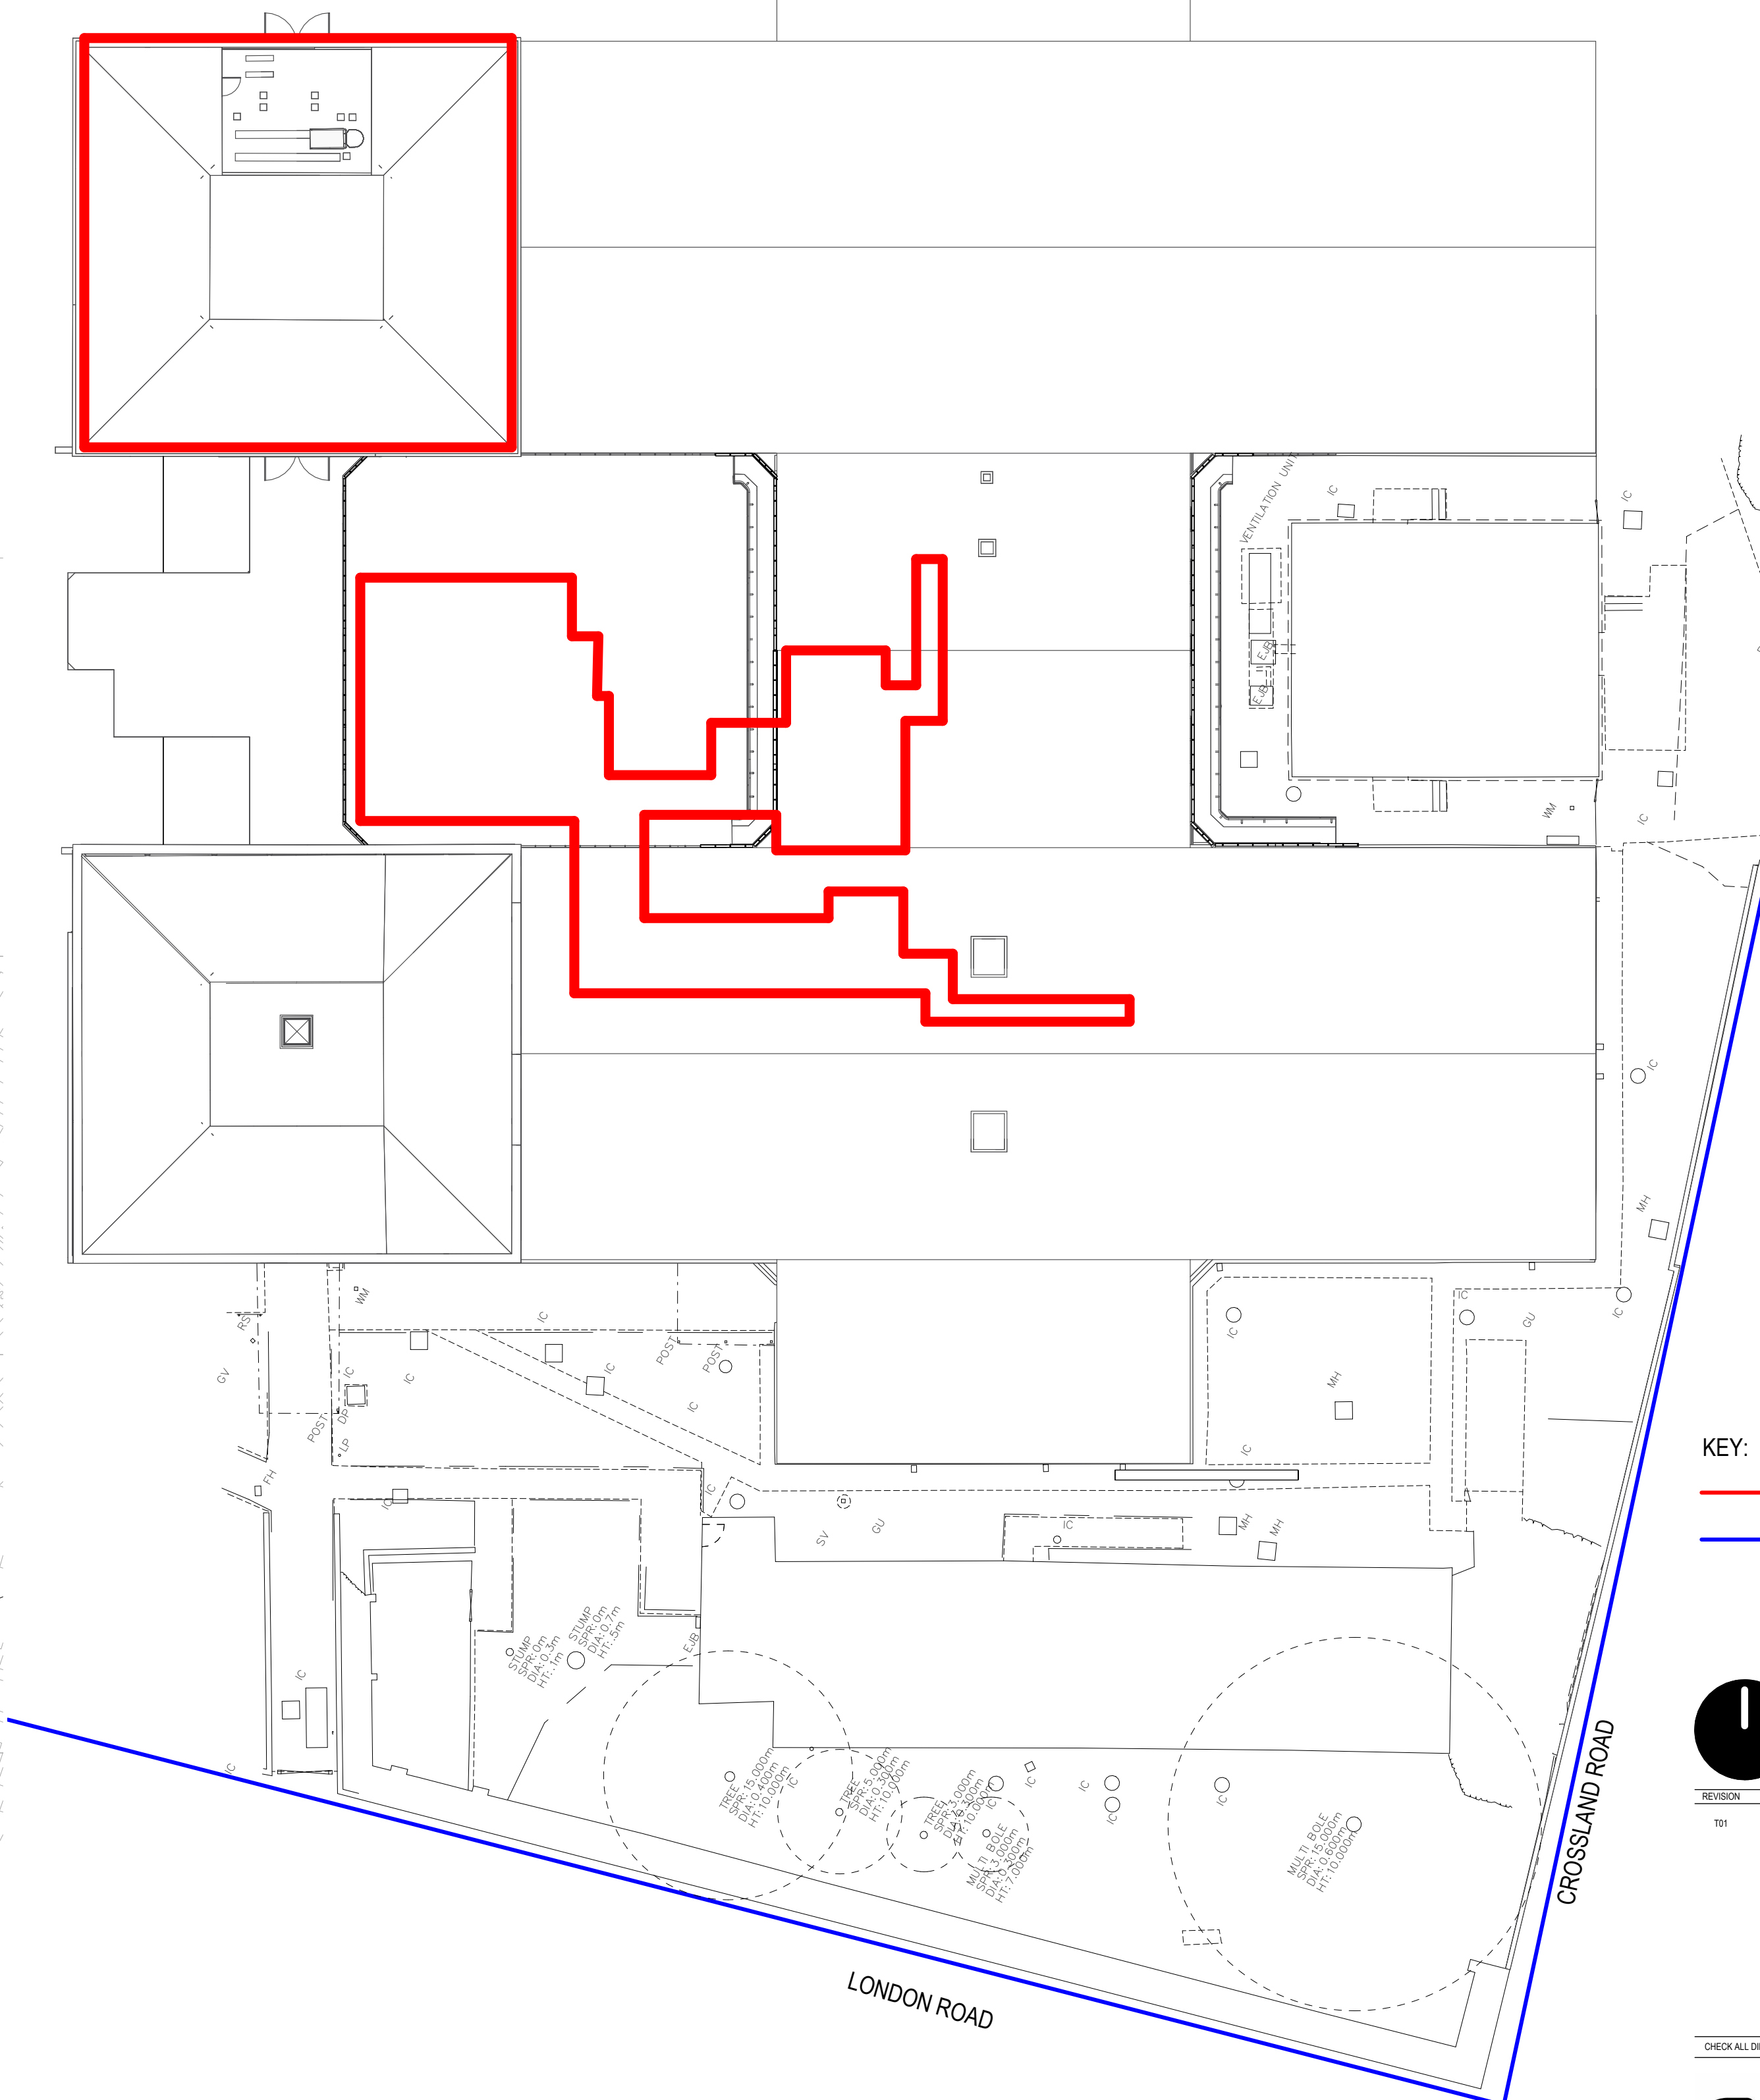

2 PROPOSED SITE PLAN..
1:200

KEY:
SITE BOUNDARY
OWNERSHIP BOUNDARY

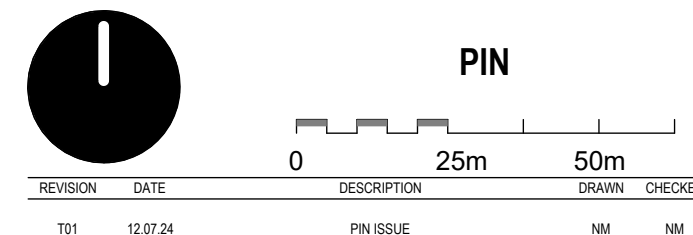

CHECK ALL DIMENSIONS AND VERIFY ON SITE. REPORT ANY ERRORS OR OMISSIONS.

adp

The Fire Station
150 Waterloo Road
London
SE1 8SB
T +44 (0) 20 7089 1720
E london@adp-architecture.com
www.adp-architecture.com

JOB TITLE:
**ELECTIVE OPERATING THEATRES
CROYDON UNIVERSITY HOSPITAL**

DRAWING TITLE:
SITE LOCATION AND LOCATION PLAN

SCALE: As indicated		DRAWING SHEET SIZE: A1
JOB CODE: CSEH	DRAWING NUMBER: ADP-XX-XX-DR-A-00802	REVISION: T01
SUITABILITY: S2 - ISSUED FOR INFORMATION		