
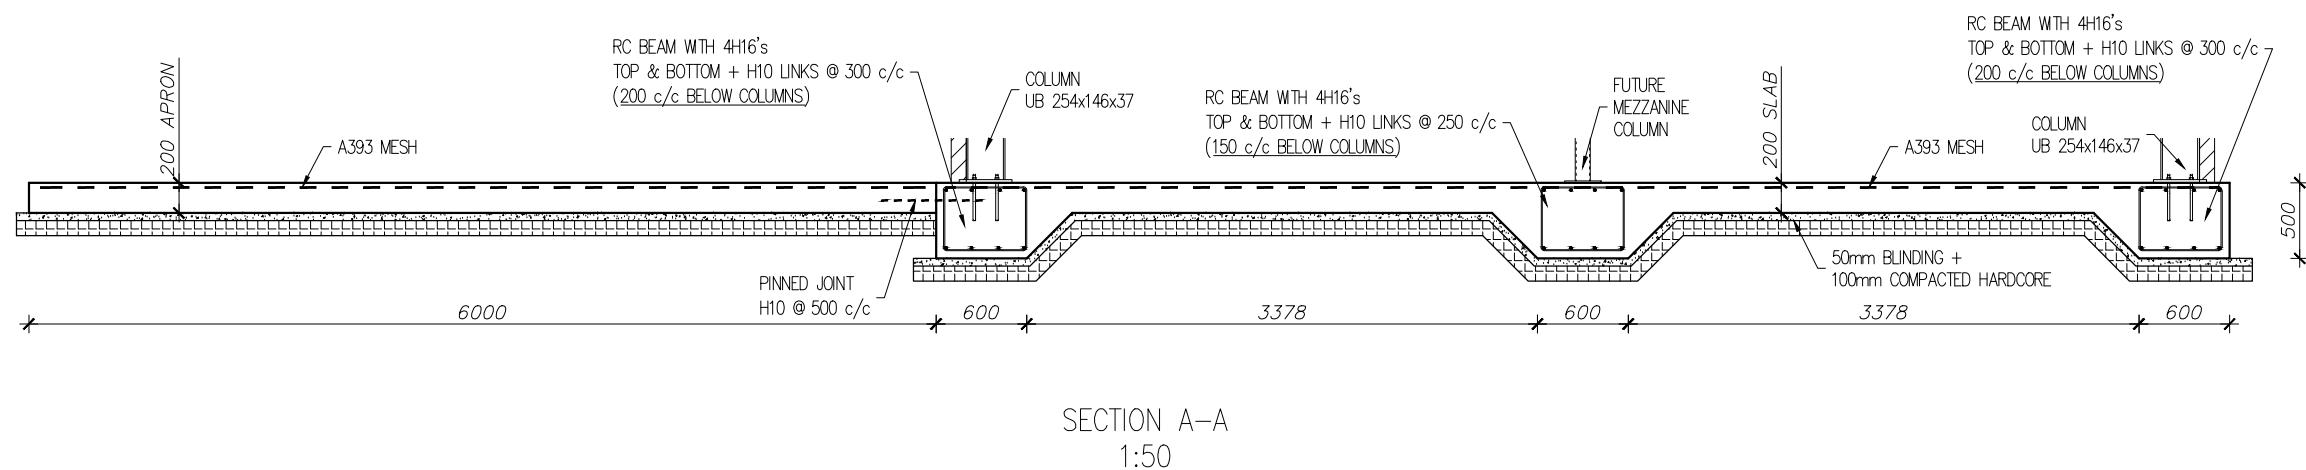


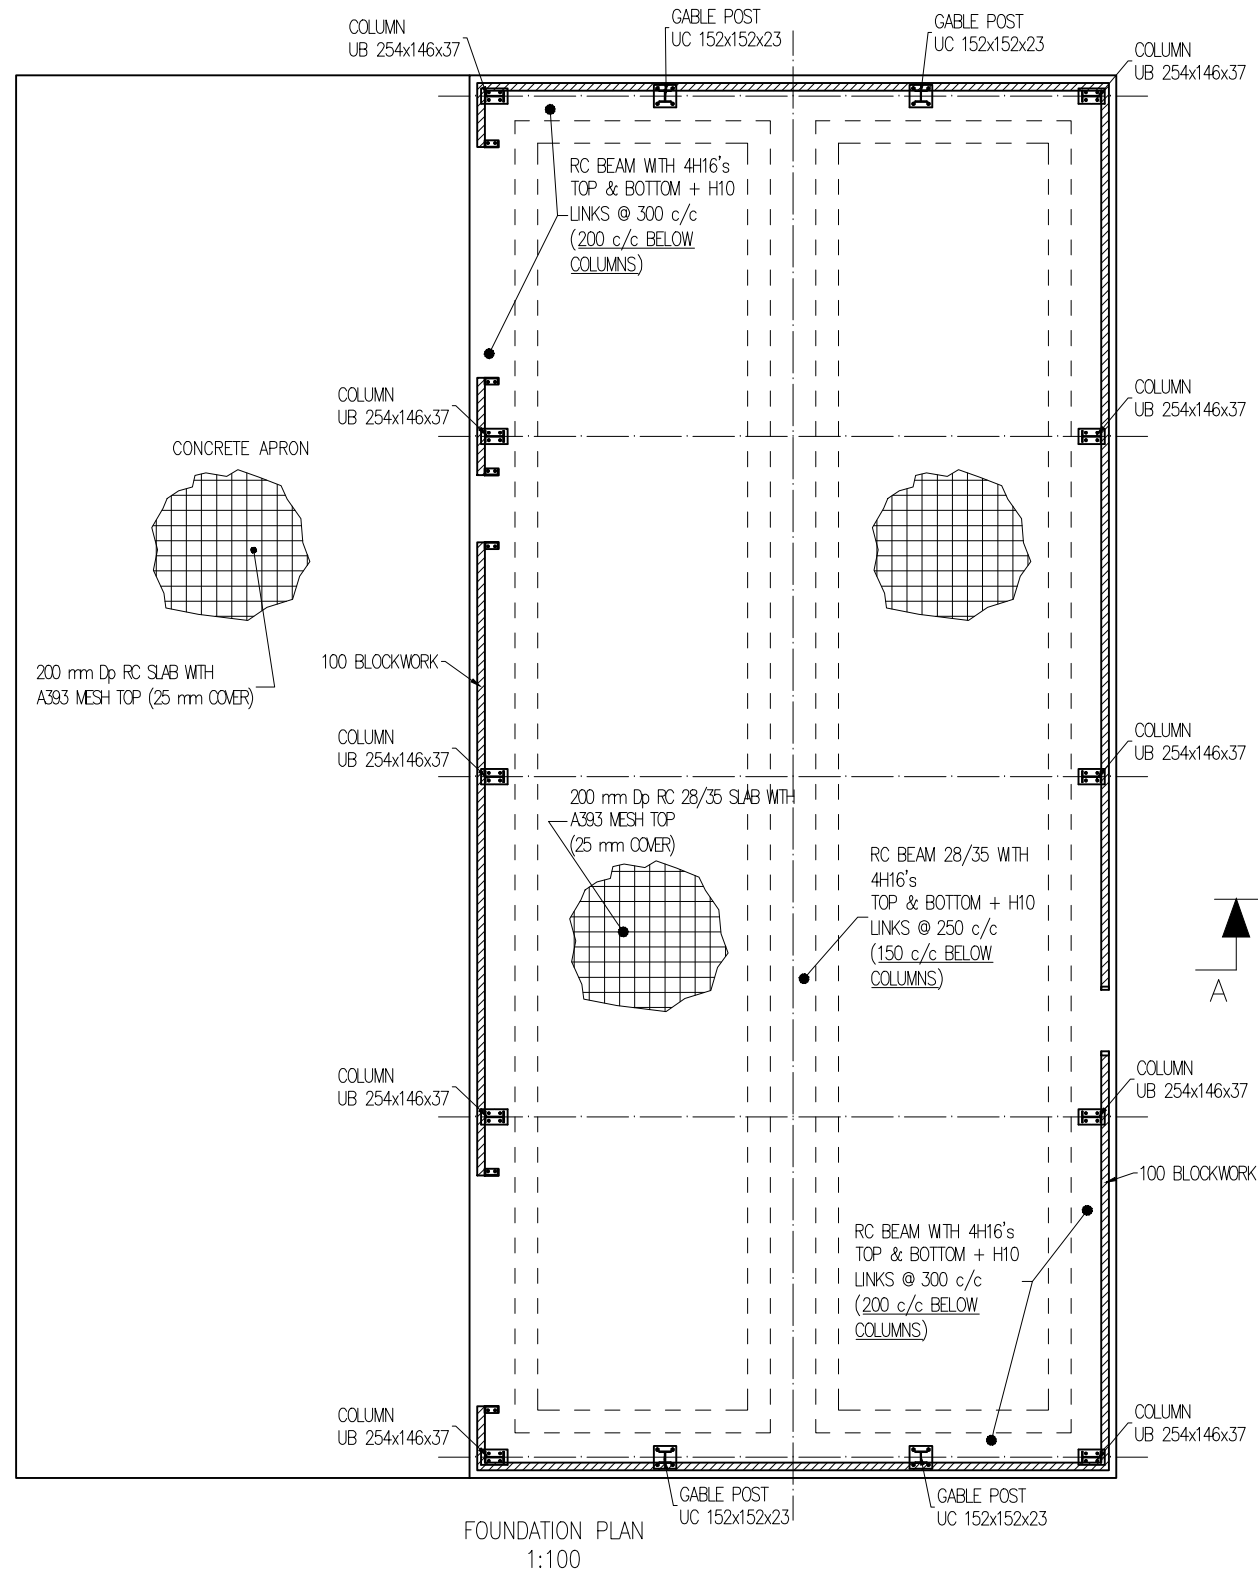

A Drawing updated		March 2018
REV	DESCRIPTION	DATE
Archibald Shaw Consulting Civil & Structural Engineers One Little London Chichester West Sussex PO19 1PP Telephone: 01243 786471 Facsimile: 01243 779346 mail@archibaldshaw.co.uk www.archibaldshaw.co.uk		
CLIENT Selsey Town Council		
PROJECT Mill Lane, Storage Unit Foundation Plan		
DRAWN BY PL	CHECKED BY LJ	DESIGNED BY LJ
SCALE @ A3 1:100 1:50	DATE AUGUST 2017	STATUS Preliminary
JOB NO. 28252	DRAWING NO. 4	REVISION A