
 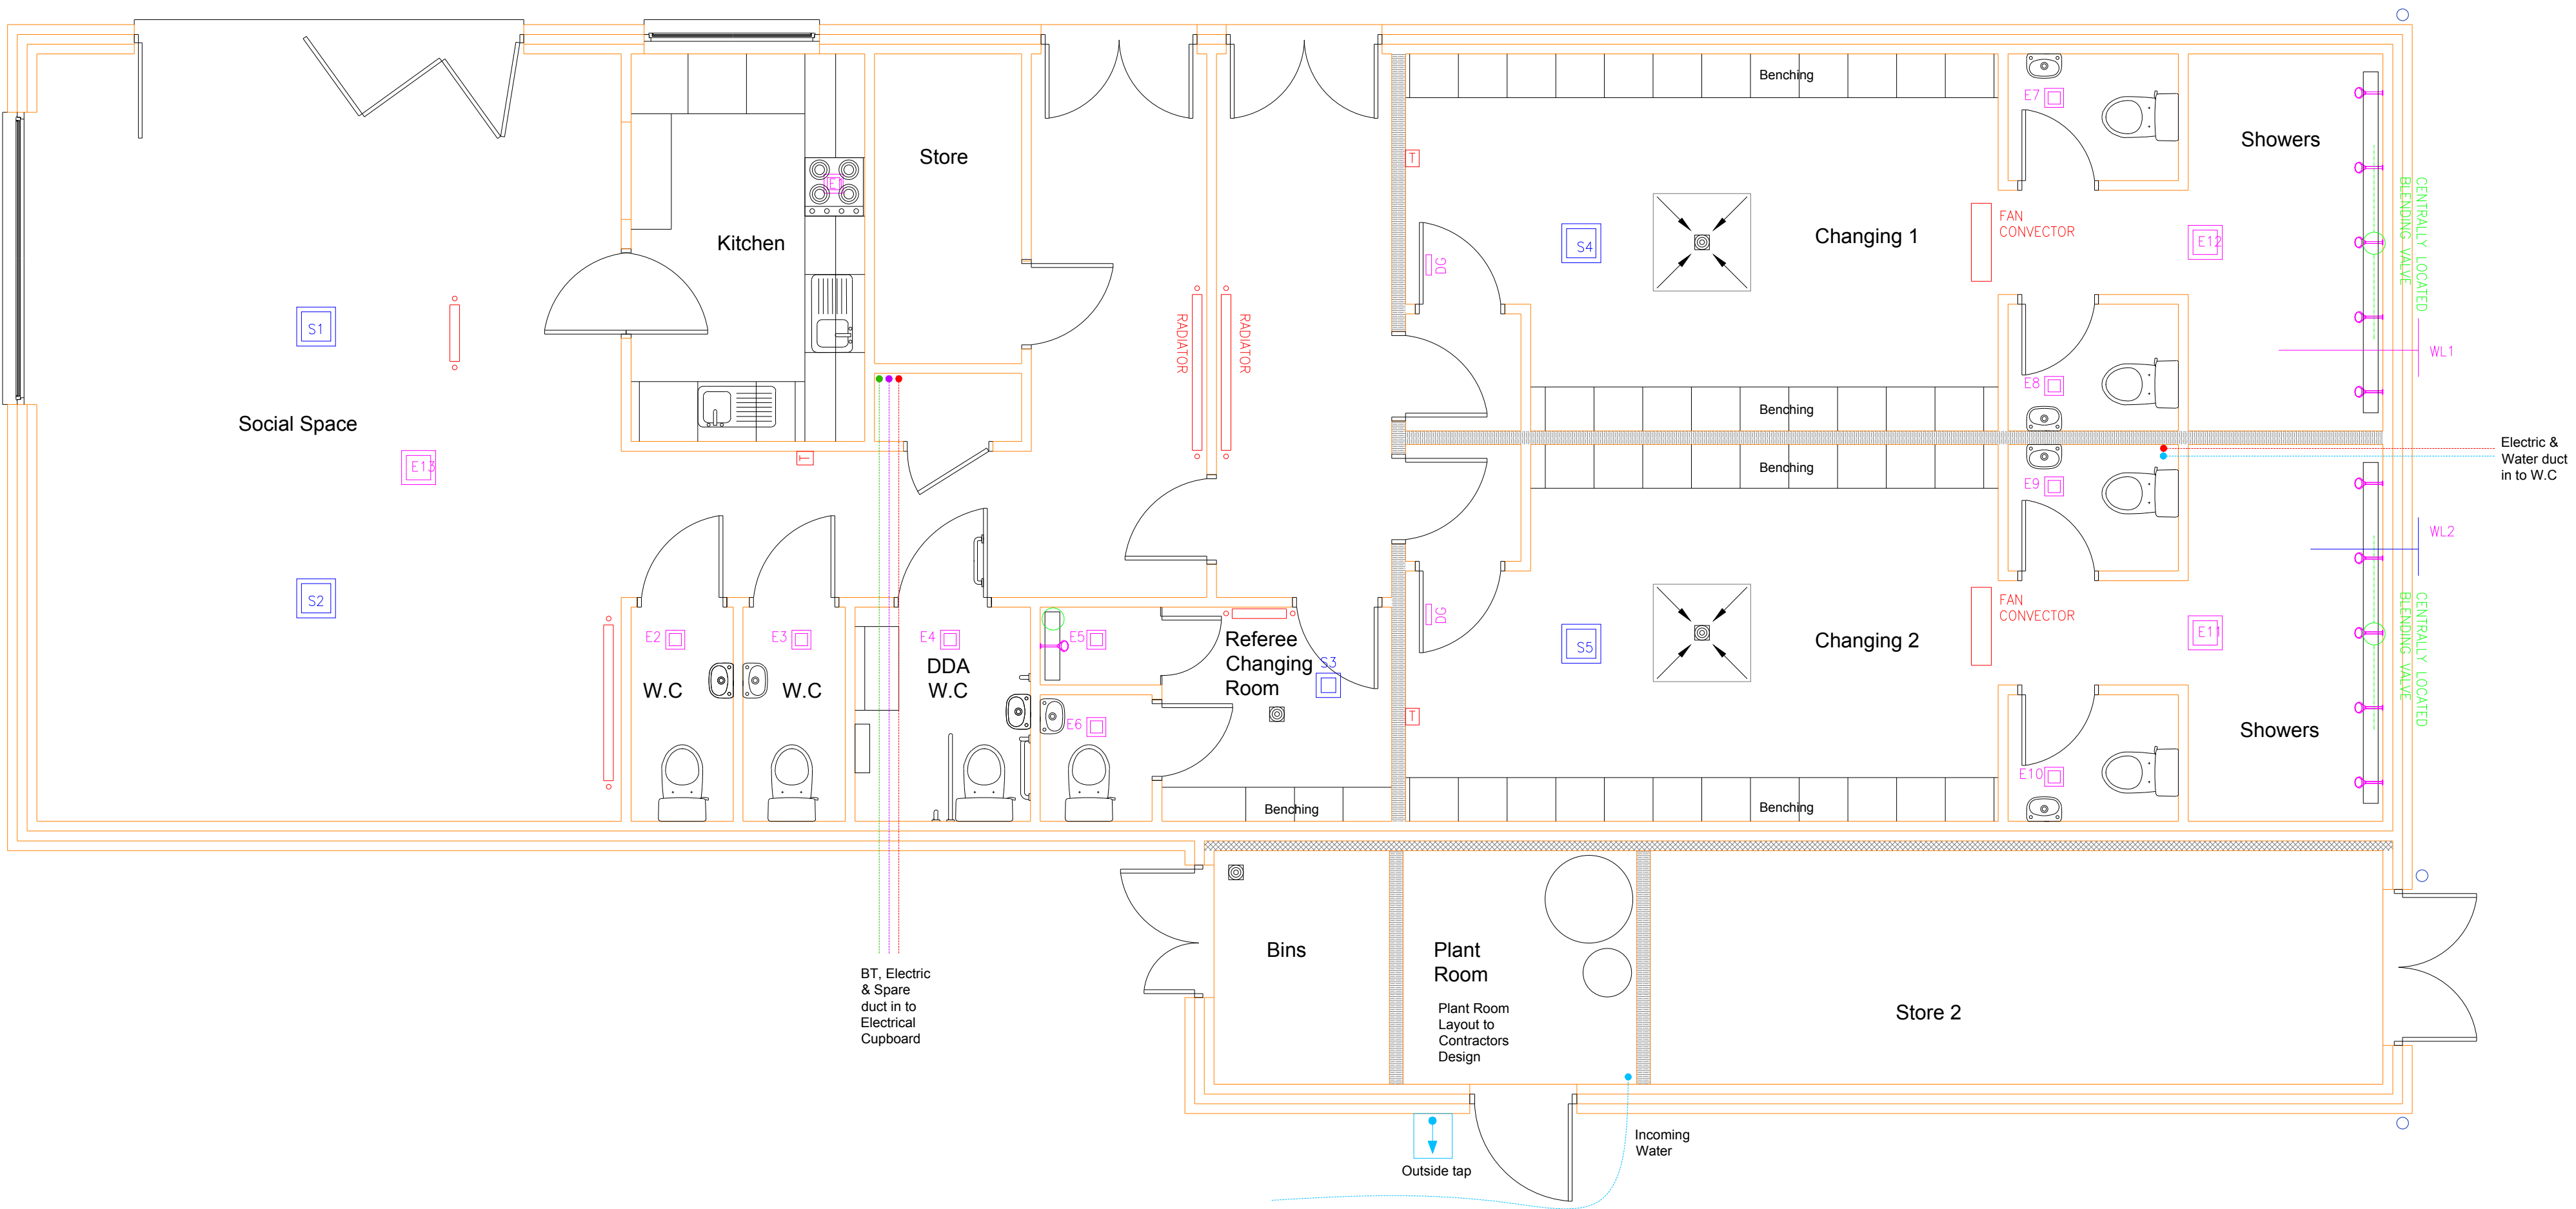




-  SUPPLY GRILLS
-  EXTRACT GRILLS
-  THERMOSTAT
-  BLENDING VALVE

Important

Any discrepancies are to be notified to the designer at once.

This drawing is subject to copyright and may not be copied or disclosed either wholly or in part without the written consent of Malvern Hills District Council .

The contractors is advised to visit site before tendering. The contractor shall be deemed to have satisfied himself before tendering, of the full nature and extent of the works involved,

REVISIONS				
Tender Issue				
Malvern Hills District Council				
Estates and Facilities				
TITLE Powick Playing Fields - Proposed Pavilion & Carpark Proposed Mechanical Plan				
© COPYRIGHT THIS DRAWING MAY NOT BE REPRODUCED OR COPIED				
CUSTOMER	Powick Parish Council	DRN	JRY	JOB No. 2034
SITE ADDRESS	Hamilton Close	DATE	Feb 20	DRG No.
Powick, WR2 4NH		SCALE	1:50	PC006
				A1