






WALL TYPES	
PROPOSED PARTITION WALL:	
30 Min FIRE RATED PARTITION:	
STRUCTURE:	
VOID :	

EXISTING DEMISE DIMENSION LEGEND		
INTERNAL AREA	30 M²	322 FT²
TOTAL AREAS	30 M²	322 FT²

DESIGN NOTES


 


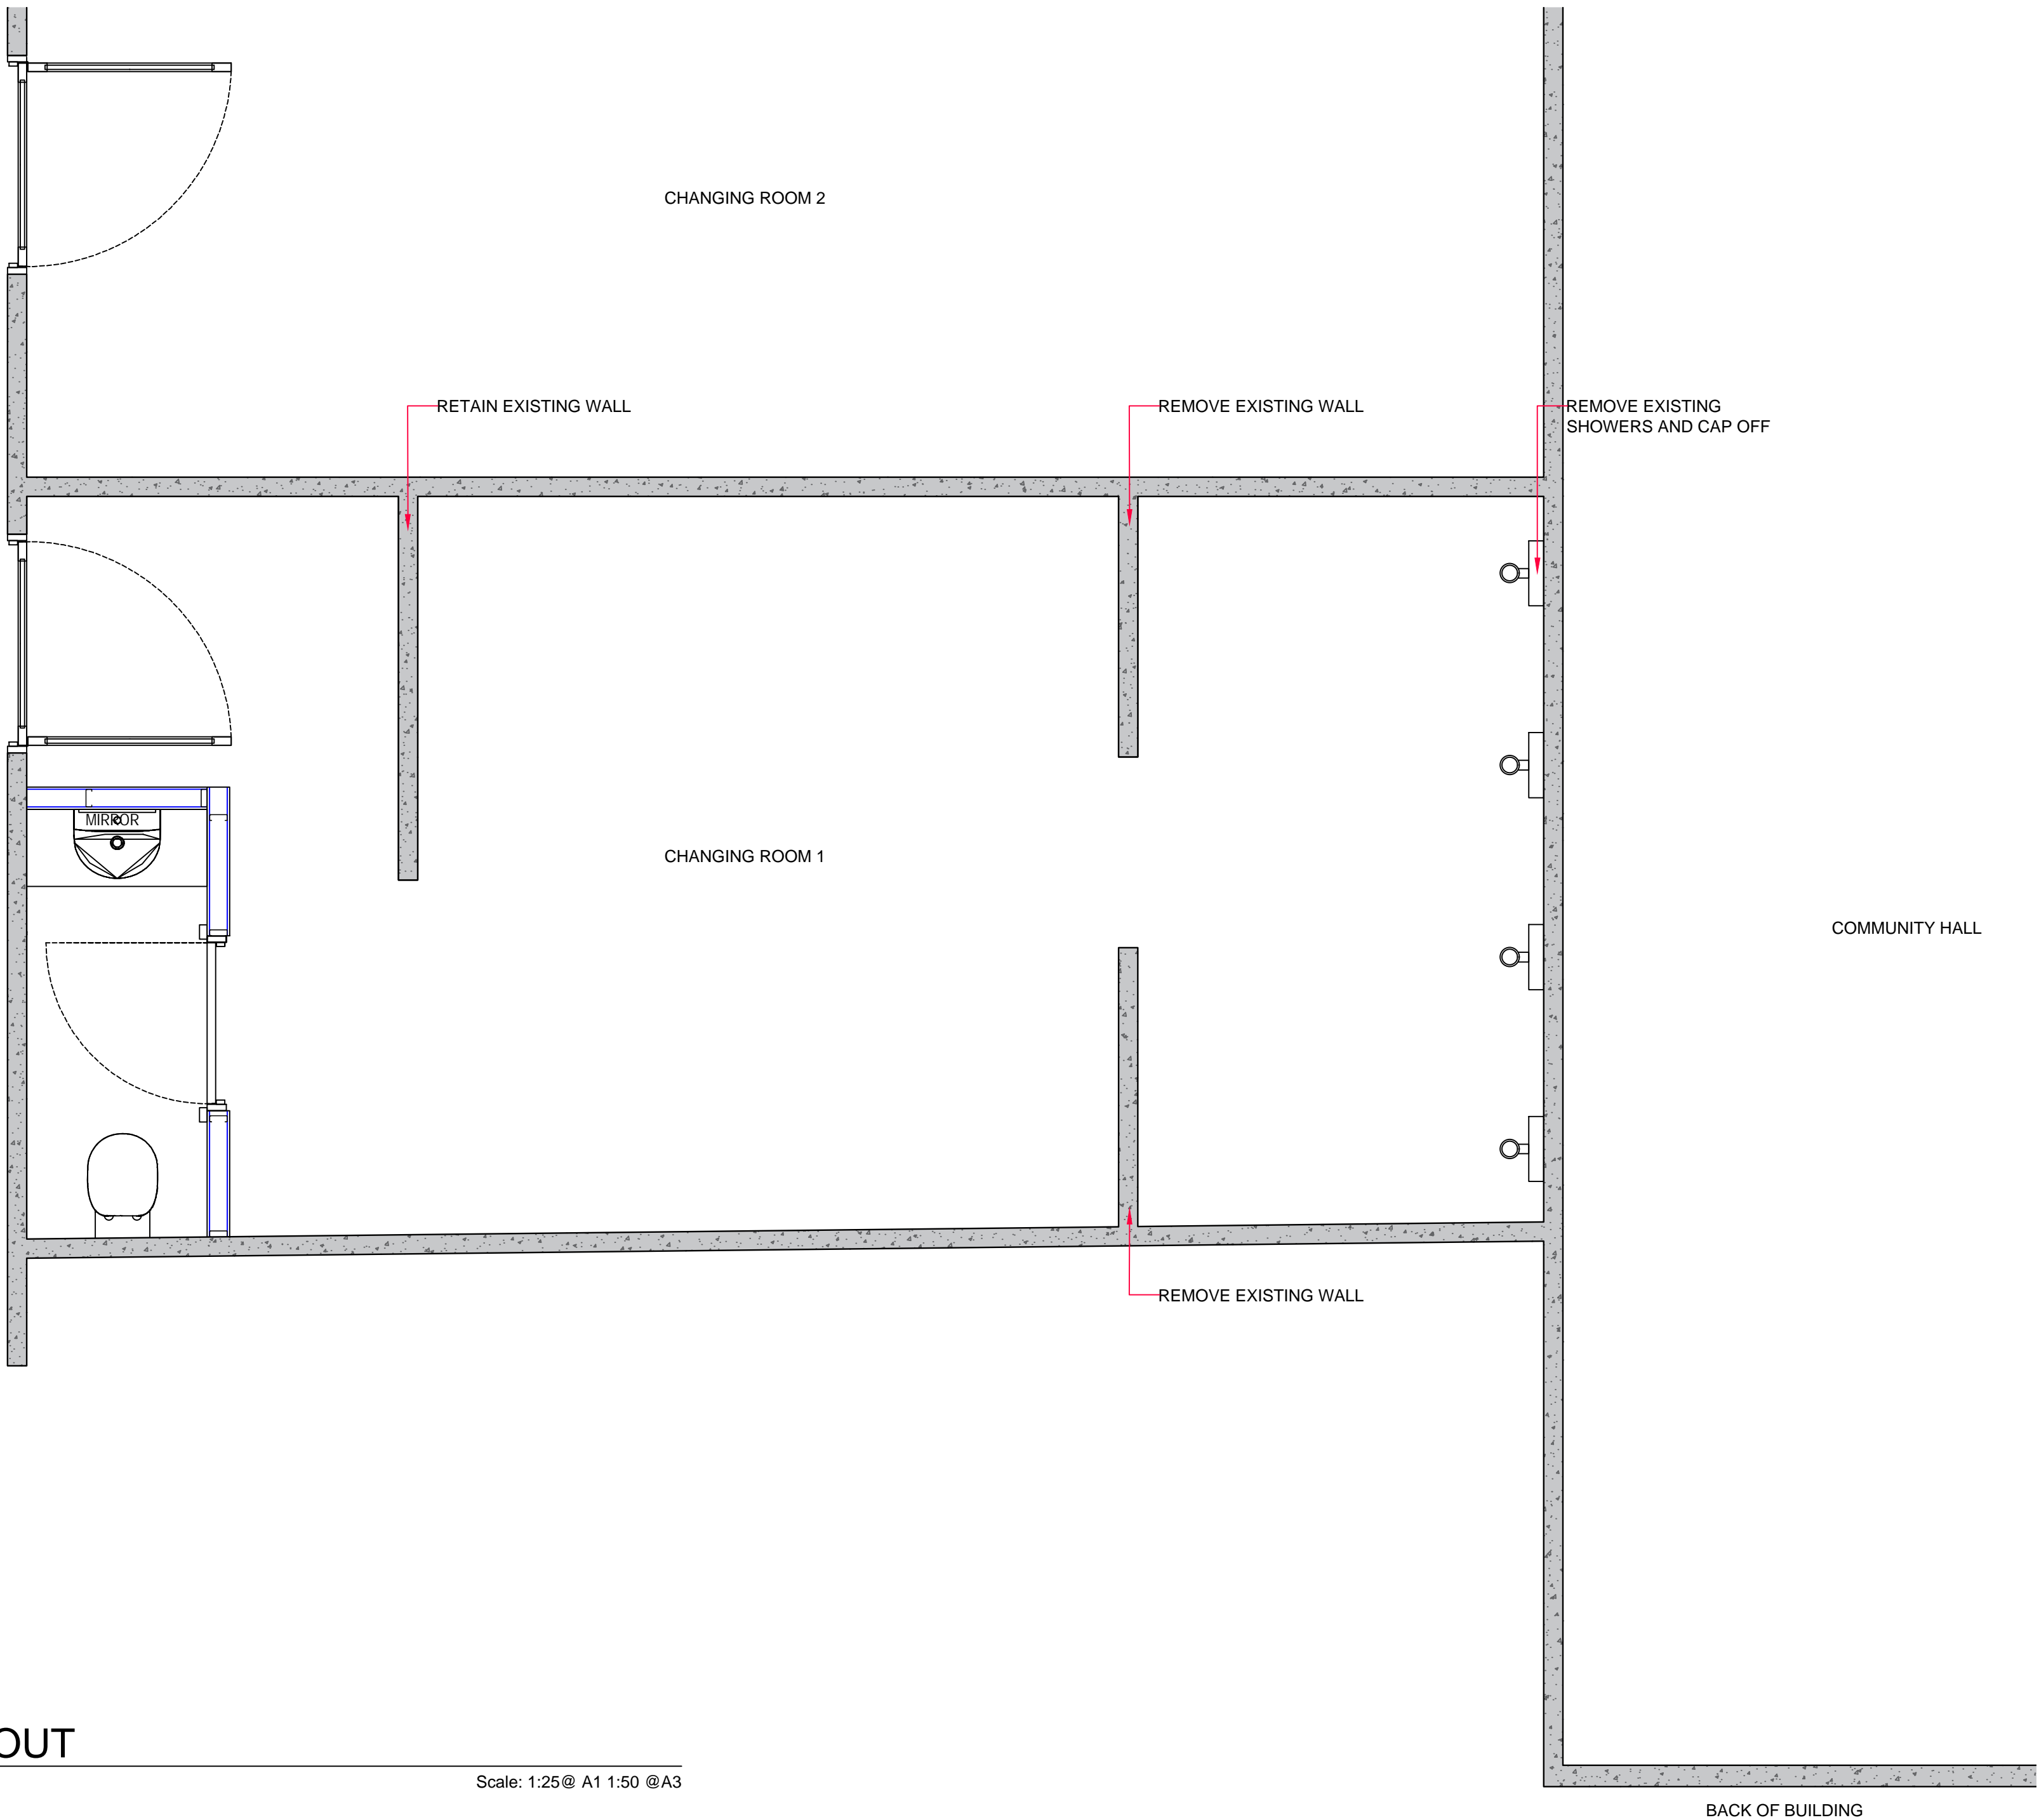REVISIONS:			
REVISION	COMMENTS	DATE ISSUED	DESIGNER
A	FIRST ISSUE	24.07.2019	JN



2 EXISTING GENERAL LAYOUT

Scale: 1:25@ A1 1:50 @A3


CLIENT:	
PROJECT: SHENLEY CHURCH END PARISH	
DRAWING TITLE: LANDLORD PROPOSED LAYOUT	
SCHEME: STORAGE TO OFFICE SPACE	
PROJECT NUMBER: 01	DWG DATE: 22.07.2019
PROJECT DESIGNER: J.NIGHTINGALE	PROJECT MANAGER: N/A
DRAWING CHECKING DATE :	CHECKED BY : BYJ
DRAWING NUMBER: DWG 1.0	REVISION: A

WALL TYPES	
PROPOSED PARTITION WALL:	
30 Min FIRE RATED PARTITION:	
STRUCTURE:	
VOID :	

EXISTING DEMISE DIMENSION LEGEND		
INTERNAL AREA	30 M²	322 FT²
TOTAL AREAS	30 M²	322 FT²

DESIGN NOTES

REVISIONS:			
REVISION	COMMENTS	DATE ISSUED	DESIGNER
A	FIRST ISSUE	24.07.2019	JN

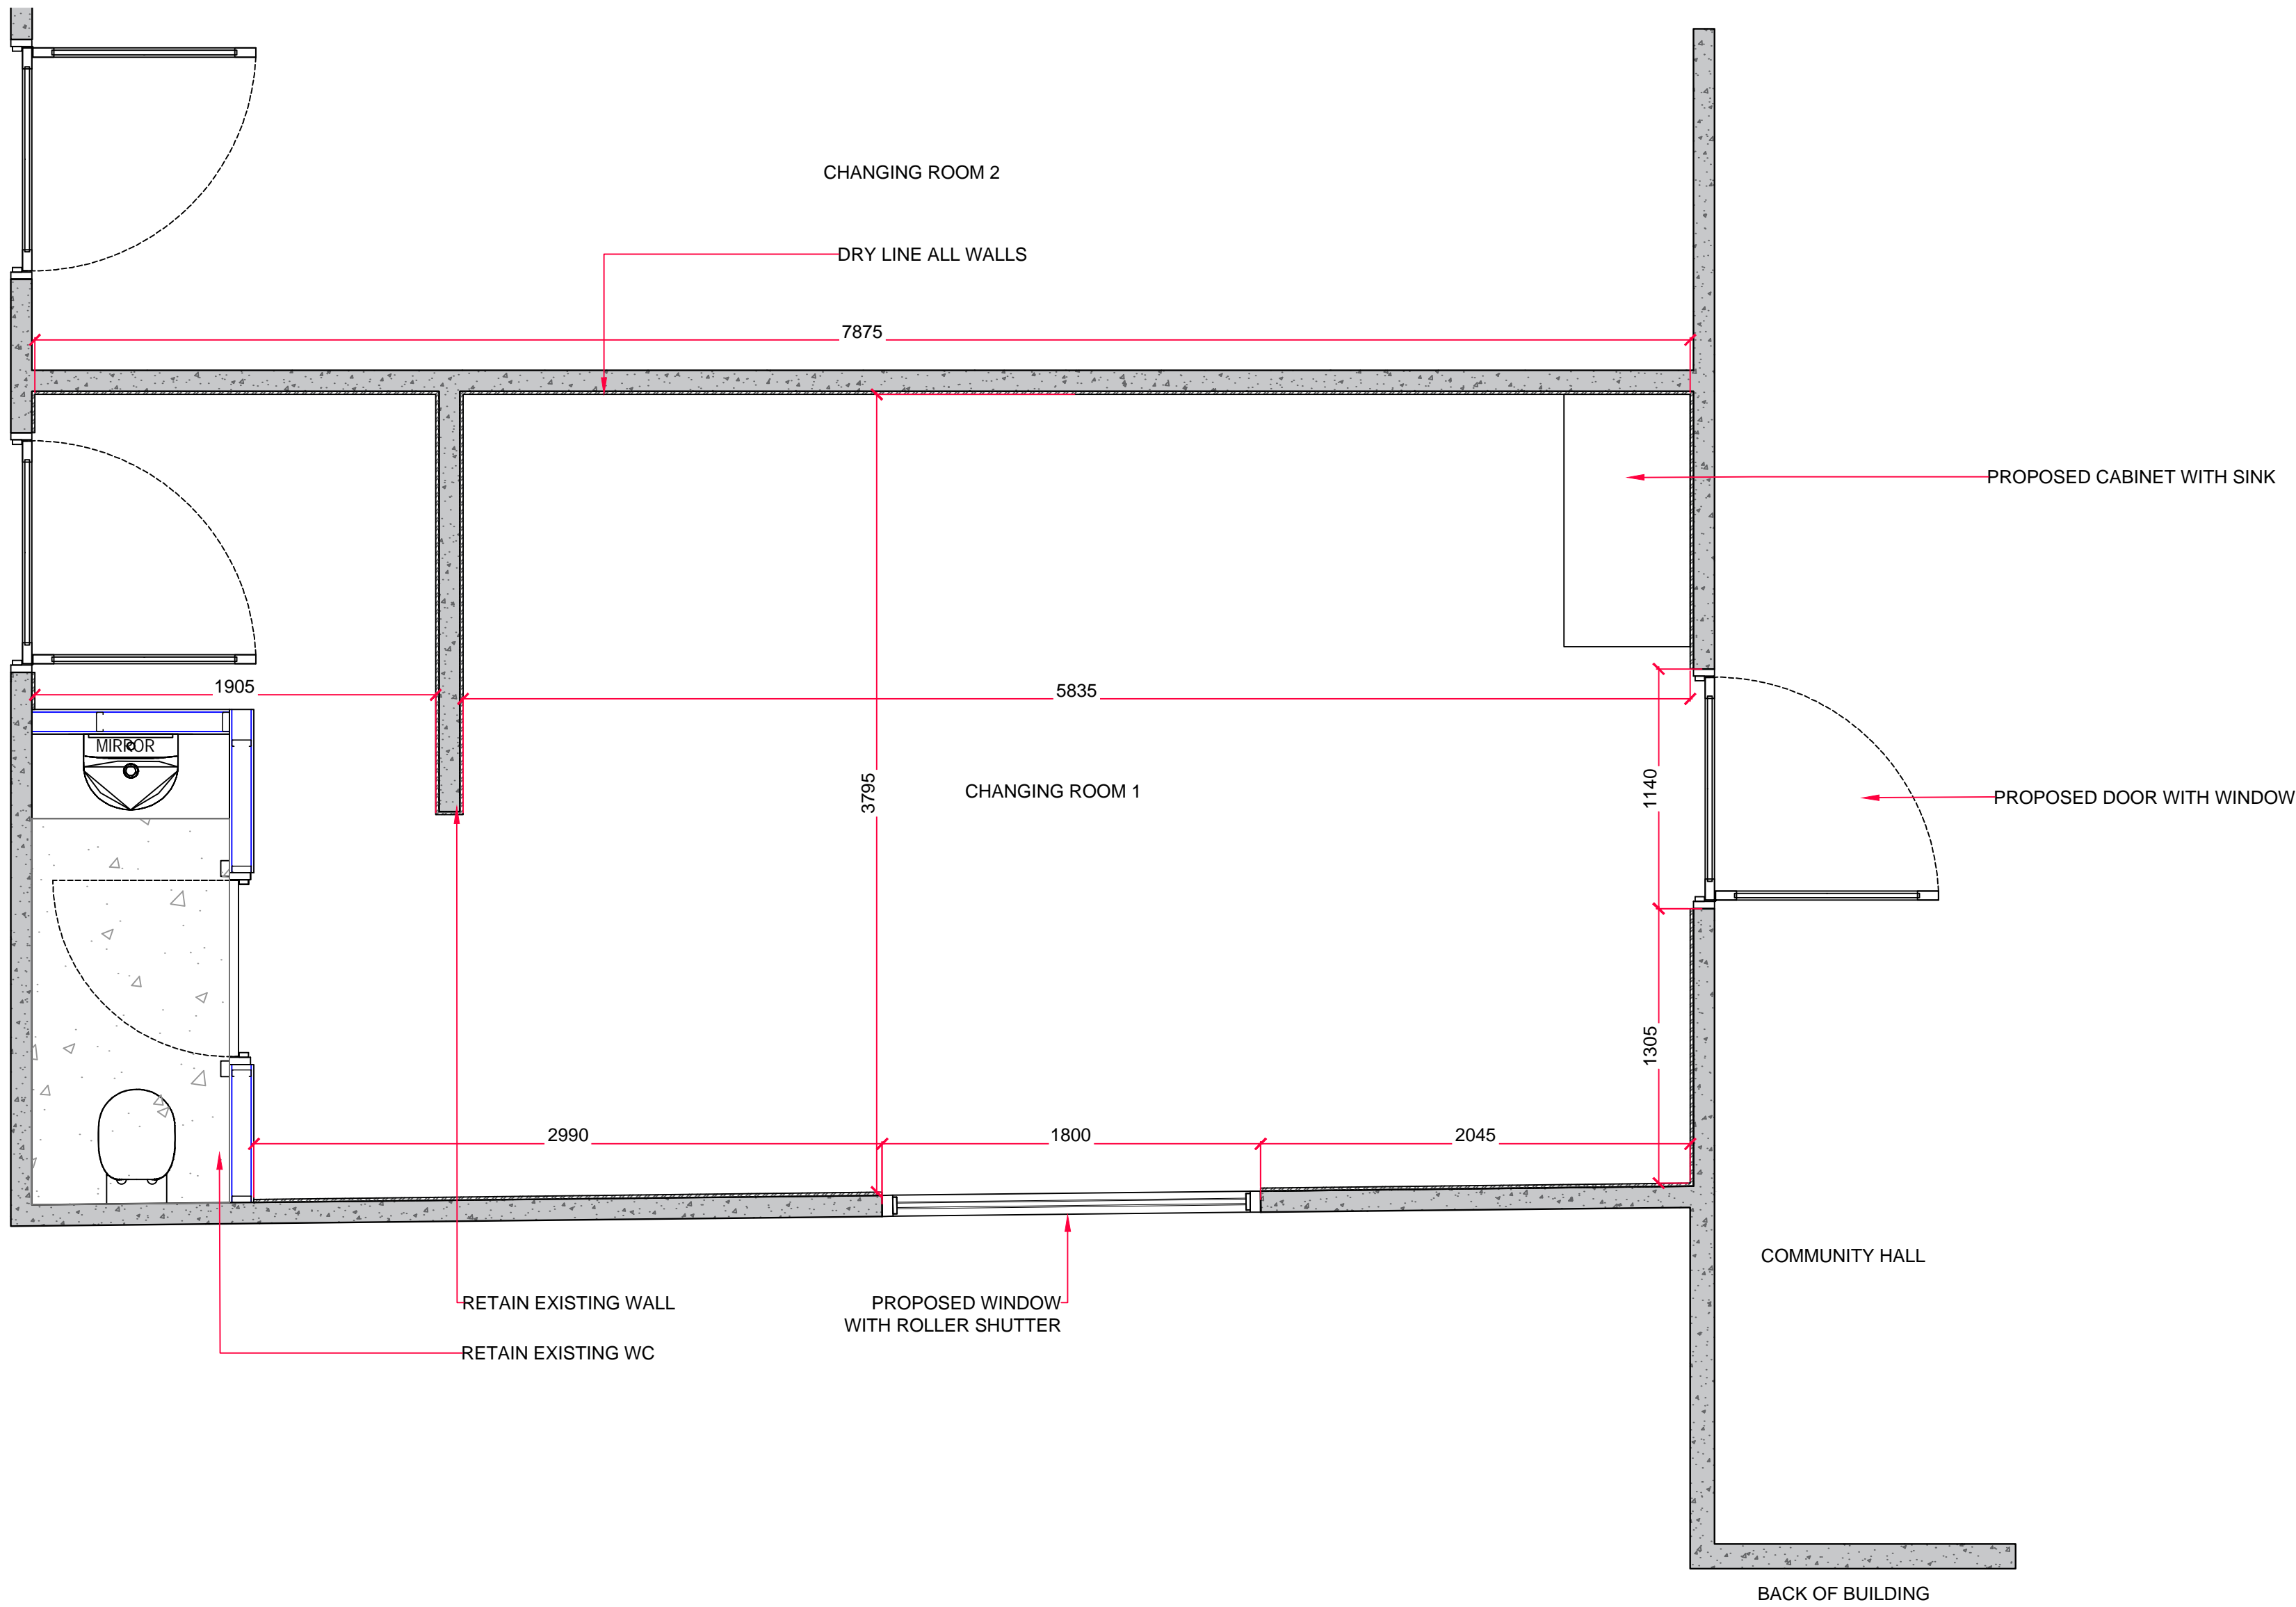





1

PROPOSED GENERAL LAYOUT

Scale: 1:25@ A1 1:50 @A3

CLIENT:	
PROJECT: SHENLEY CHURCH END PARISH	
DRAWING TITLE: PROPOSED GENERAL LAYOUT	
SCHEME: STORAGE TO OFFICE SPACE	
PROJECT NUMBER: 01	DWG DATE: 22.07.2019
PROJECT DESIGNER: JN	PROJECT MANAGER: N/A
DRAWING CHECKING DATE :	CHECKED BY : BYJ
DRAWING NUMBER: DWG 2.0	REVISION: A

 
ELECTRICAL LEGEND	
TYPE	DESCRIPTION
13LL	LOW LEVEL 13 AMP KNIGHTSBRIDGE SCREWLESS 13AMP 2 GANG SWITCHED SOCKET WITH DUAL USB CHARGER BRUSHED CHROME WITH BLACK INSERT SF9902BC
13CS	BELOW COUNTER 13 AMP TSSO CLEAN SUPPLY - RED FINISH
13BC	BELOW COUNTER 13 AMP TSSO - WHITE FINISH
32BC	BELOW COUNTER 32 AMP SINGLE PHASE ISOLATOR - WHITE FINIISH
13HL	HIGH LEVEL 13 AMP TSSO - STAINLESS STEEL FINISH
13AC	ABOVE COUNTER 13 AMP TSSO - STAINLESS STEEL FINISH
13LLR	LOW LEVEL 13 AMP TSSO IN RETAIL AREA - STAINLESS STEEL FINISH
20DW	20 AMP 3 PHASE DISHWASHER SUPPLY - WHITE FINISH
32DW	32 AMP 3 PHASE DISHWASHER SUPPLY - WHITE FINISH

WALL TYPES	
PROPOSED PARTITION WALL:	
30 Min FIRE RATED PARTITION:	
STRUCTURE:	
VOID :	

EXISTING DEMISE DIMENSION LEGEND		
INTERNAL AREA	30 M²	322 FT²
TOTAL AREAS	30 M²	322 FT²

DESIGN NOTES


REVISIONS:			
REVISION	COMMENTS	DATE ISSUED	DESIGNER
A	FIRST ISSUE	24.07.2019	JN

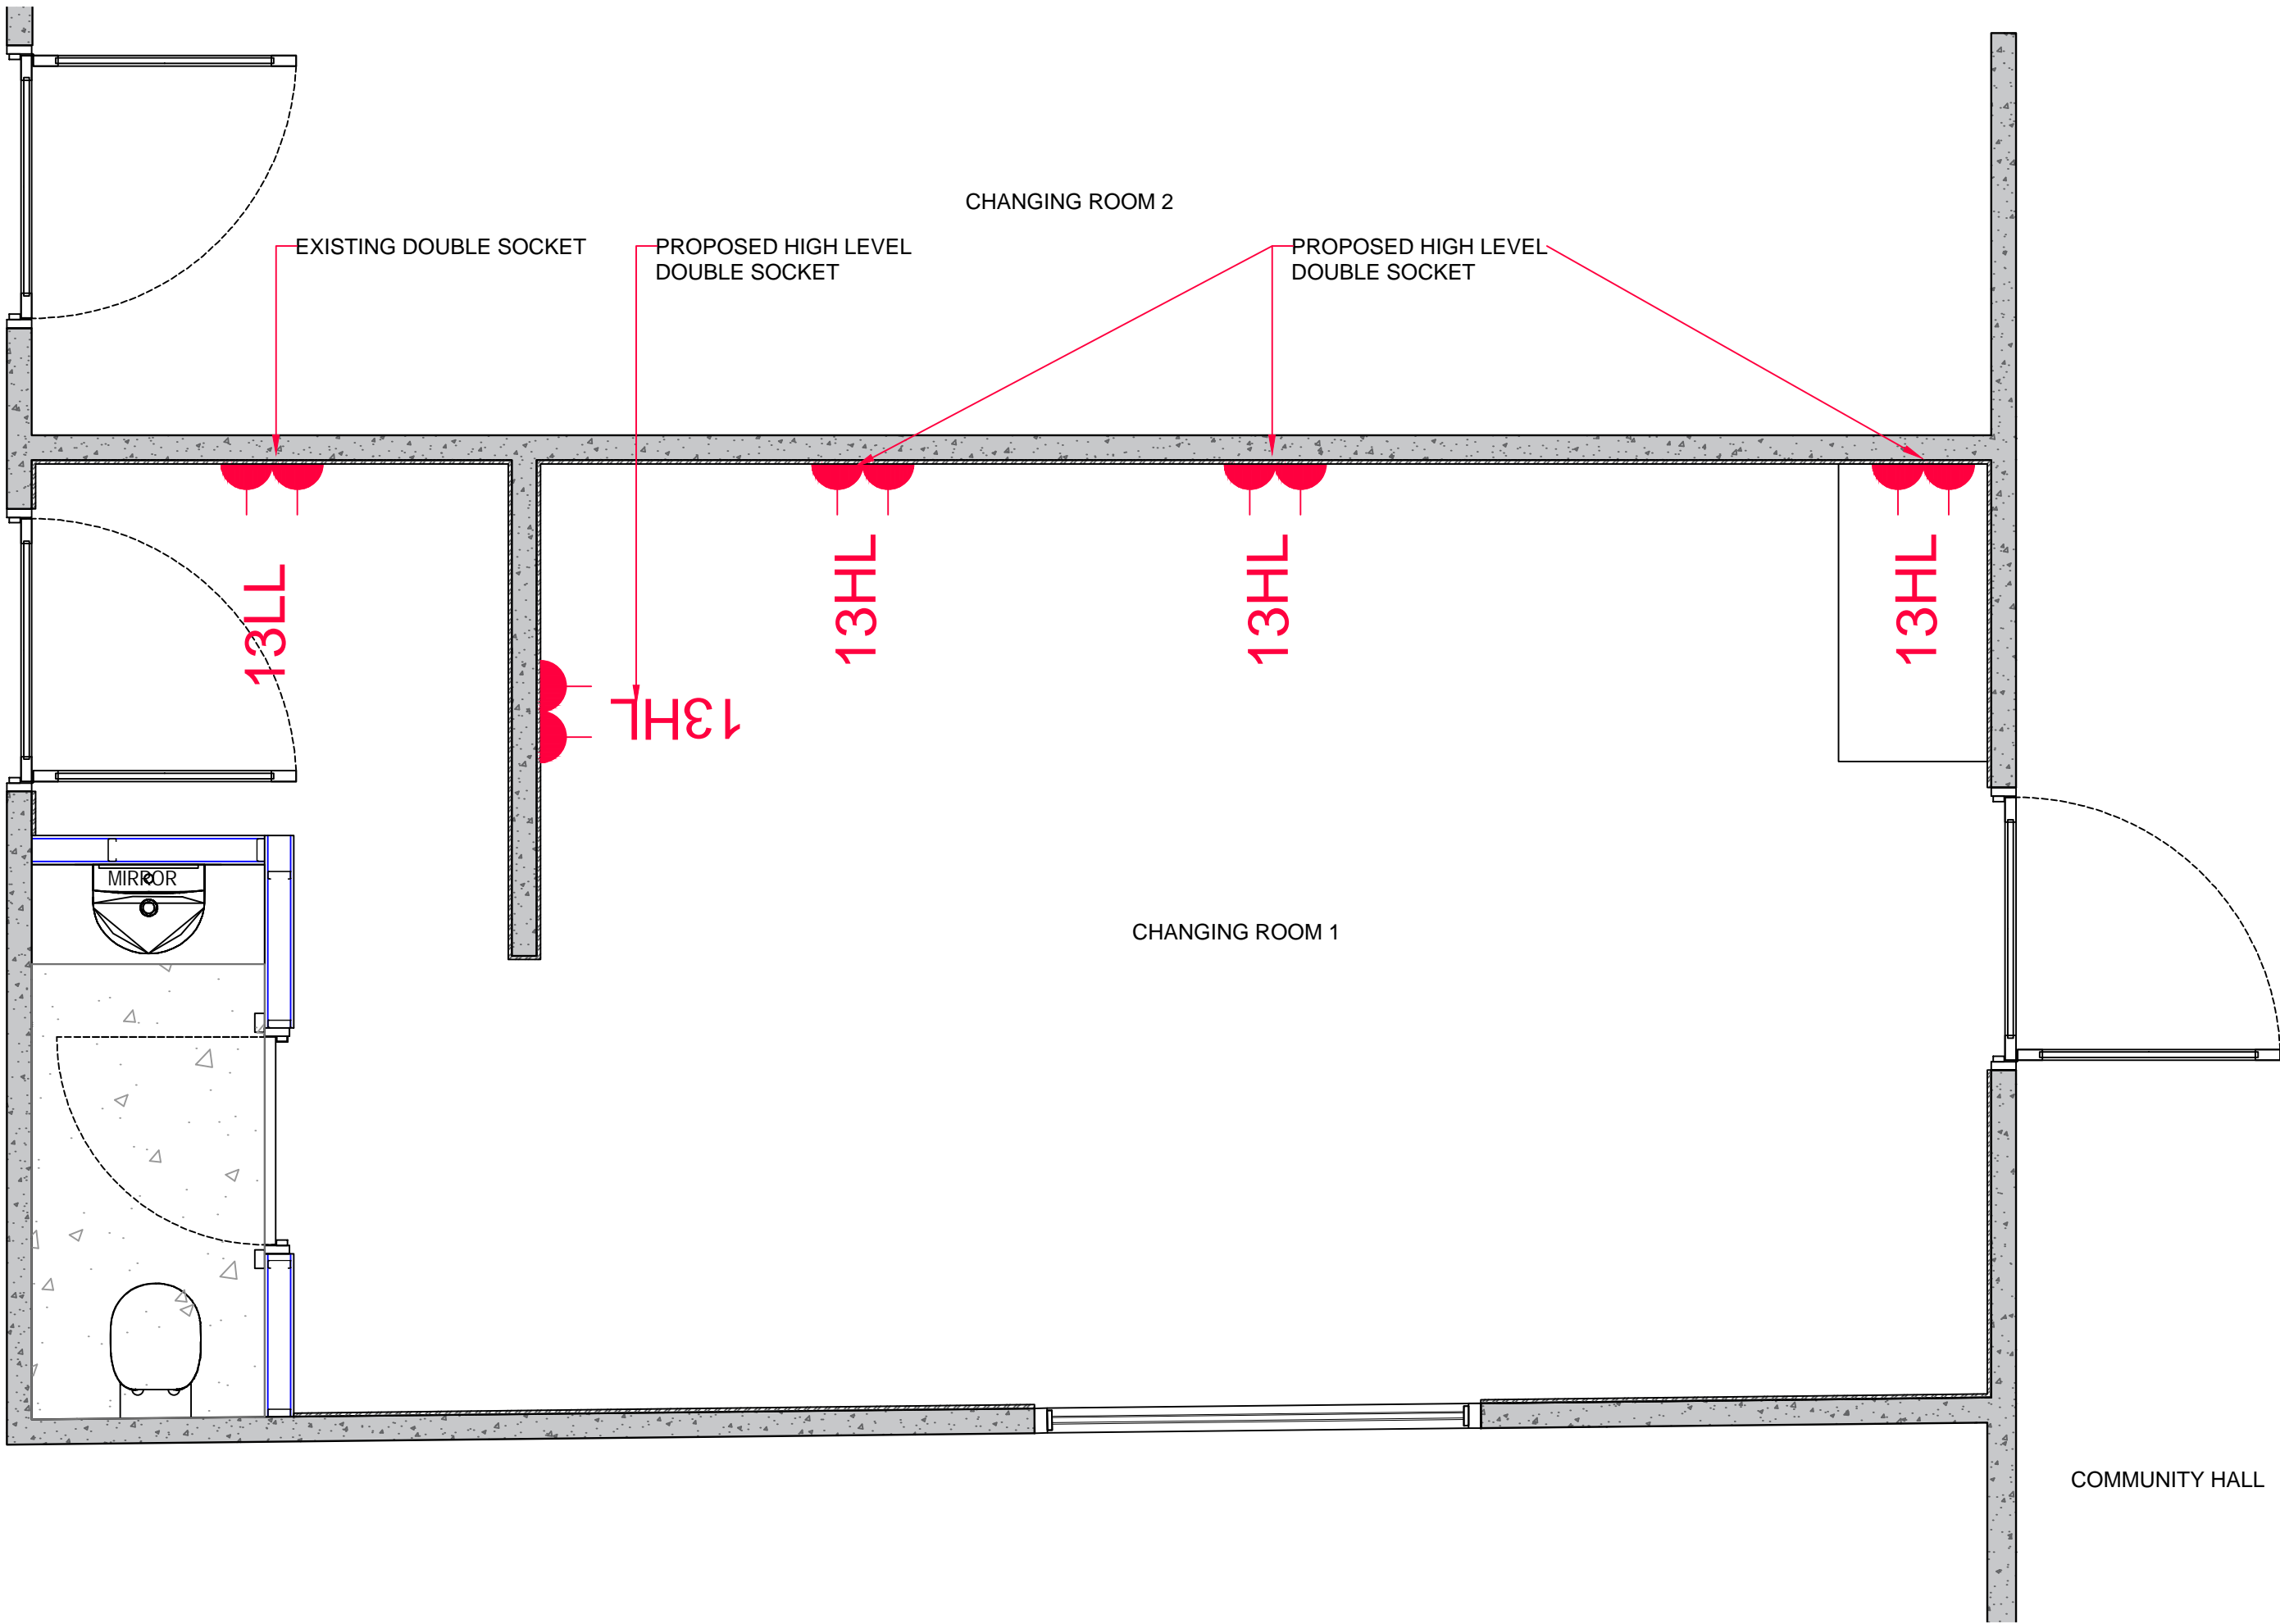

1 PROPOSED ELECTRICAL LAYOUT

Scale: 1:25 @ A1 1:50 @A3

CLIENT:	
PROJECT: SHENLEY CHURCH END PARISH	
DRAWING TITLE: PROPOSED ELECTRICAL LAYOUT	
SCHEME: STORAGE TO OFFICE SPACE	
PROJECT NUMBER: 01	DWG DATE: 22.07.2019
PROJECT DESIGNER: JN	PROJECT MANAGER: N/A
DRAWING CHECKING DATE :	CHECKED BY : BYJ
DRAWING NUMBER: DWG 3.0	REVISION: A

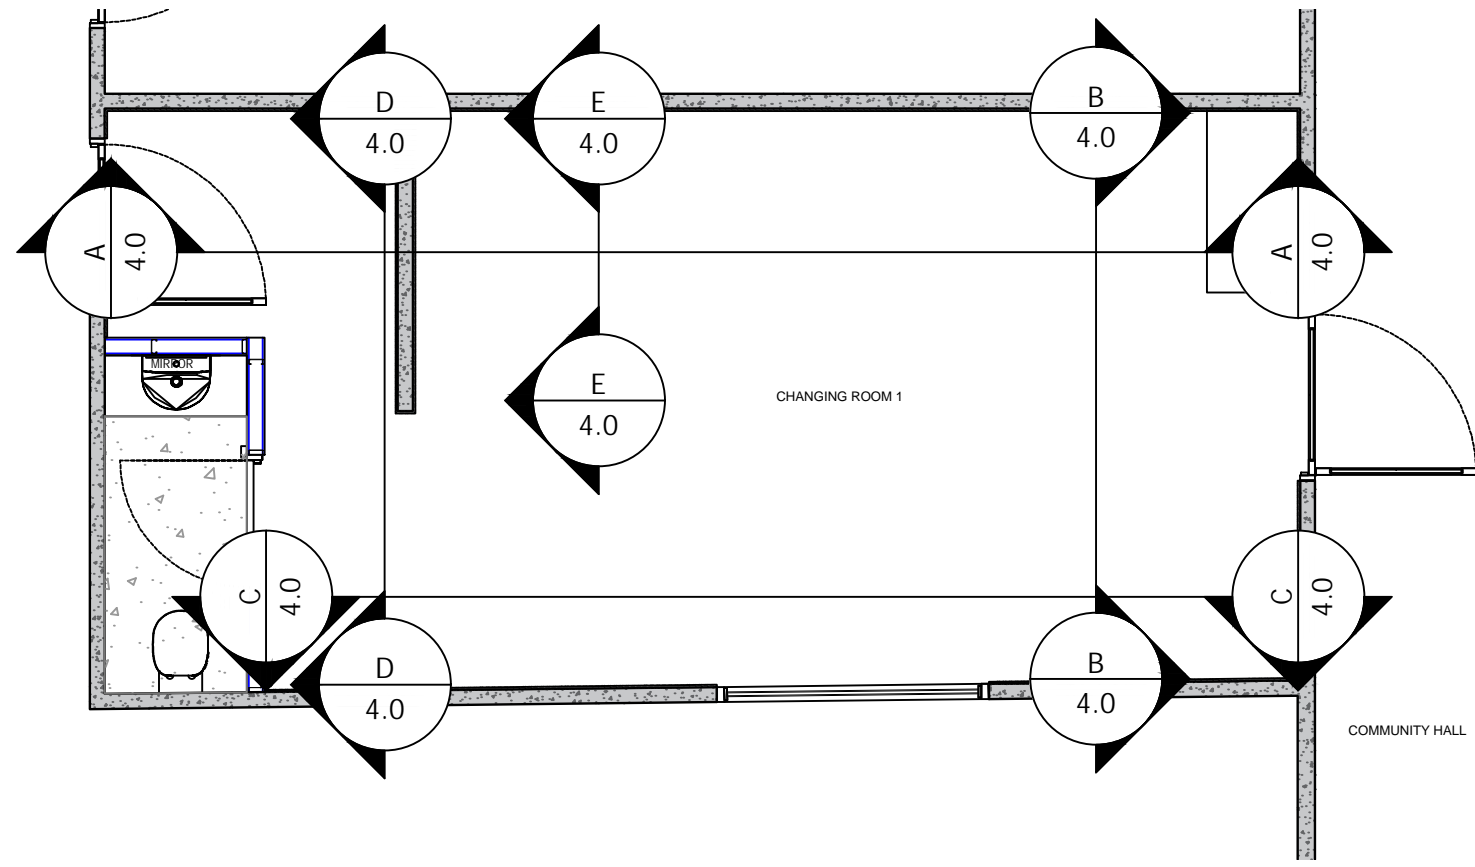


1 KEY - ELEVATION PLAN
Scale: 1:50 @ A1 1:100 @ A3


DESIGN NOTES

ARTWORKS TO BE IN CONJUNCTION WITH
MANUAL 1.5 APRIL 2019 19 ISSUE


REVISIONS:			
REVISION	COMMENTS	DATE ISSUED	DESIGNER
A			

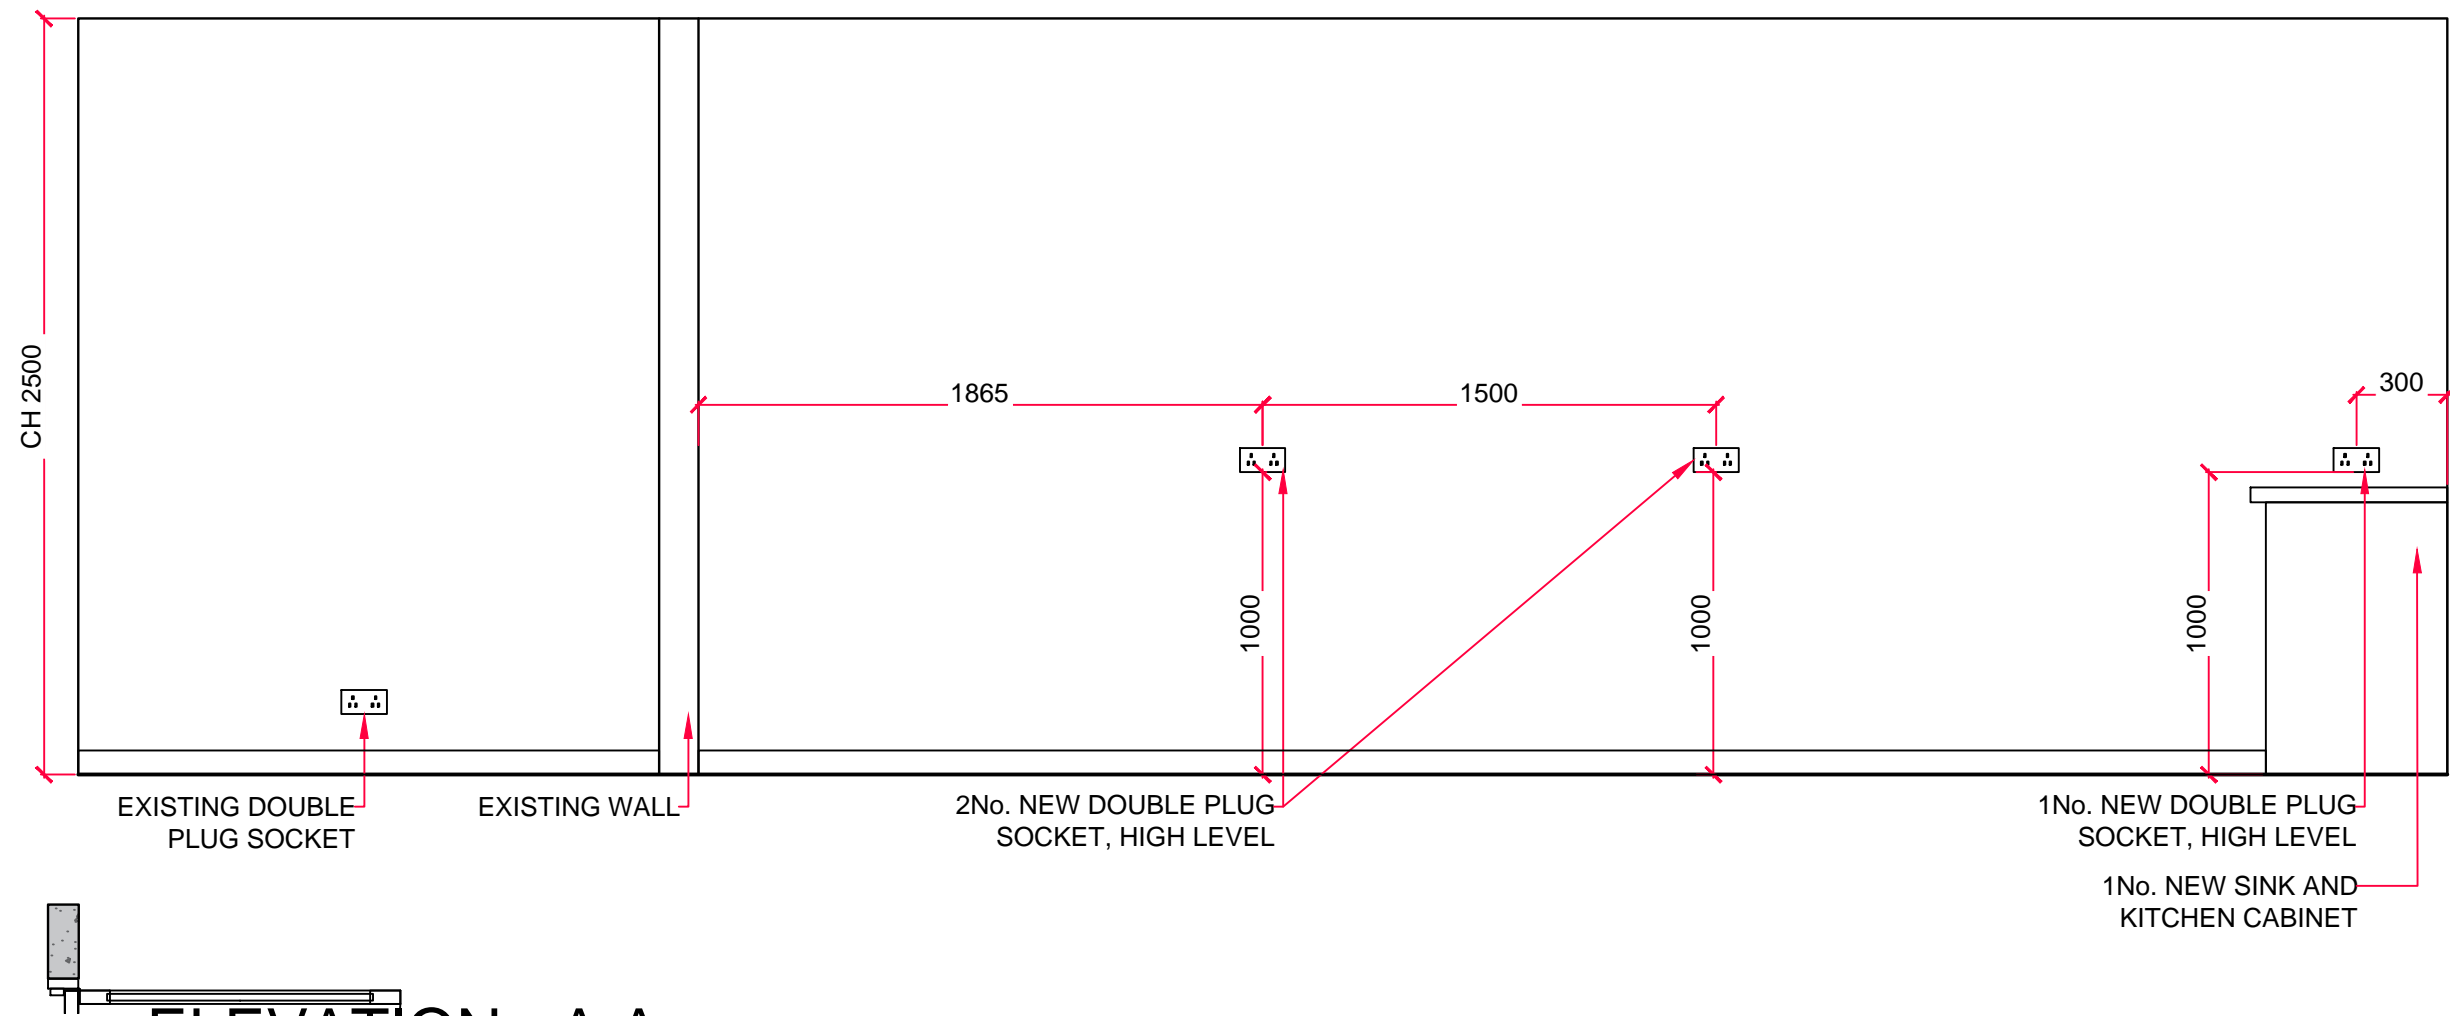


3 ELEVATION - A A
Scale: 1:25 @ A1 1:50 @ A3

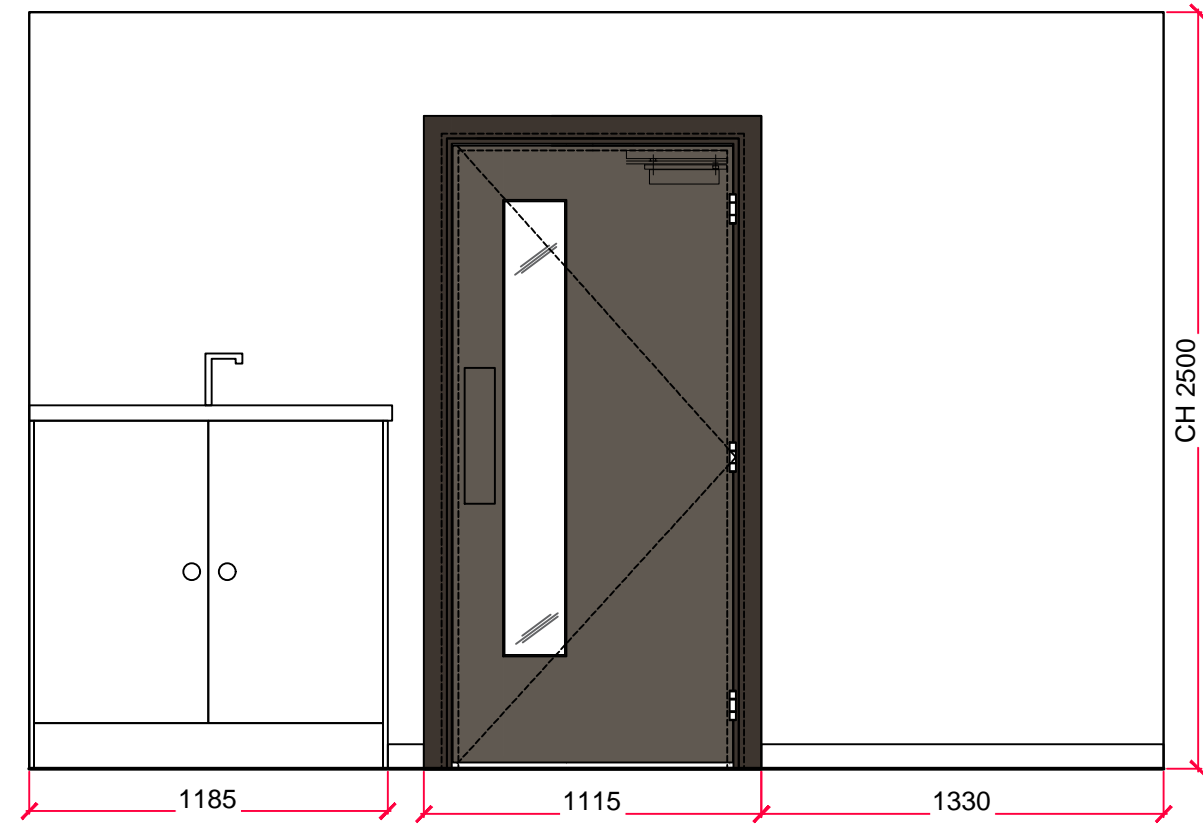


3 ELEVATION - B B
Scale: 1:25 @ A1 1:50 @ A3

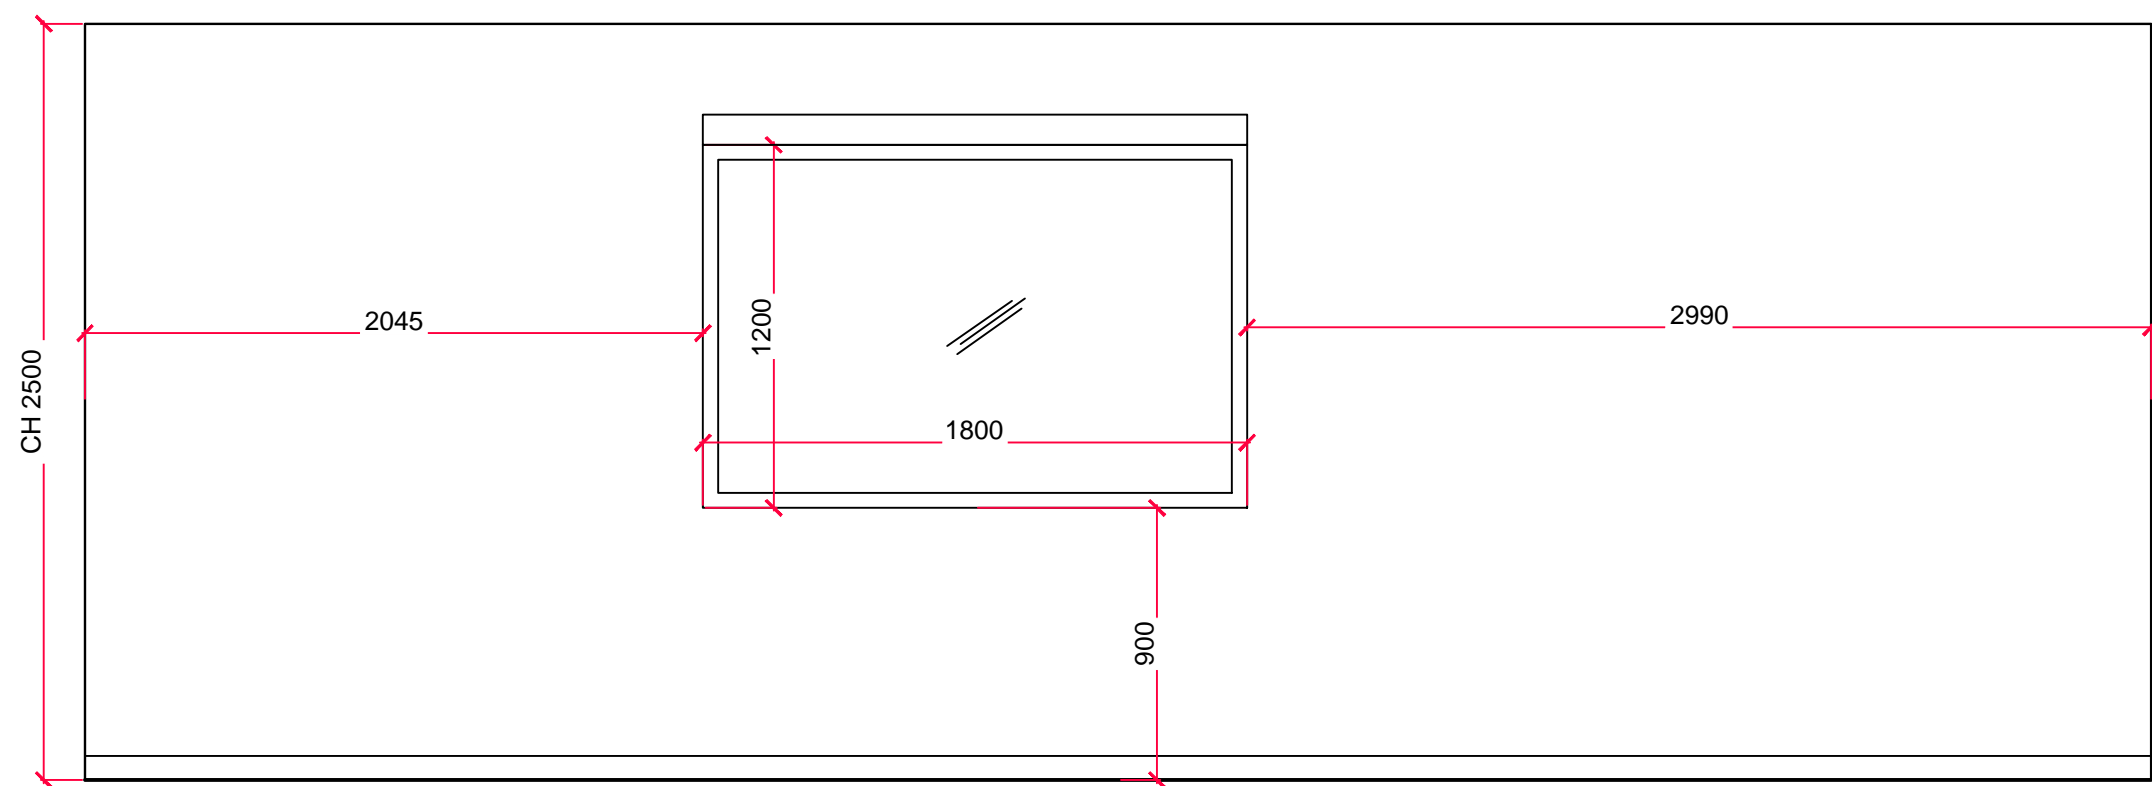

3 ELEVATION - C C
Scale: 1:25 @ A1 1:50 @ A3

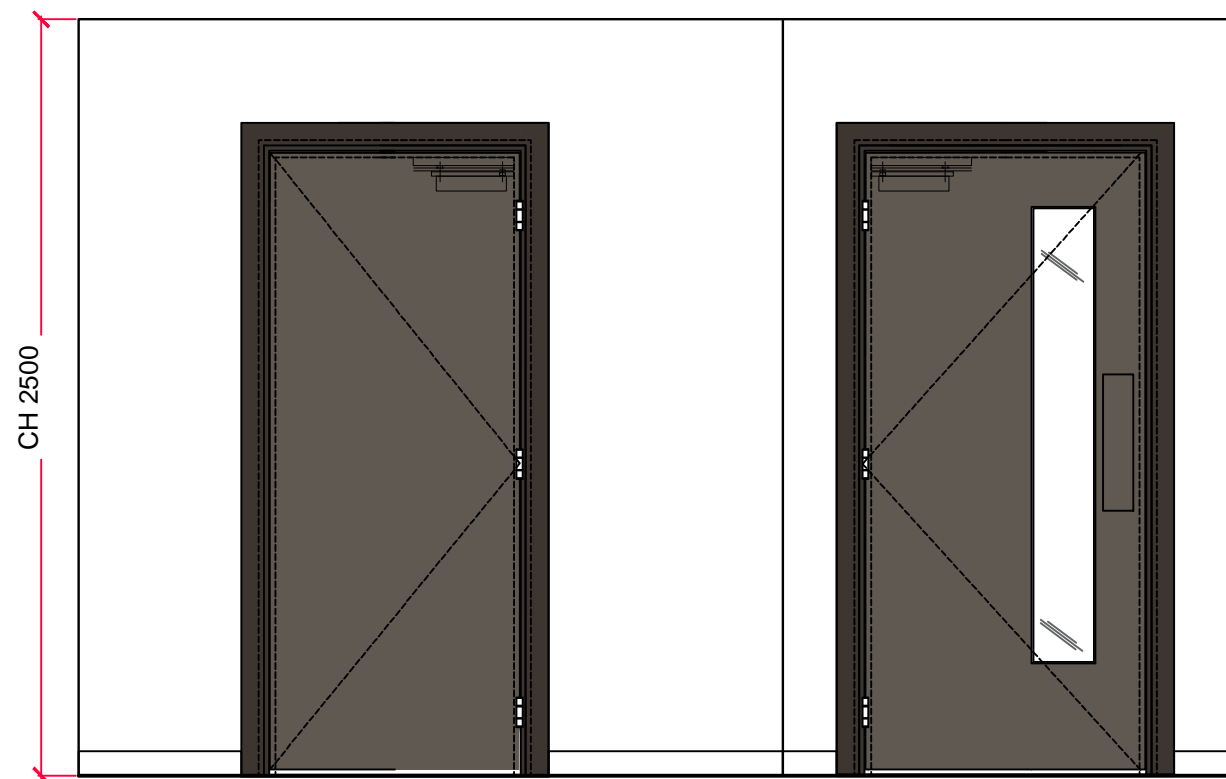

3 ELEVATION - D D
Scale: 1:25 @ A1 1:50 @ A3

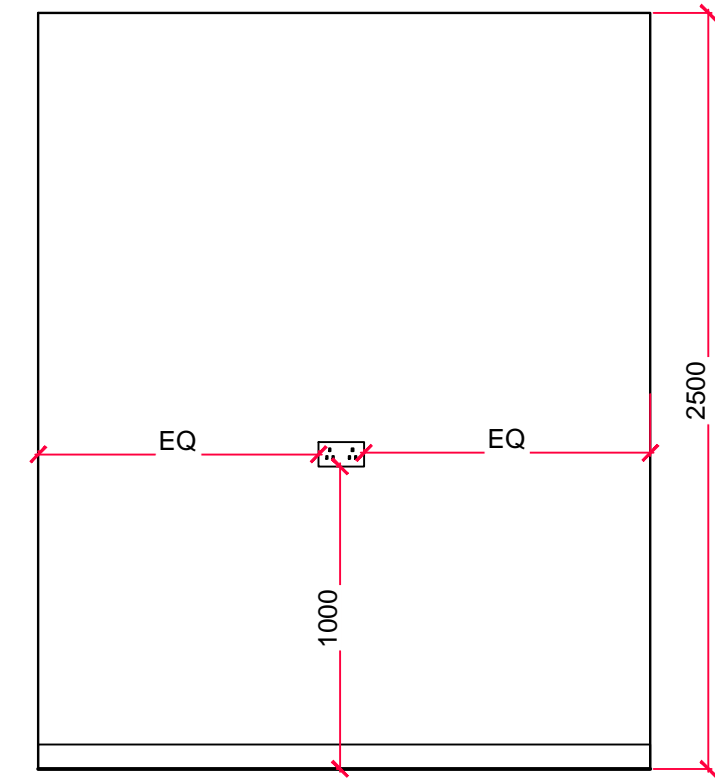

3 ELEVATION - E E
Scale: 1:25 @ A1 1:50 @ A3

CLIENT:

PROJECT:
SHENLEY CHURCH END PARISH

DRAWING TITLE:
PROPOSED INTERNAL ELEVATION 1

SCHEME:
STORAGE TO OFFICE SPACE

PROJECT NUMBER:
01

PROJECT DESIGNER:
JN

DRAWING CHECKING DATE :
CHECKED BY :
BYJ

DRAWING NUMBER:
DWG 4.0

REVISION:
A