


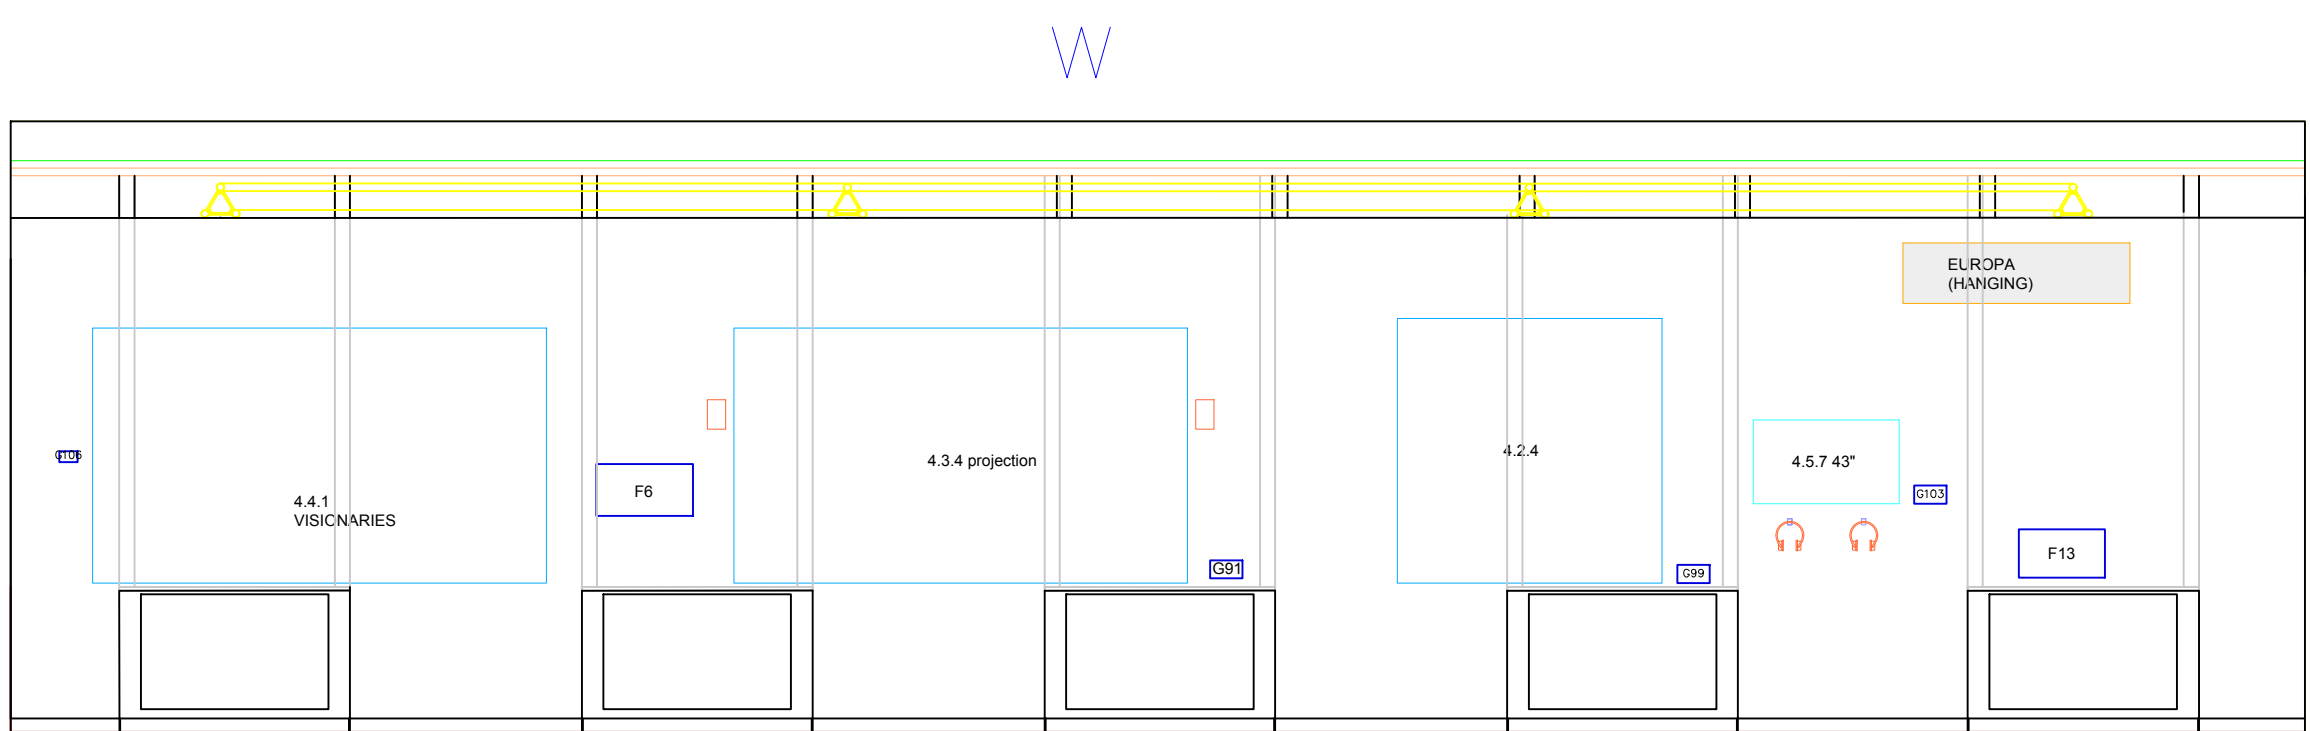


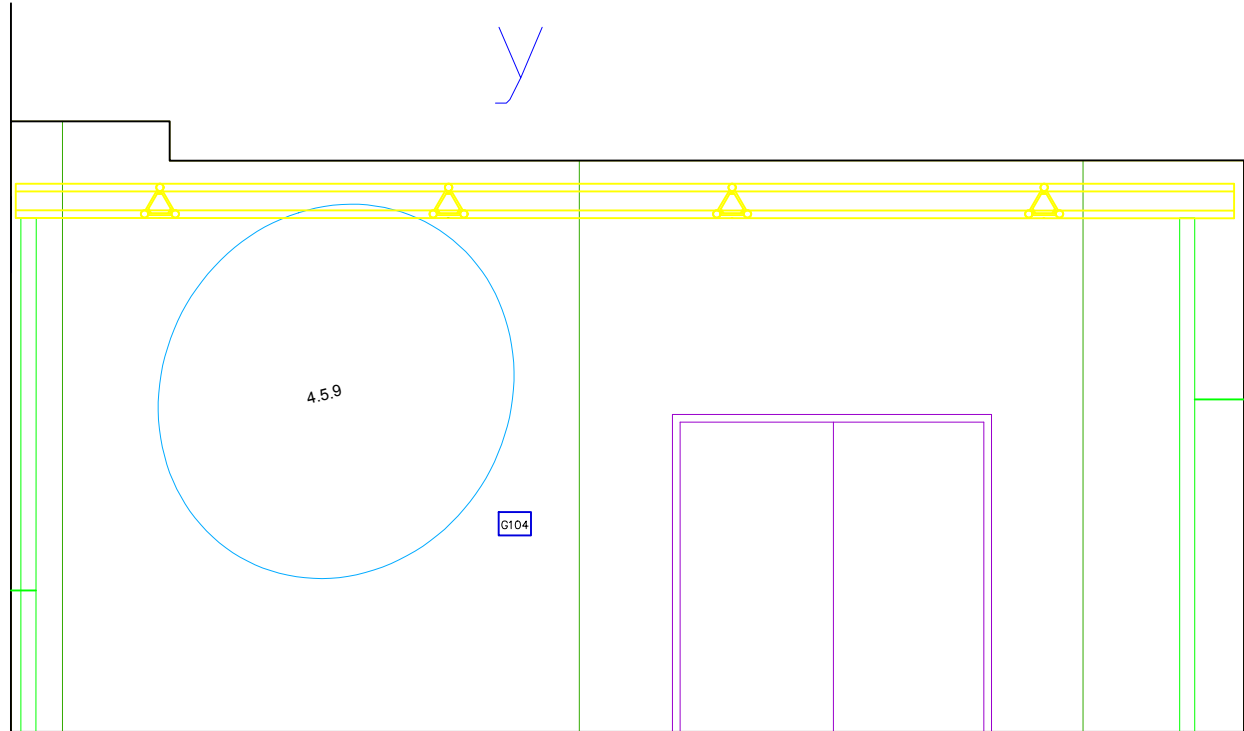


Side View

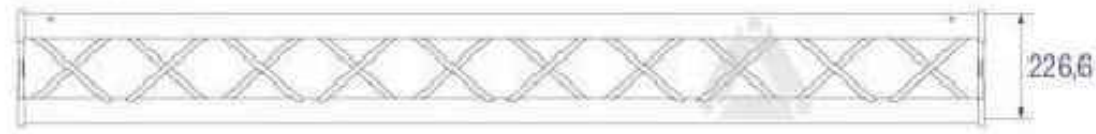

Front View

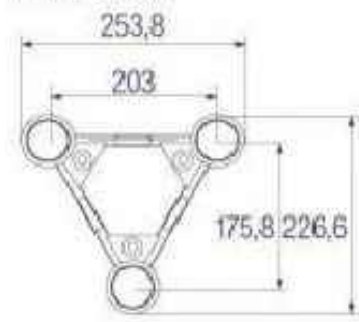

Proposal to use Astralite
*To be calculated and
approved by others

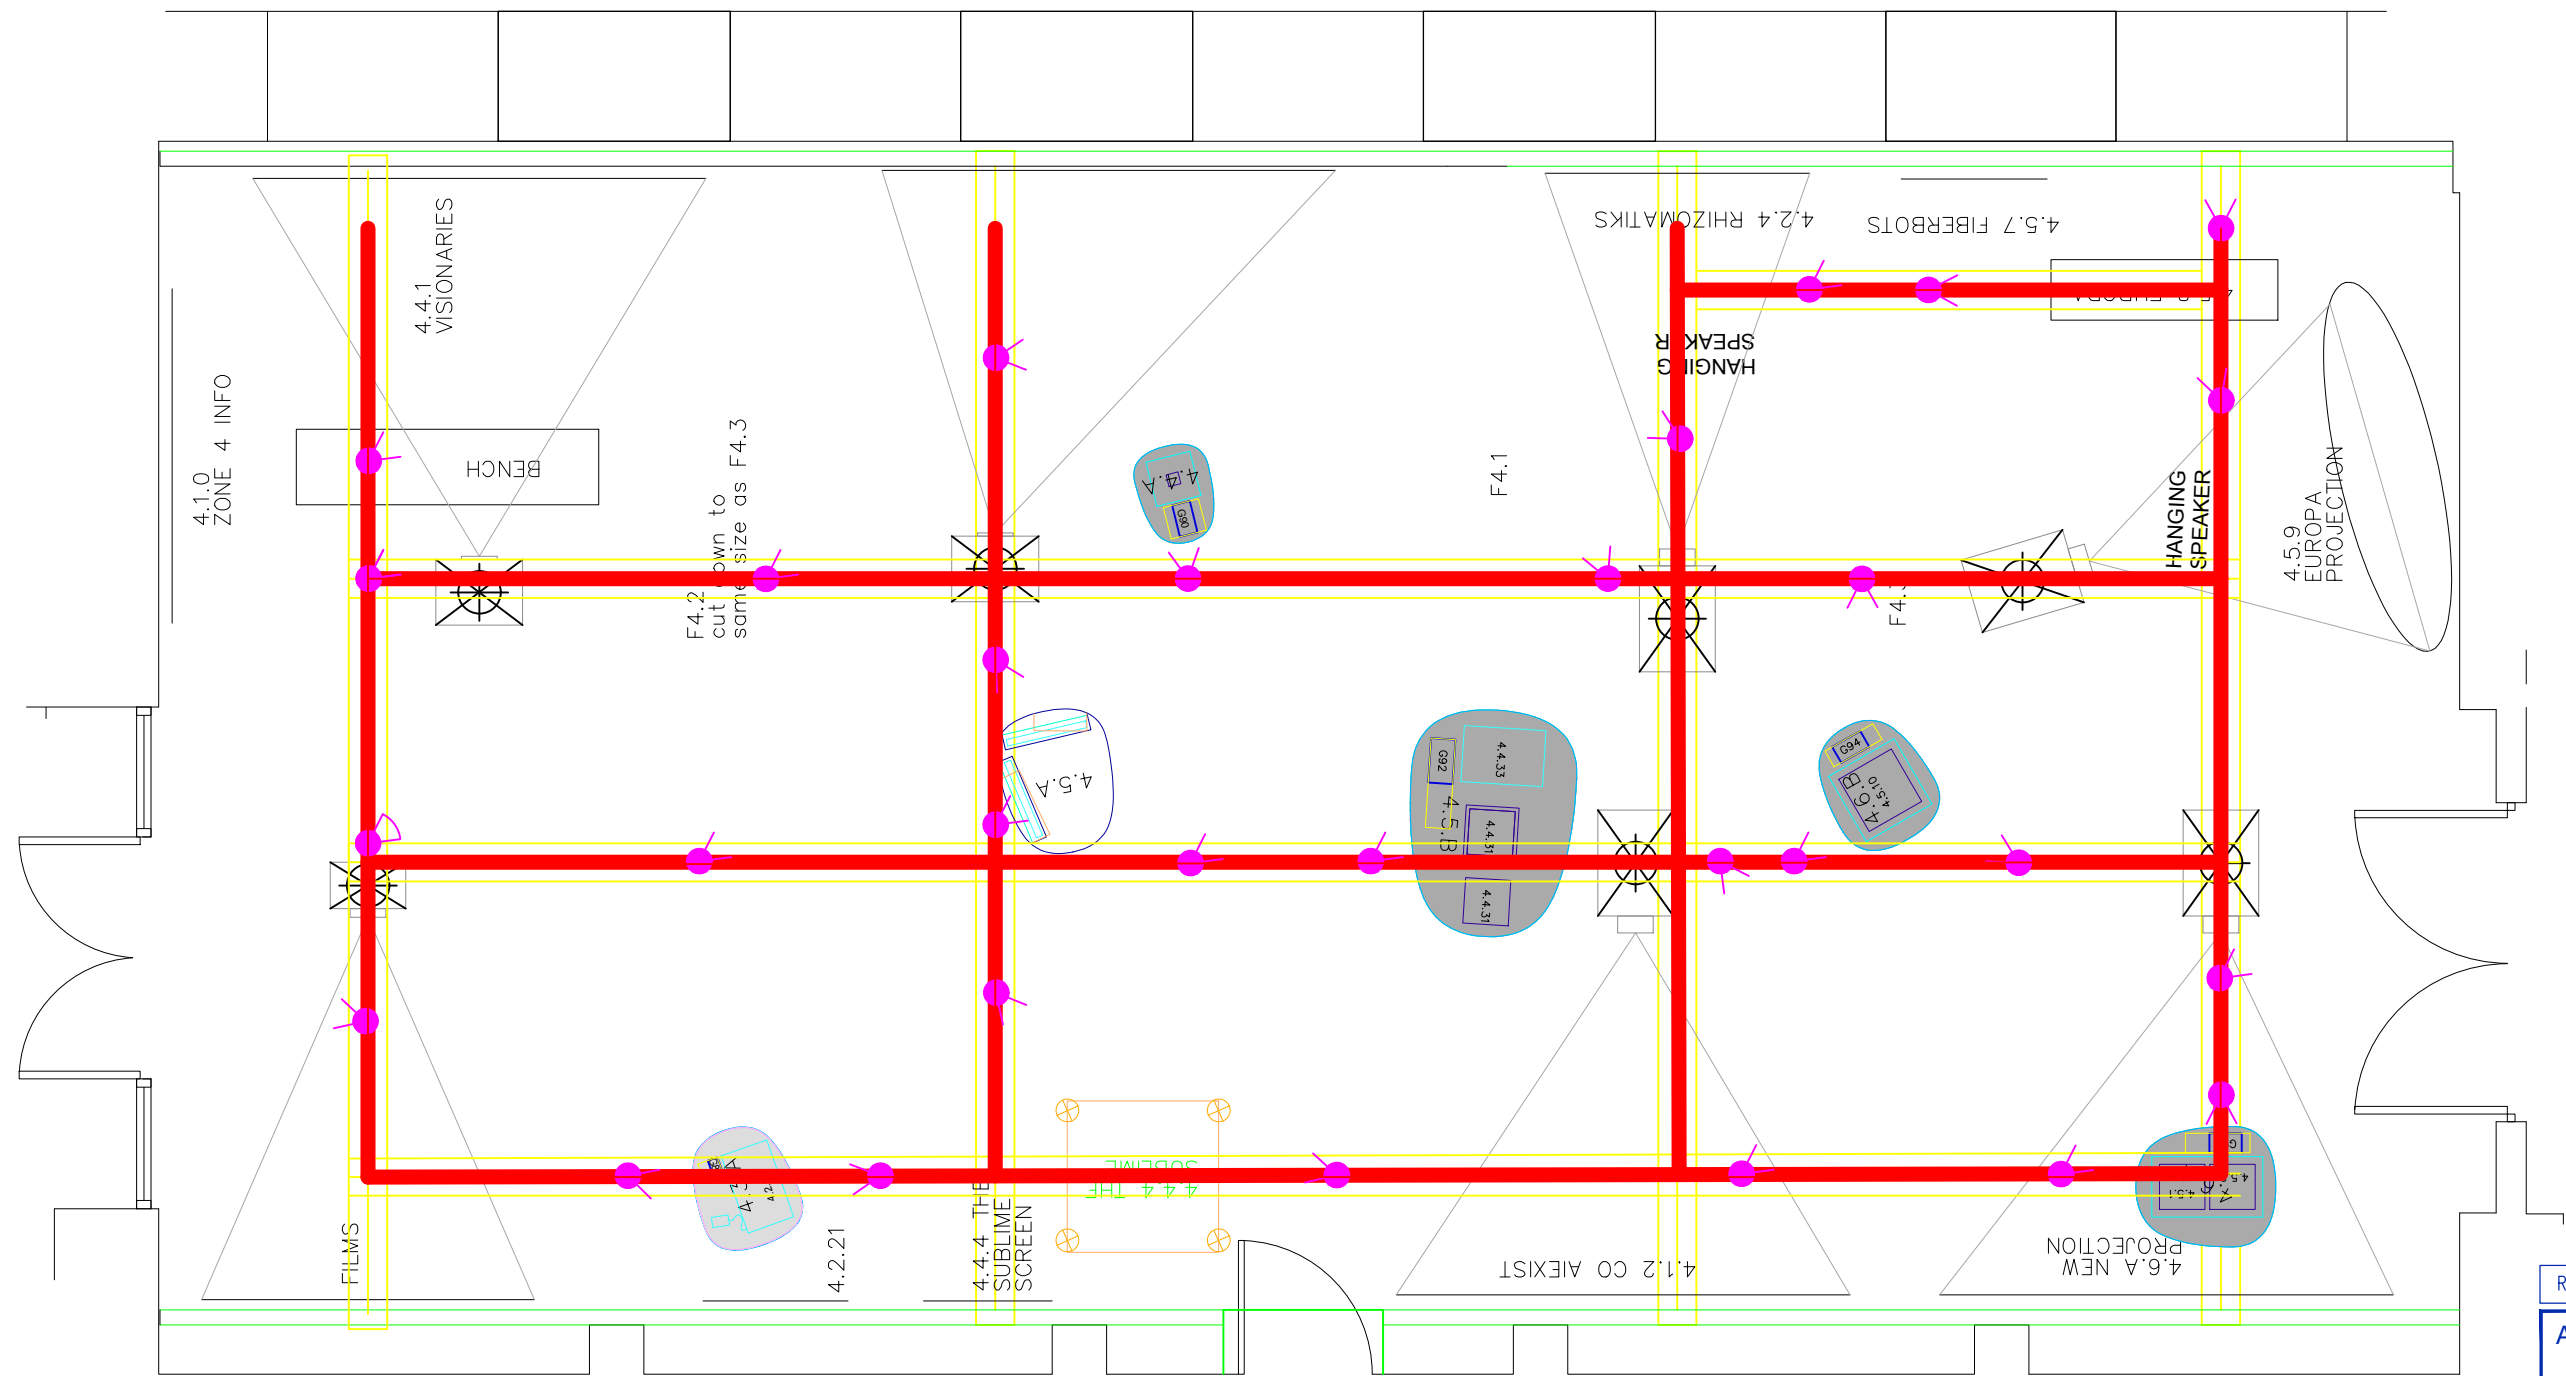

Light Track

Light Fitting 30 off

Revision	Details	Nome and Date
----------	---------	---------------

Address / Scheme
World Museum Liverpool
AI: More than Human

Title New Walls and trusses
Lighting Plan
for Section 4

Floor

Drawing Number	Revision
-1 /01	A

Scale	Date	Drawn	Status
A2 1:50 @A2	19/02/20	JSF	

NATIONAL MUSEUMS LIVERPOOL

national museums liverpool 127 dale street liverpool L2 2JH