




07/08/19 - Initial plan

Date	Rev	Description
07/08/19	-	Initial plan

DO NOT SCALE: ALL DIMENSIONS TO BE CHECKED ON SITE AND VERIFIED PRIOR TO COMMENCING WORKMANUFACTURE. ANY DISCREPANCIES TO BE REPORTED TO THE OFFICE.

THIS DRAWING IS PROTECTED BY COPYRIGHT. IT MAY NOT BE PRODUCED IN ANY FORM OR BY ANY MEANS FOR ANY PURPOSE WITHOUT THE WRITTEN PERMISSION OF OWNER.

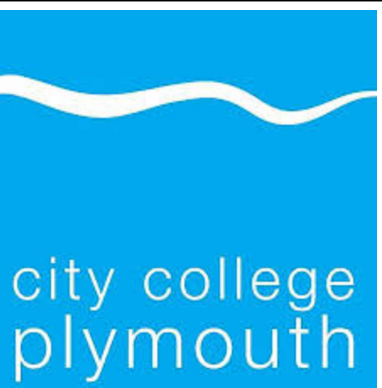

Title:
Existing Plan for;
Innovation KI205/ KI206
City College Plymouth
Kings Road Centre
Plymouth
Devon
PL1 5QG

Date	Rev	Description
08/19	-	Initial plan

Scale: 1:50@ A1

Drawing No.	Drawn	Rev.
CCP-AH-I2M-01	G Parry	-

Notes


- 1. Allow to move, reposition or protect any equipment including, desks and computers
- 2. Allow to remove and set aside all pictures, signs, posters, notice boards, pin boards, & wipe boards.


Strip Out

- 1. Allow to uplift flooring to work area and dispose
- 2. Allow to remove existing electrical services to ceiling and make safe. Set aside existing fire sensors to maintain fire protection. Disconnection and reconnection will be organized by the College once new ceiling has been installed.




Defined Work Area

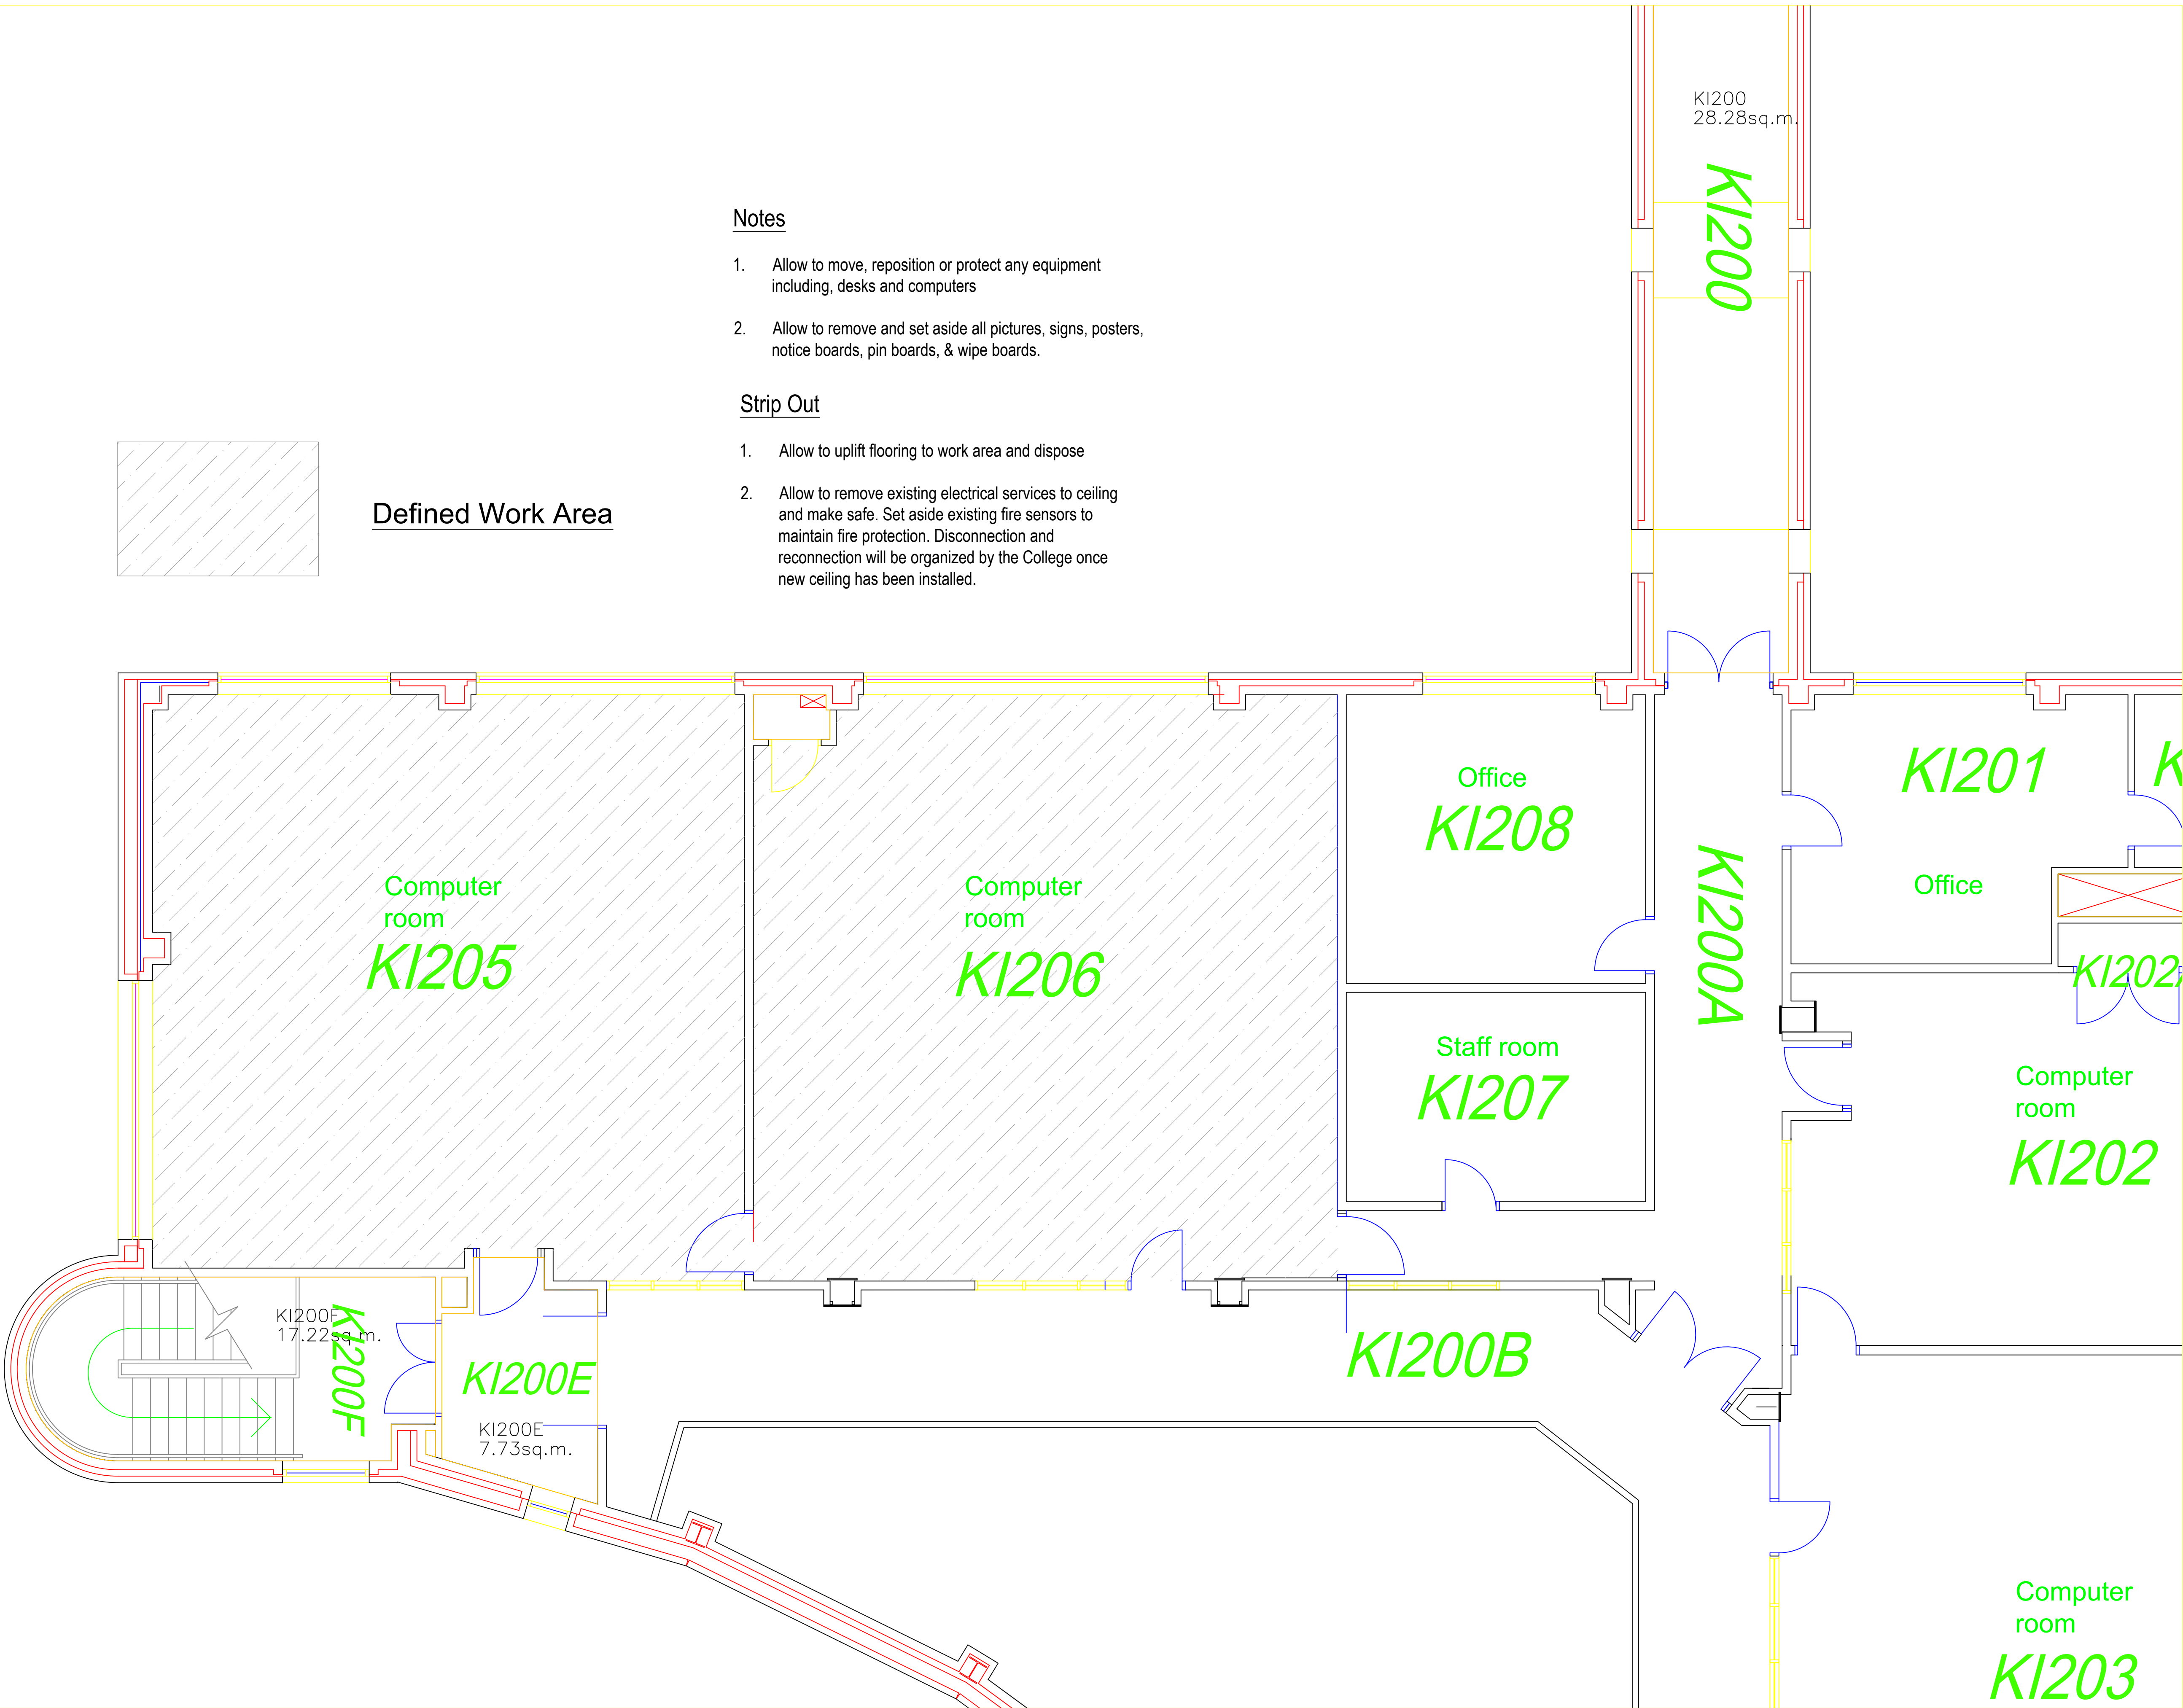

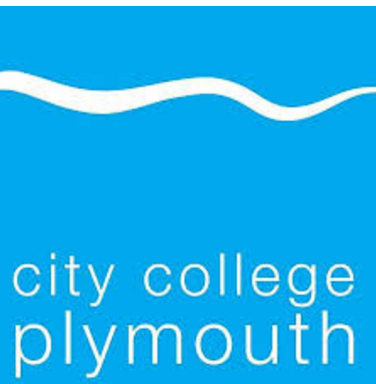
19/07/19	-	Initial plan
<small>DO NOT SCALE: ALL DIMENSIONS TO BE CHECKED ON SITE AND VERIFIED PRIOR TO COMMENCING WORK/MANUFACTURE. ANY DISCREPANCIES TO BE REPORTED TO THE OFFICE. THIS DRAWING IS PROTECTED BY COPYRIGHT. IT MAY NOT BE PRODUCED IN ANY FORM OR BY ANY MEANS FOR ANY PURPOSE WITHOUT THE WRITTEN PERMISSION OF OWNER.</small>		
		
Title: Strip Out Plan for; Innovation KI205/ KI206 City College Plymouth Kings Road Centre Plymouth Devon PL1 5QG		
Date: 08/19	Drawing No. CCP-AH-I2M-02	Rev: -
Scale: 1:50@ A1	Drawn: G Parry	Rev: -

New Suspended Ceiling Grid & Tiles

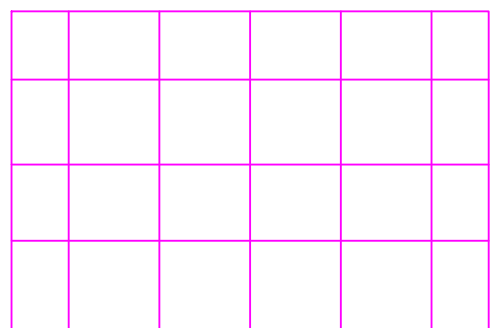


KI205 84M2
KI206 83M2

Perimeter Batten	Not required
Grid	Armstrong
Tile	Armstrong Dune Max
Size	600mm x 600mm
Finish	Square Edge

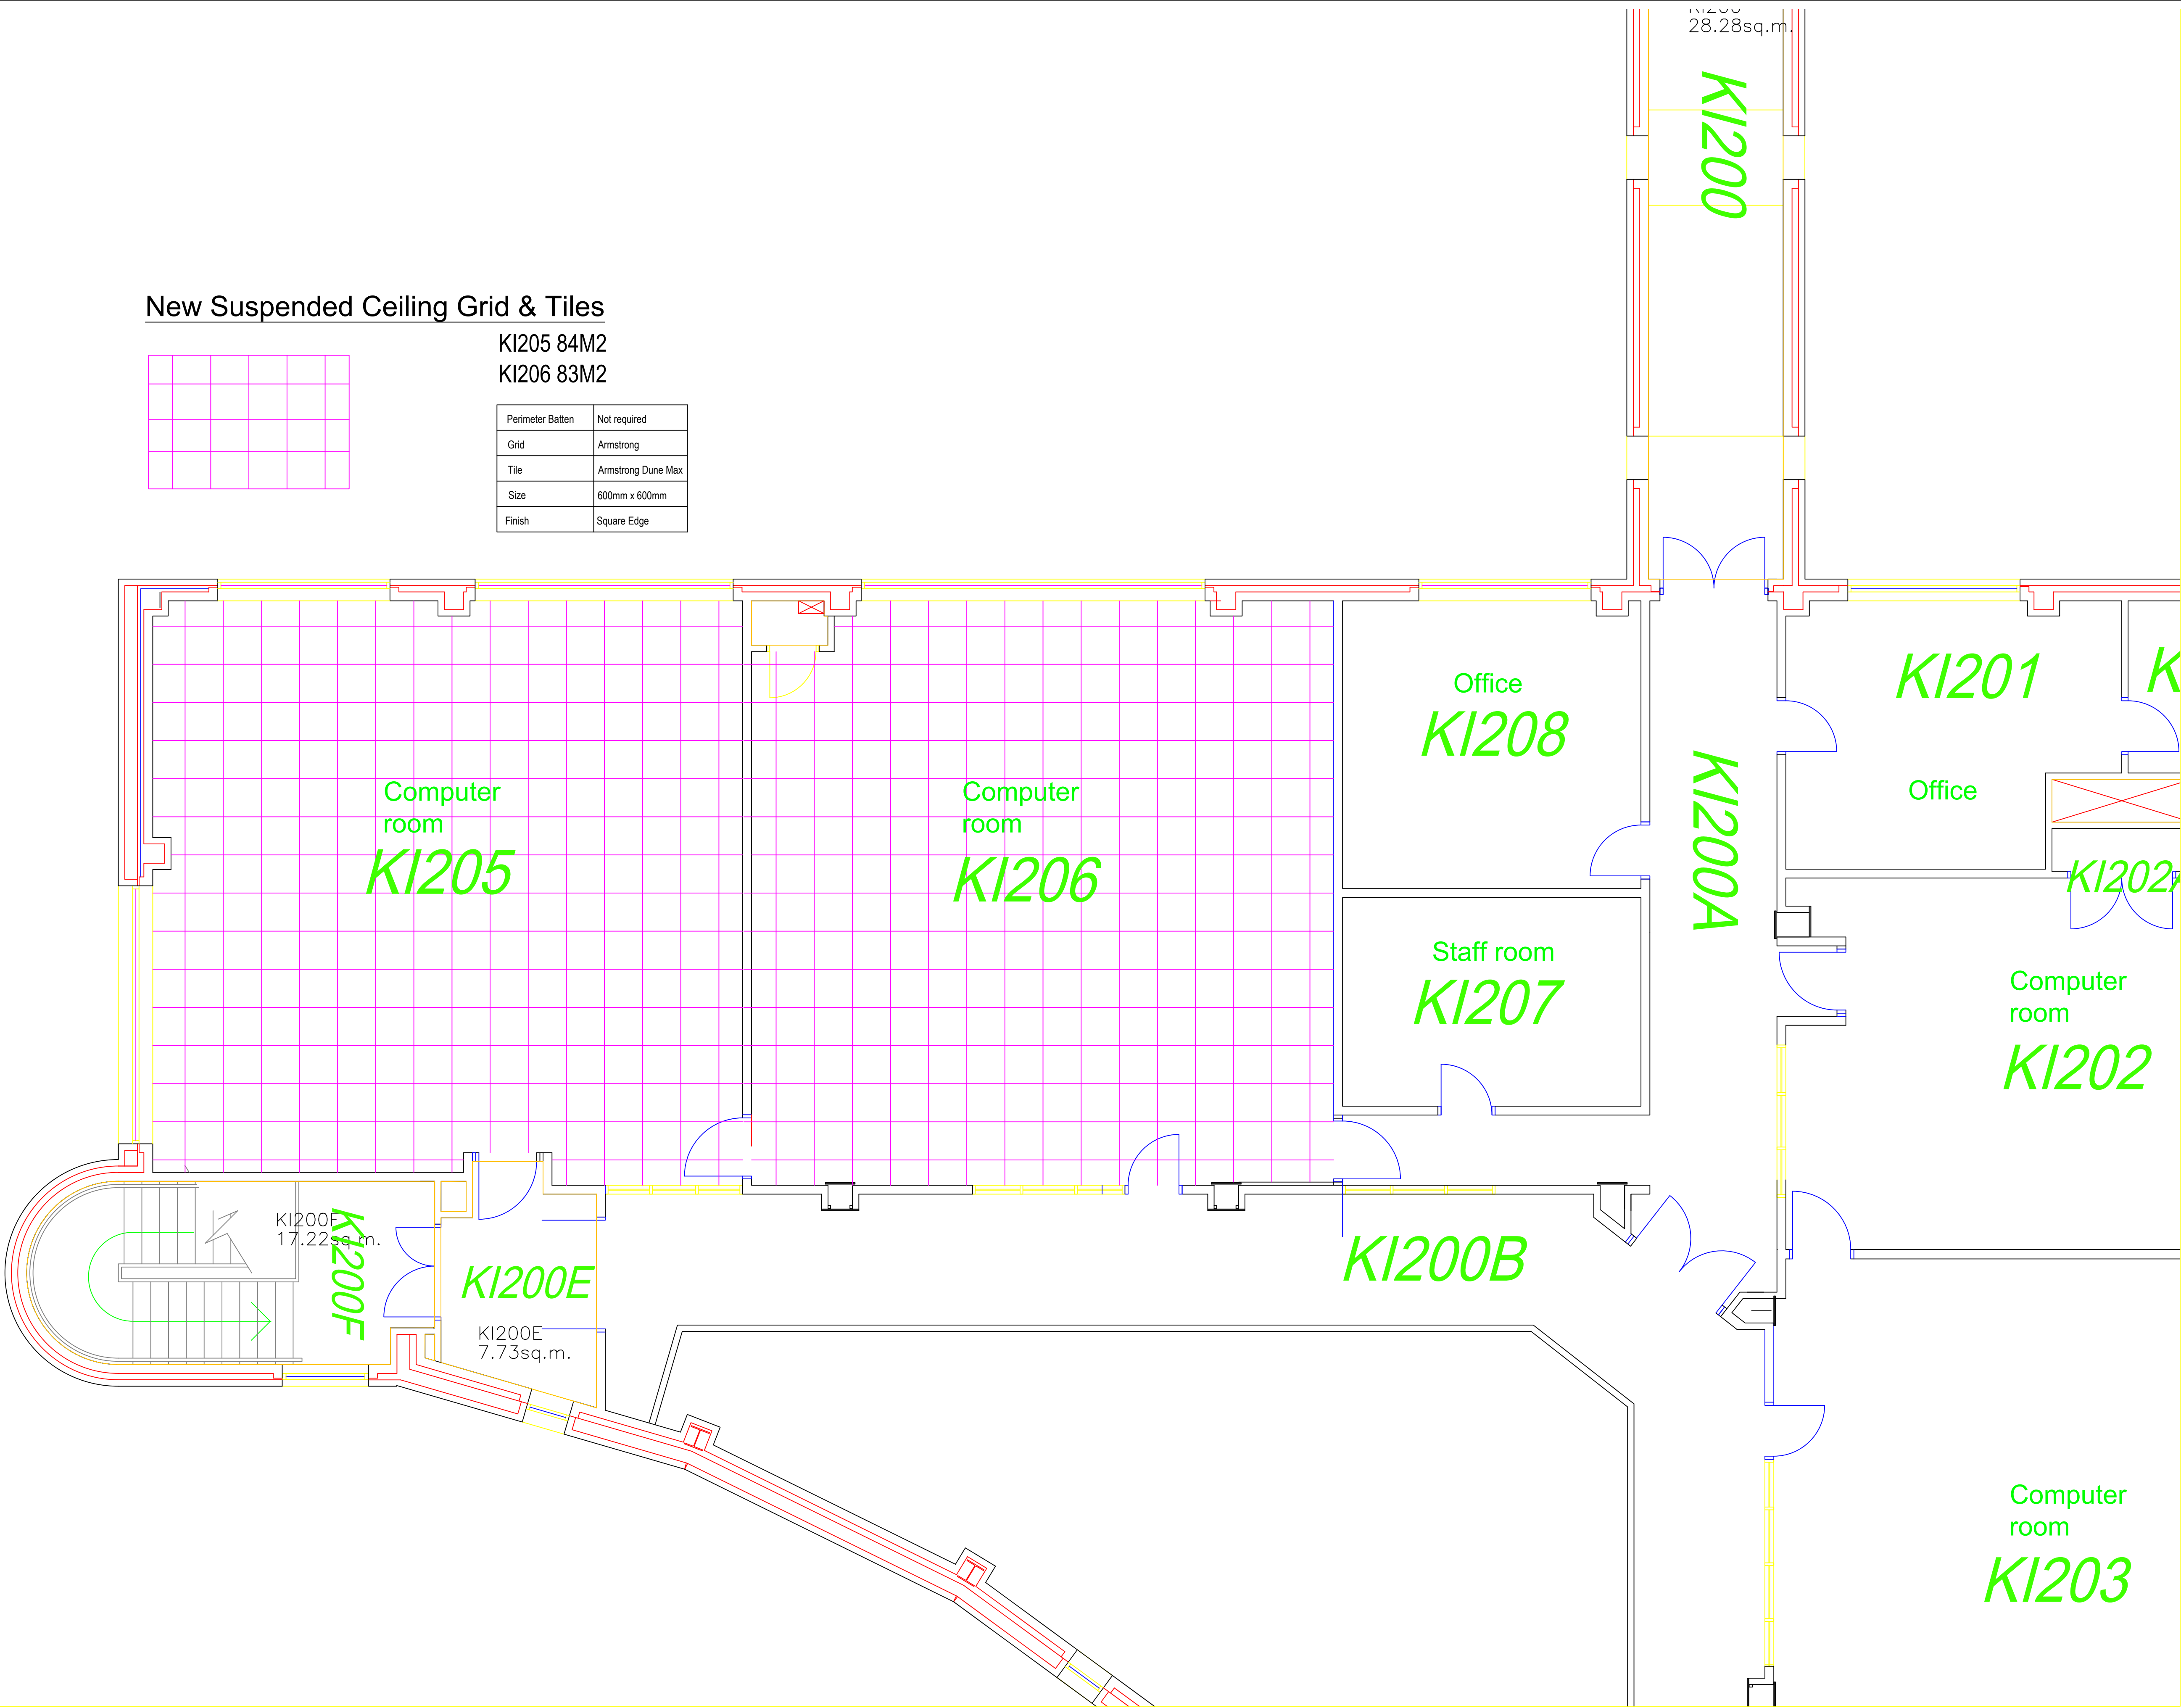


Date	Rev	Description
19/07/19	-	Initial plan

DO NOT SCALE: ALL DIMENSIONS TO BE CHECKED ON SITE AND VERIFIED PRIOR TO COMMENCING WORKMANUFACTURE. ANY DISCREPANCIES TO BE REPORTED TO THE OFFICE.
THIS DRAWING IS PROTECTED BY COPYRIGHT. IT MAY NOT BE PRODUCED IN ANY FORM OR BY ANY MEANS FOR ANY PURPOSE WITHOUT THE WRITTEN PERMISSION OF OWNER.

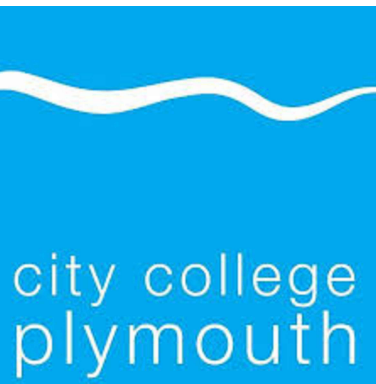


Title:
Suspended Ceiling Plan for;
Innovation KI205/ KI206
City College Plymouth
Kings Road Centre
Plymouth
Devon
PL1 5QG

Date: 07/19	Drawing No. CCP-AH-I2C-03
Scale: 1:50@ A1	Drawn: G Parry Rev: -

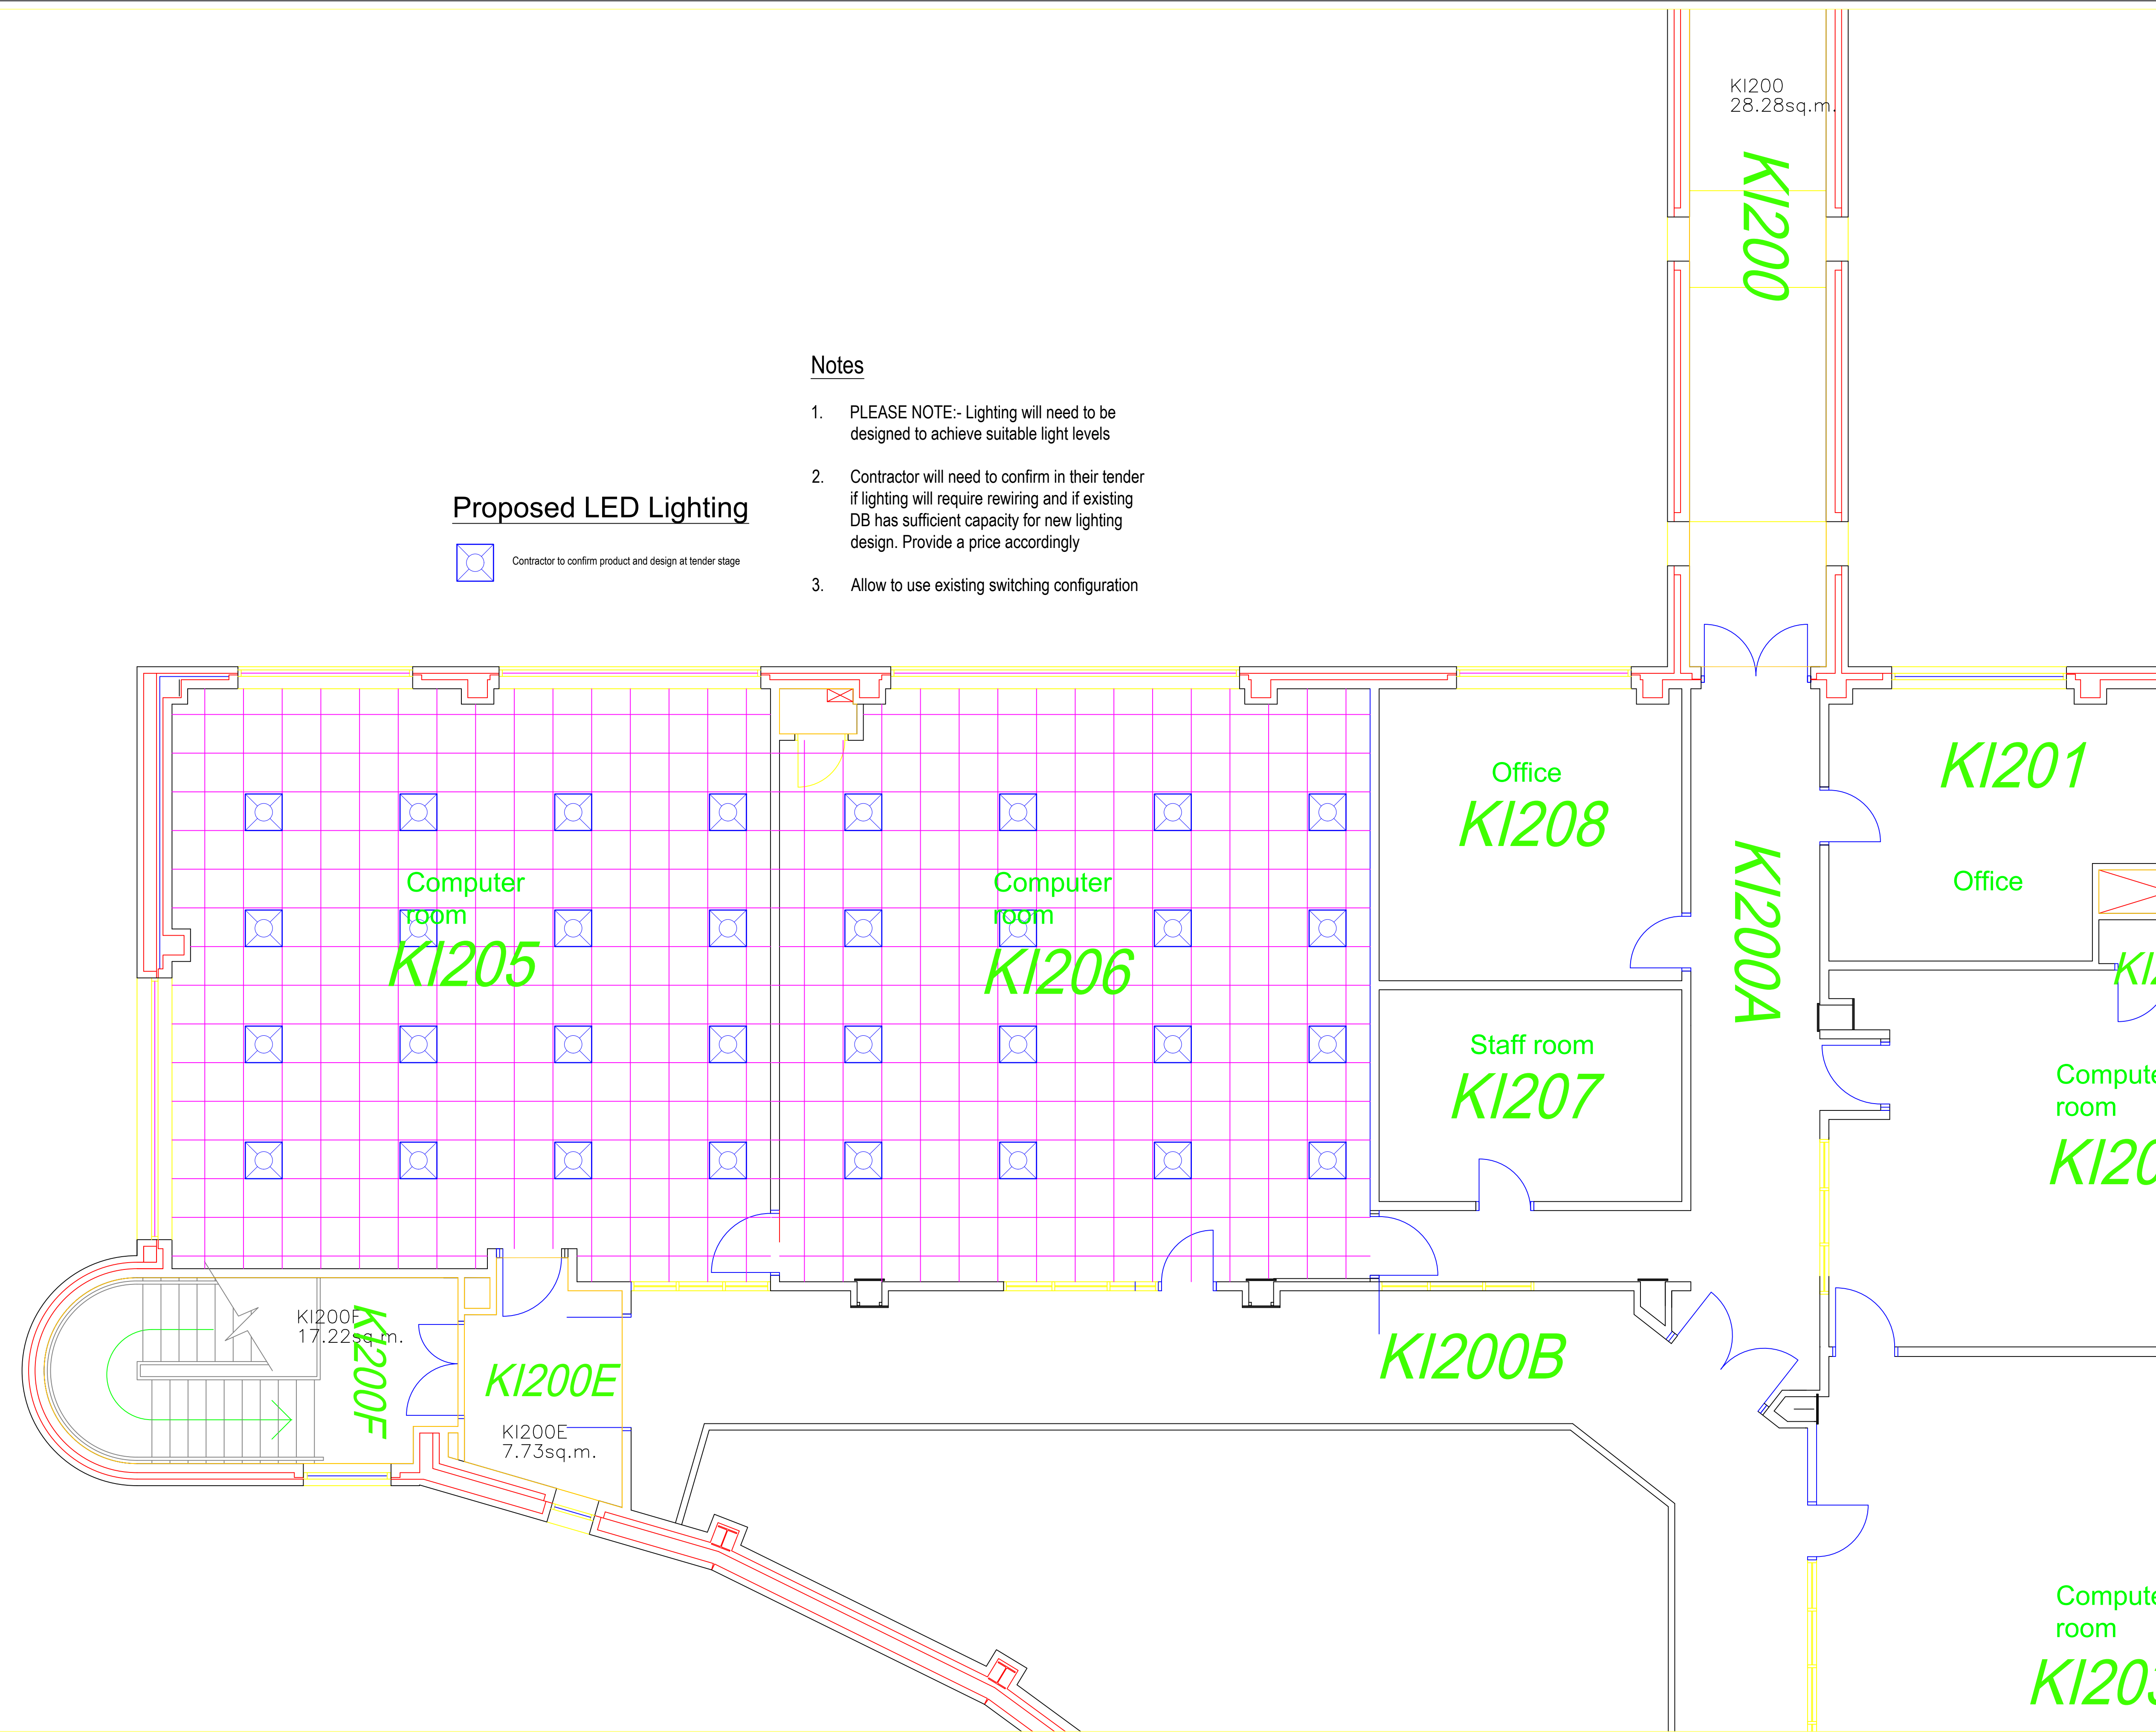

Proposed LED Lighting

 
 Contractor to confirm product and design at tender stage

Notes

1. PLEASE NOTE:- Lighting will need to be designed to achieve suitable light levels
2. Contractor will need to confirm in their tender if lighting will require rewiring and if existing DB has sufficient capacity for new lighting design. Provide a price accordingly
3. Allow to use existing switching configuration


07/08/19	-	Initial plan
----------	---	--------------

DO NOT SCALE: ALL DIMENSIONS TO BE CHECKED ON SITE AND VERIFIED PRIOR TO COMMENCING WORKMANUFACTURE. ANY DISCREPANCIES TO BE REPORTED TO THE OFFICE.
THIS DRAWING IS PROTECTED BY COPYRIGHT. IT MAY NOT BE PRODUCED IN ANY FORM OR BY ANY MEANS FOR ANY PURPOSE WITHOUT THE WRITTEN PERMISSION OF OWNER.

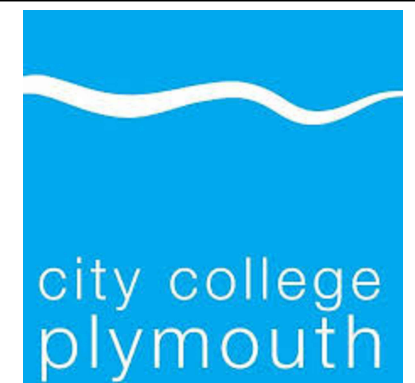

Title:
Lighting Plan for;
Innovation KI205/ KI206
City College Plymouth
Kings Road Centre
Plymouth
Devon
PL1 5QG

Date: 08/19	Drawing No. CCP-AH-I2M-04
Scale: 1:50@ A1	Drawn: G Parry Rev: -

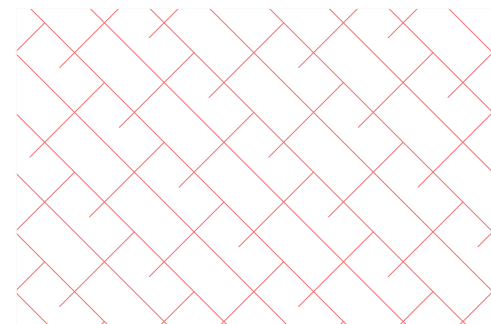


Area to be Decorated all previously painted walls.

Notes

- 1. Do not allow for painting of radiators, pipes, doors or windows
- 2. Allow to remove all door furniture from linings prior to painting

Decoration


- 1. Allow to remove all pictures, pin boards, wipe boards, notice boards. Do not remove media boards.
- 2. Allow for all preparation works to include filling any holes, sanding, filling, stopping, chalking
- 3. Paint walls with Crown Eggshell. Color to be White
- 4. Paint linings & architraves (Room side only) with Dark Grey undercoat & top coat of Satinwood RAL 7016
- 5. Paint previously painted skirting with Dark Grey undercoat & top coat of Satinwood RAL 7016

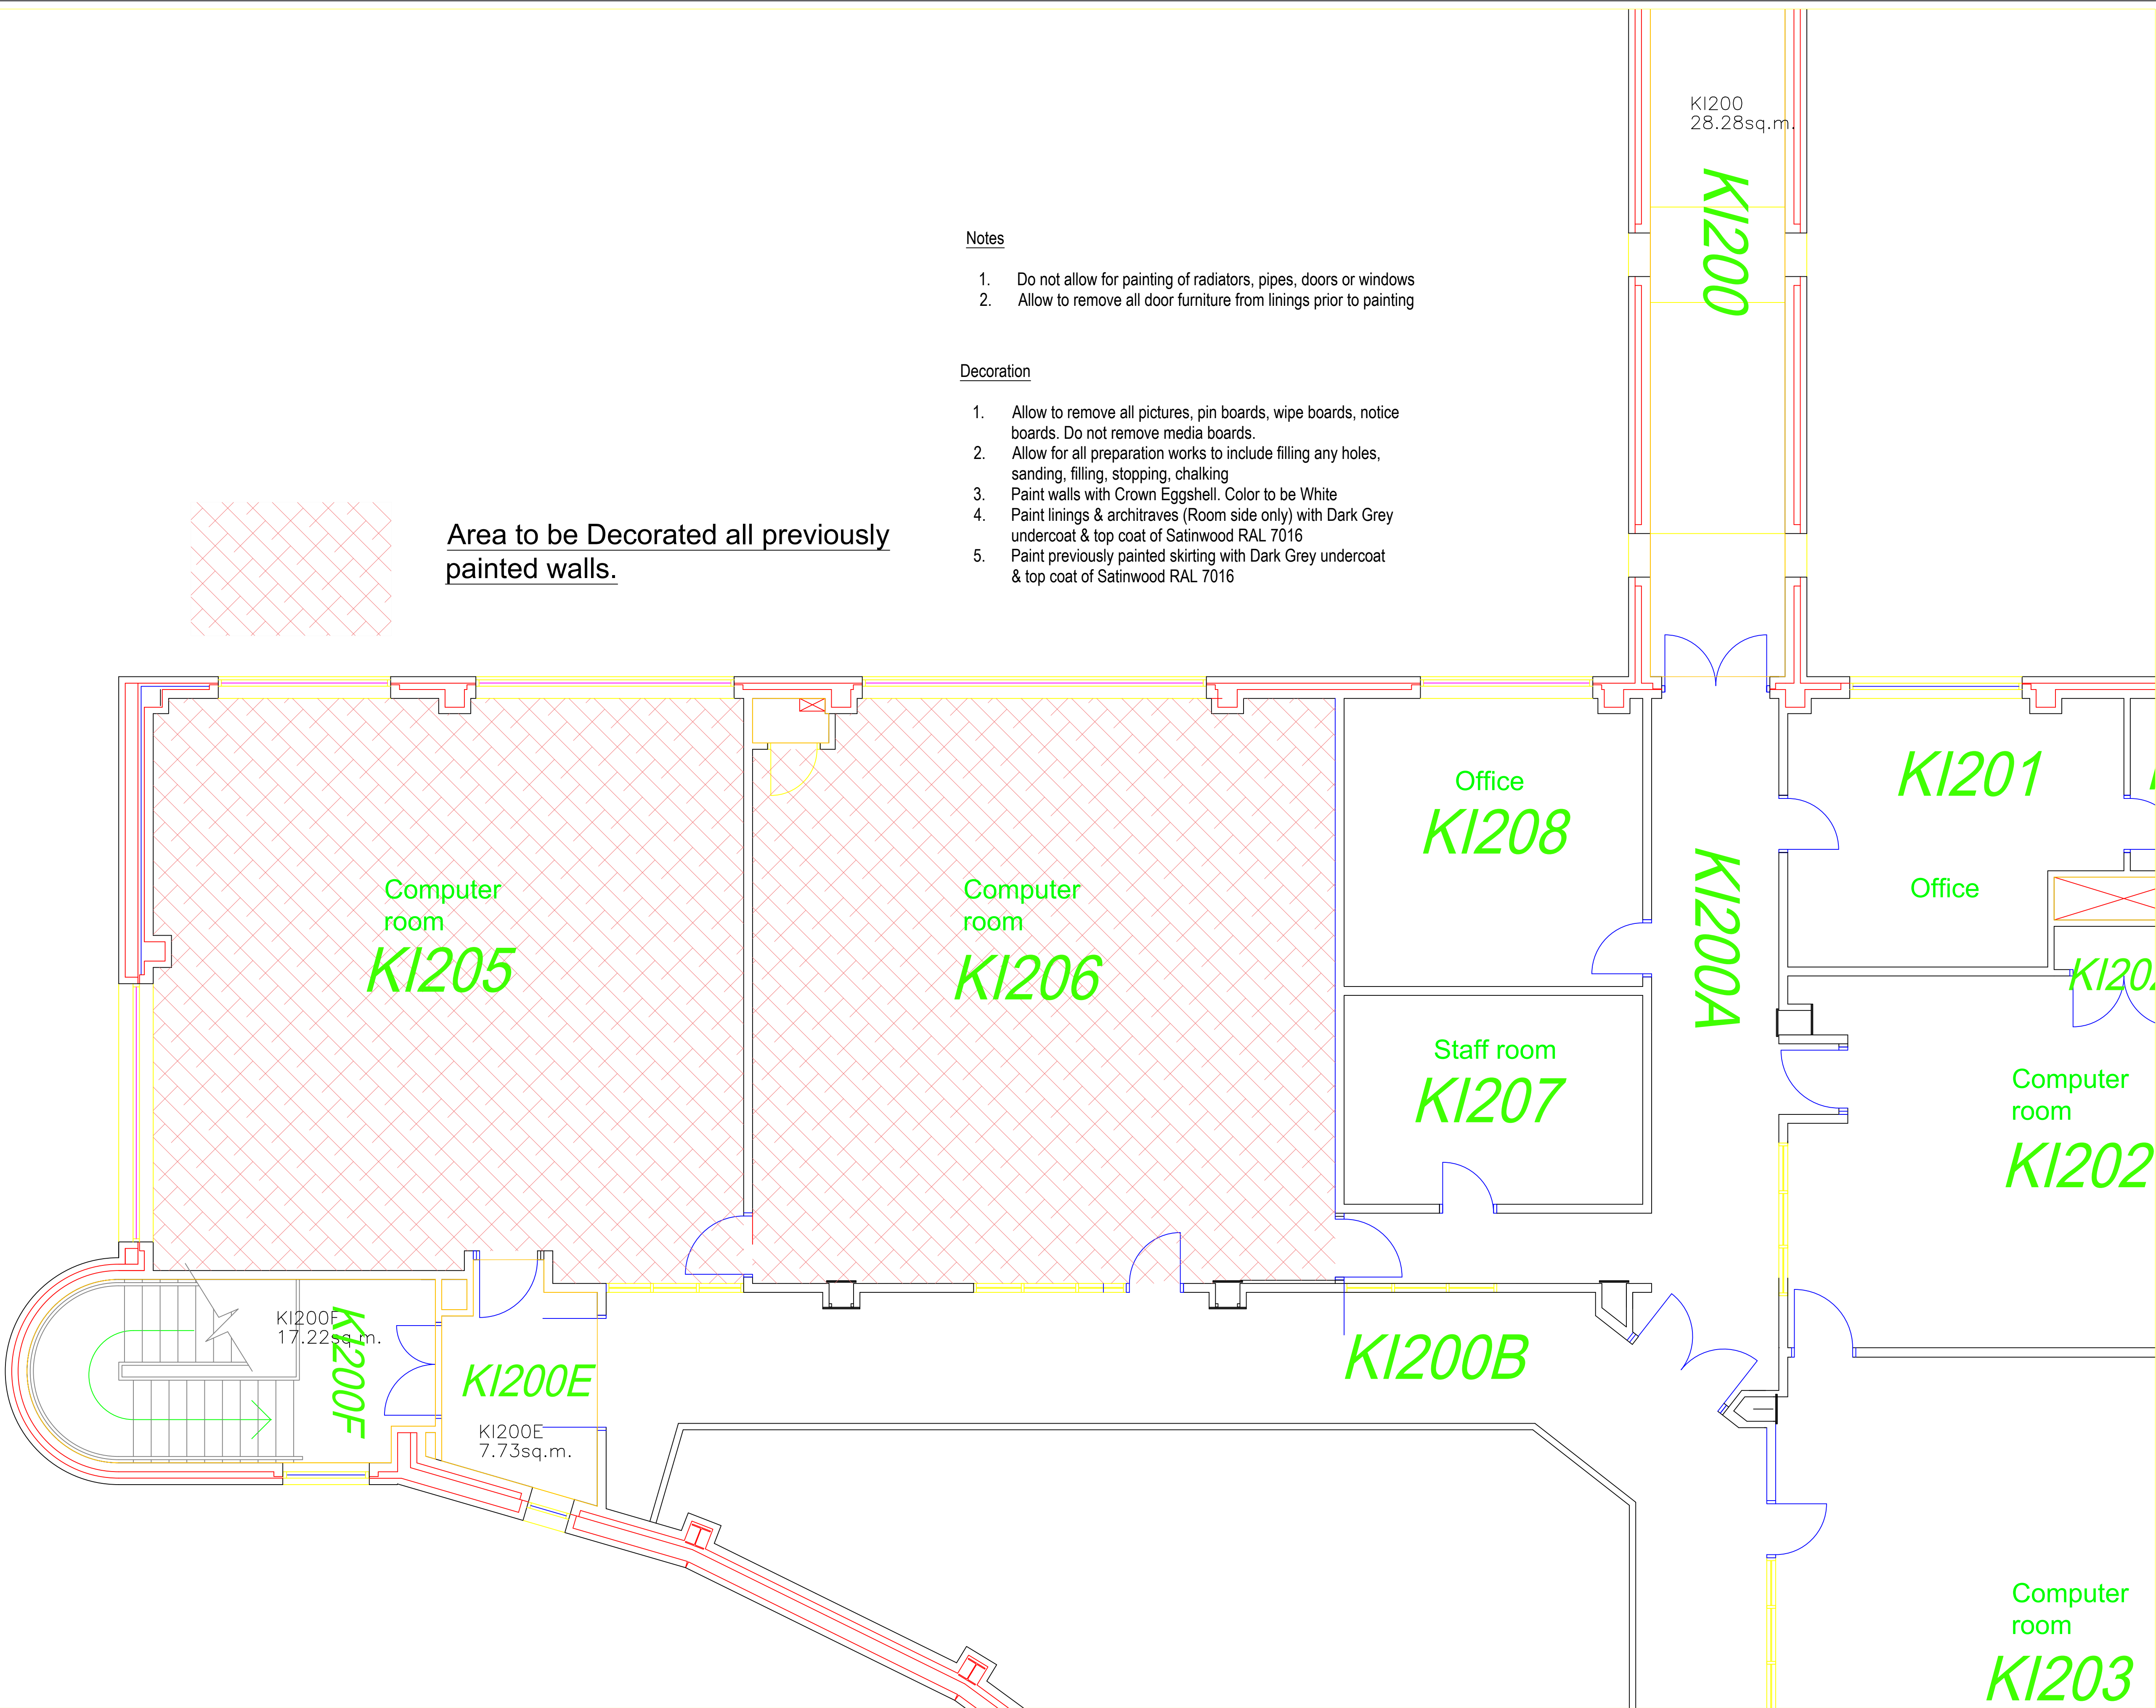

07/08/19	-	Initial plan
----------	---	--------------


DO NOT SCALE: ALL DIMENSIONS TO BE CHECKED ON SITE AND VERIFIED PRIOR TO COMMENCING WORK/MANUFACTURE. ANY DISCREPANCIES TO BE REPORTED TO THE OFFICE.

THIS DRAWING IS PROTECTED BY COPYRIGHT. IT MAY NOT BE PRODUCED IN ANY FORM OR BY ANY MEANS FOR ANY PURPOSE WITHOUT THE WRITTEN PERMISSION OF OWNER.

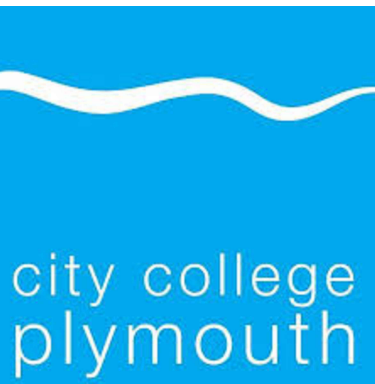

Title:
Decoration Plan for:
Innovation KI205/ KI206
City College Plymouth
Kings Road Centre
Plymouth
Devon
PL1 5QG

Date: 08/19	Drawing No. CCP-AH-I2M-05
Scale: 1:50@ A1	Drawn: G Parry Rev: -

 

FORBO FLOORING
KI205 84M2
KI206 83M2

Descriptive Colour:-	Teviot Neptune
Product:-	Forbo
Range:-	Tessera

KI200
28.28sq.m.

KI200

Office
KI208

KI201

Office

KI202

Computer room

KI203

Computer room
KI205

Computer room
KI206

Staff room
KI207

KI200A


KI200B

KI200F
17.22sq.m.

KI200F

KI200E

KI200E
7.73sq.m.

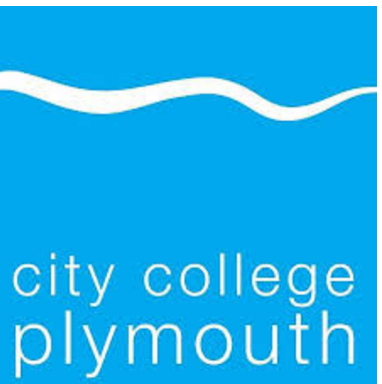


Title: Flooring Layout Plan for; Innovation KI205/ KI206 City College Plymouth Kings Road Centre Plymouth Devon PL1 5QG		
Date: 08/19	Drawing No. CCP-AH-I2M-06	Rev: -
Scale: 1:50@ A1	Drawn: G Parry	Rev: -



Date	Rev	Description
07/08/19	-	Initial plan

DO NOT SCALE: ALL DIMENSIONS TO BE CHECKED ON SITE AND VERIFIED PRIOR TO COMMENCING WORK/MANUFACTURE. ANY DISCREPANCIES TO BE REPORTED TO THE OFFICE.
THIS DRAWING IS PROTECTED BY COPYRIGHT. IT MAY NOT BE PRODUCED IN ANY FORM OR BY ANY MEANS FOR ANY PURPOSE WITHOUT THE WRITTEN PERMISSION OF OWNER.

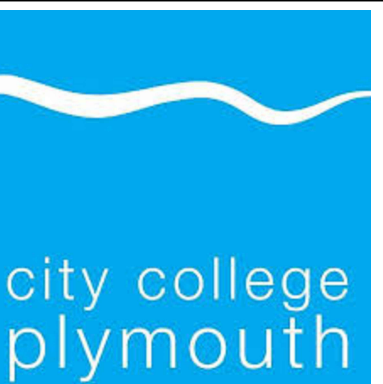

Title:
Desk Layout Plan for;
Innovation K1205/ K1206
City College Plymouth
Kings Road Centre
Plymouth
Devon
PL1 5QG

Date: 08/19	Drawing No. CCP-AH-I2M-07
Scale: 1:50@ A1	Drawn: G Parry Rev: -