



- NOTES
1. THIS DRAWING IS TO BE READ IN CONJUNCTION WITH ALL RELEVANT ARCHITECTURAL & STRUCTURAL DRAWINGS.
  2. THIS DRAWING IS TO BE READ IN CONJUNCTION WITH ALL RELEVANT BUILDING SERVICES DRAWINGS & THE RELEVANT SECTIONS OF THE SPECIFICATIONS & SCHEDULES.
  3. THIS DRAWING IS NOT TO BE SCALED.
  4. ALL DIMENSIONS ARE IN mm UNLESS OTHERWISE STATED.
  5. DUCTWORK INSTALLATION TO BE IN ACCORDANCE WITH DW/144.
  6. ALL SUPPLY AND EXTRACT DUCTWORK IN ROOF SPACE, RISERS & PLANTROOM TO BE THERMALLY INSULATED.
  7. FIRE DAMPERS TO BE PROVIDED WHERE DUCTWORK INTERSECTS A FIRE WALL. FIRE DAMPERS TO BE OUT OF AIR STREAM TYPE.
  8. ALL BRANCHES SHALL BE COMPLETE WITH VDCS.

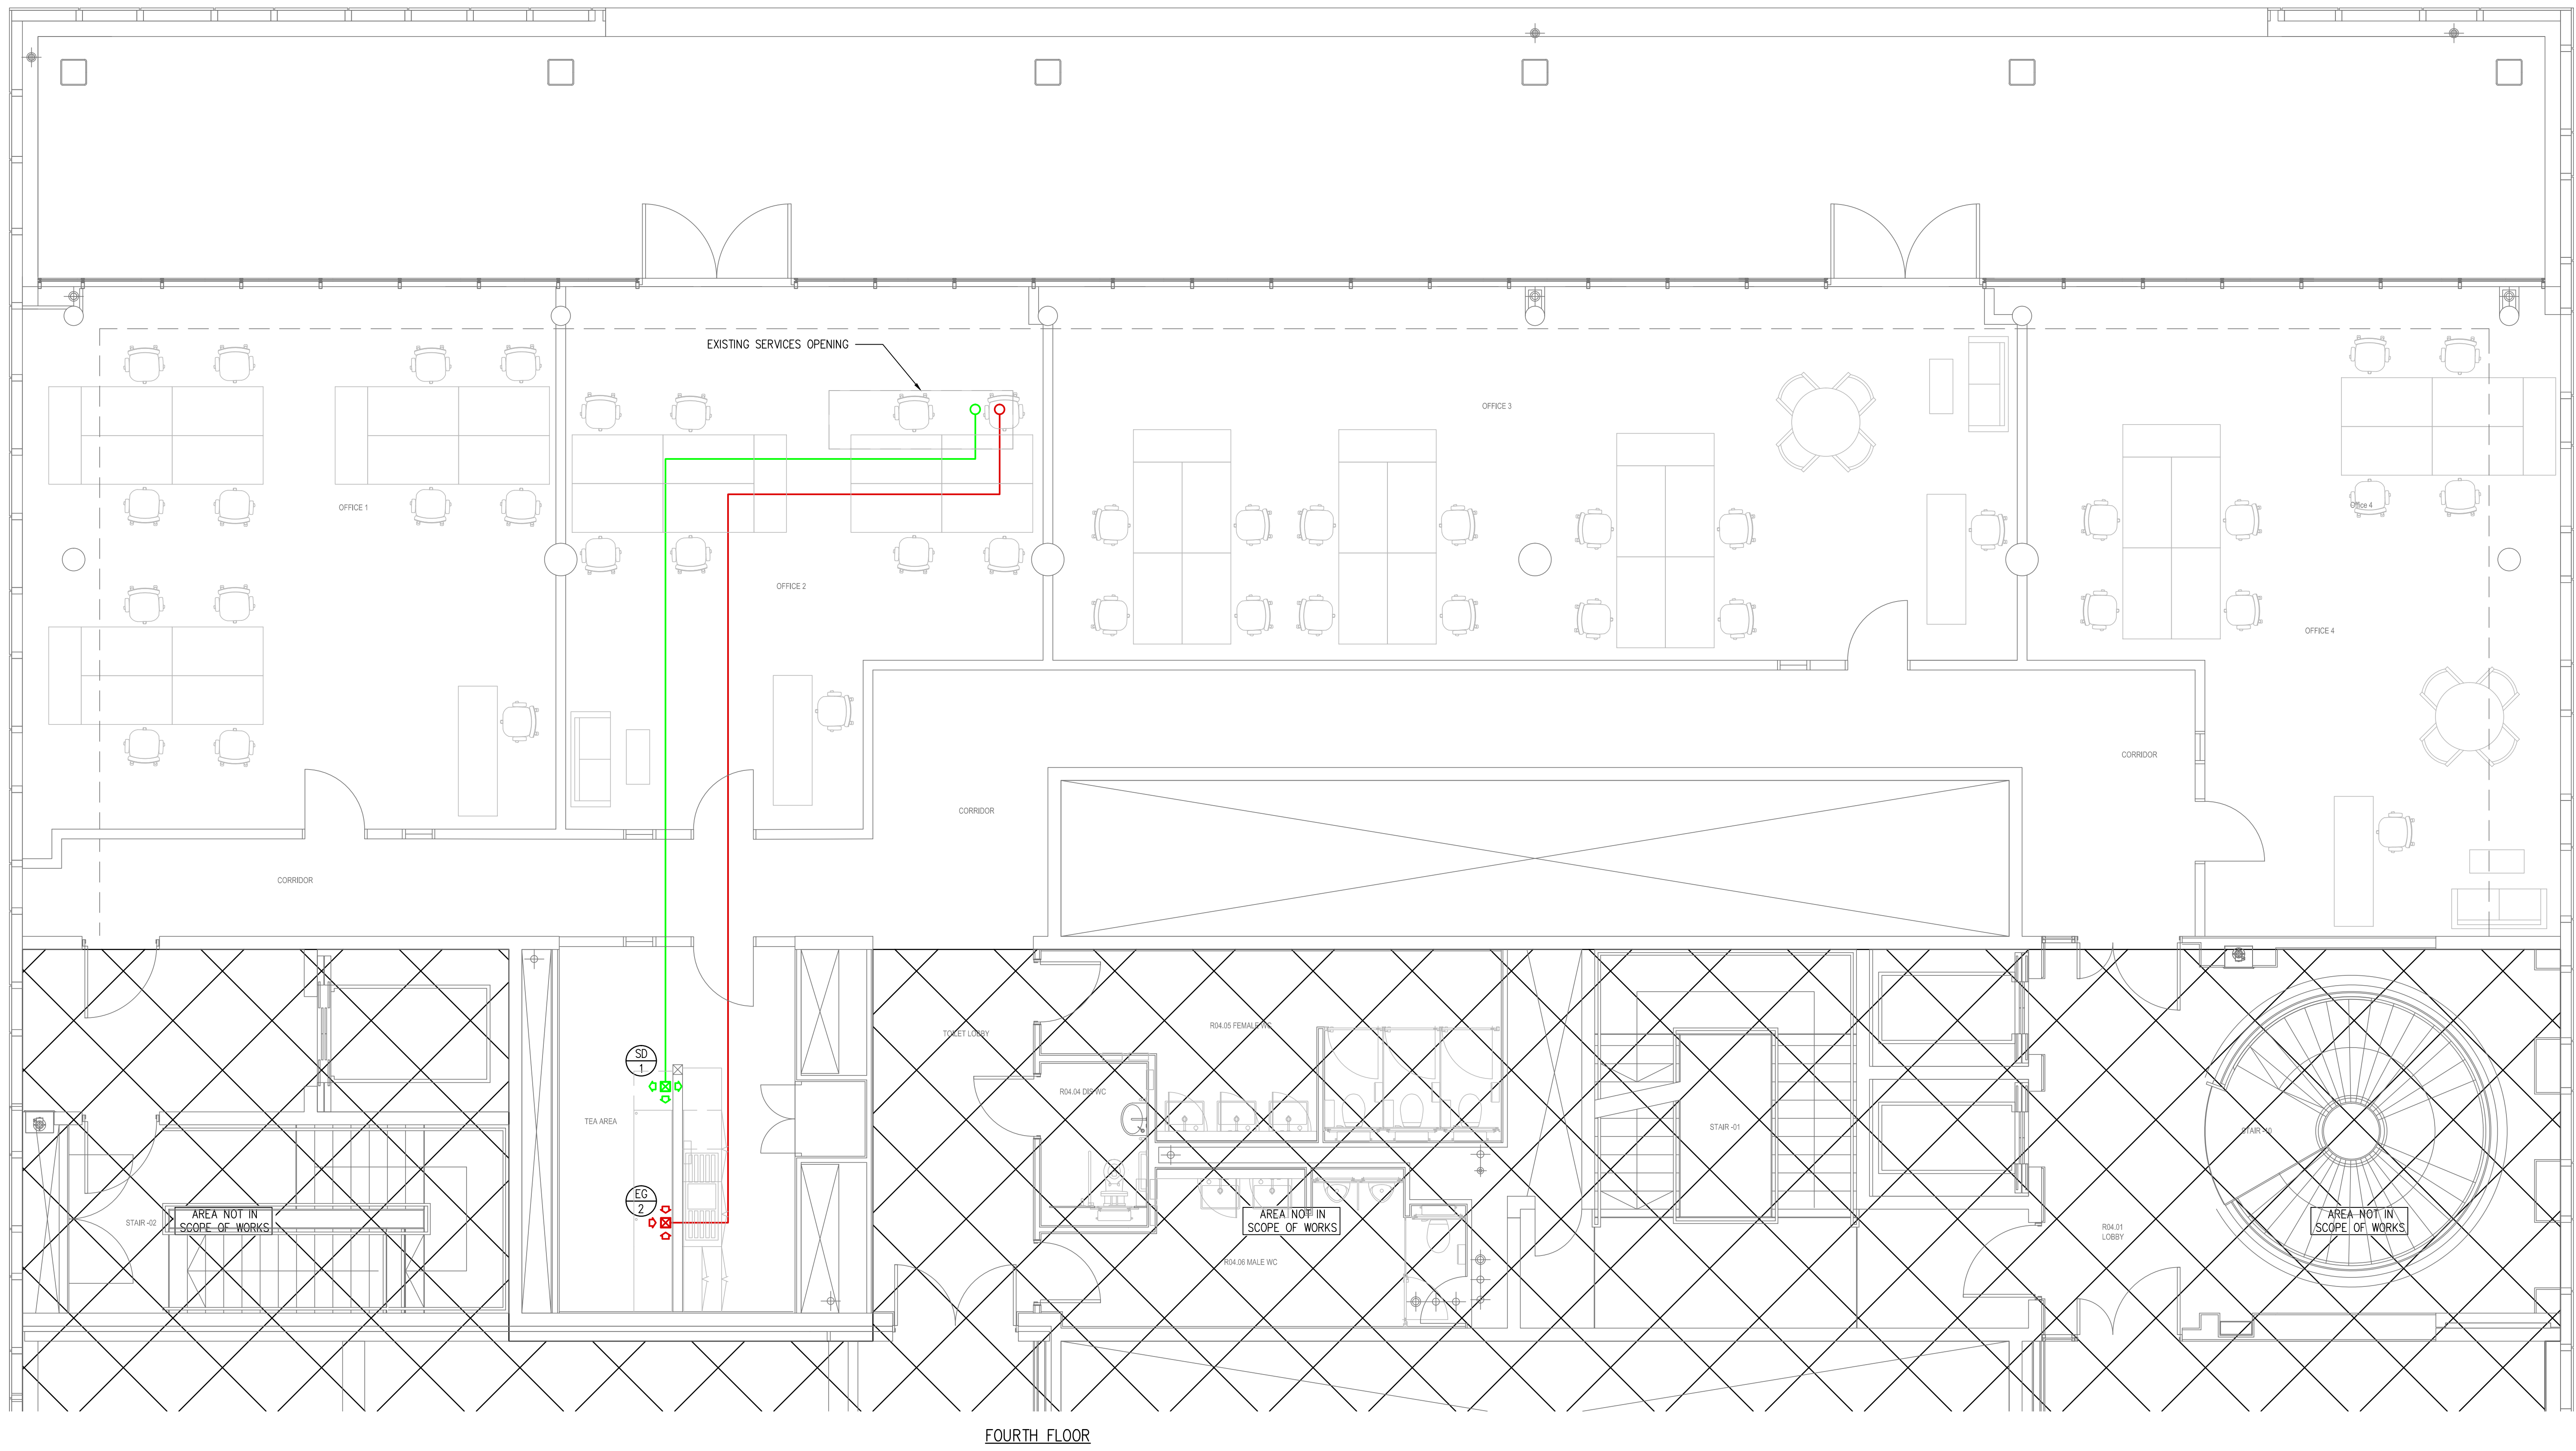

FOURTH FLOOR

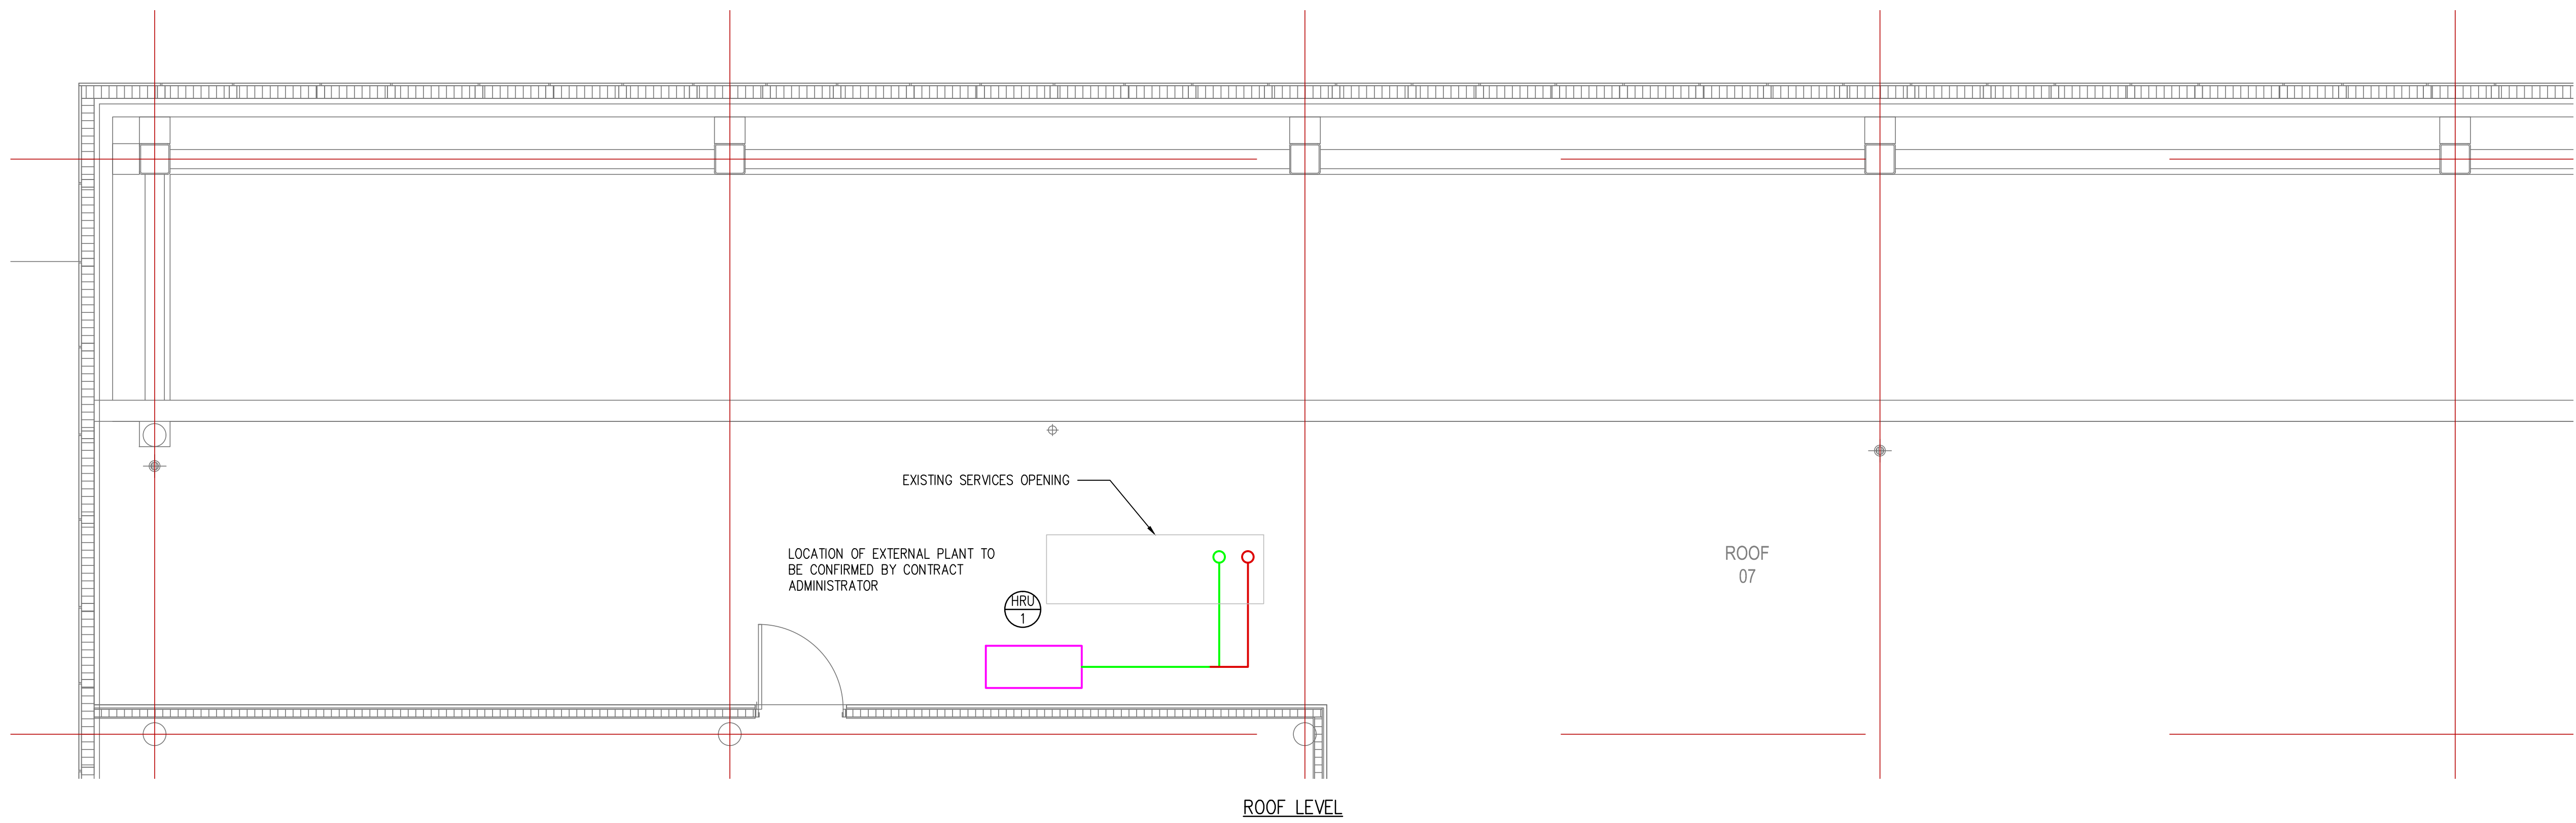

ROOF LEVEL

T2	10.01.17	X-REF UPDATED	SP
T1	06.01.17	MECHANICAL VENT REMOVED FROM OFFICES	SP
P1	02.12.16	PRELIMINARY ISSUE	SP
REV	DATE	DESCRIPTION	BY

**BSD** Building Services Design  
Consulting Engineers  
Website: [www.buildingservicesdesign.co.uk](http://www.buildingservicesdesign.co.uk)  
1 Brisbane House, Corbygate Business Park  
Potton Hall Road, Corby, Northamptonshire NN17 5JG  
Tel: (01536) 403304, Fax: (01536) 403838  
Email: [corby@buildingservicesdesign.co.uk](mailto:corby@buildingservicesdesign.co.uk)  
Offices in London, Cambridge, Birmingham, Manchester and Leicester

Client:  
CORBY BOROUGH COUNCIL

Project:  
CORBY CUBE  
FOURTH FLOOR OFFICE FIT OUT

Title:  
MECHANICAL SERVICES  
PROPOSED VENTILATION LAYOUT

Scale of A0:	Date:	Designed:	Drawn:	Design:
1:50	DEC 16		CAD:	
Drawing No:			Rev:	
161190/M/1500				T2

TENDER