



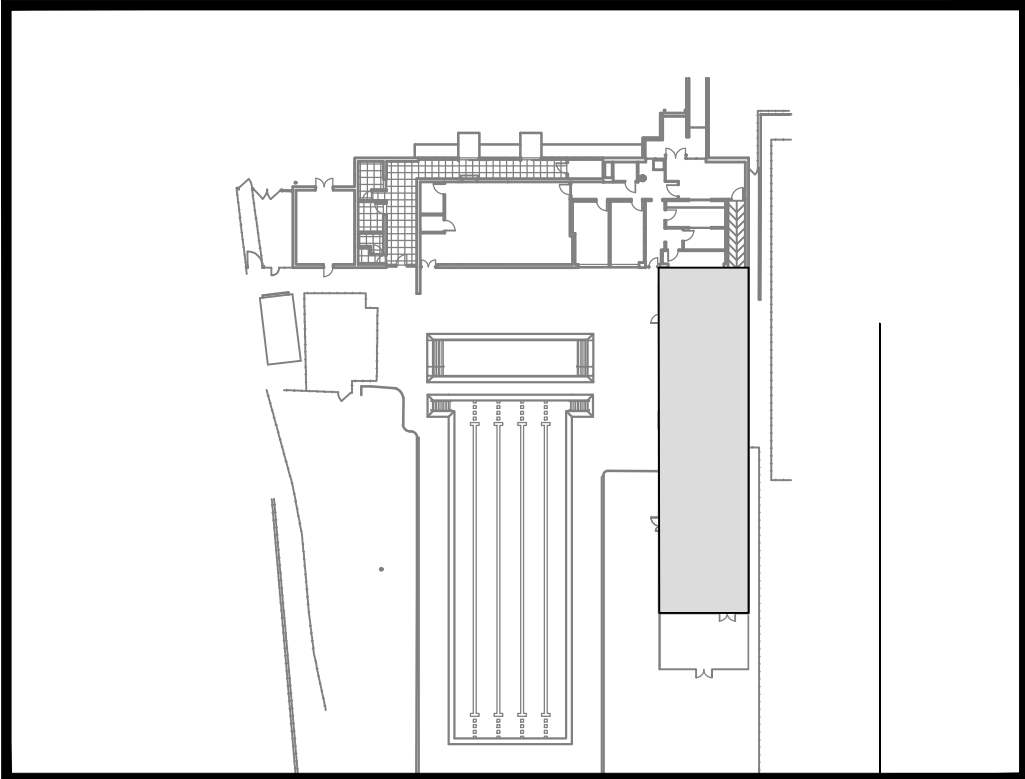

KEY PLAN (NTS)

GRILLE SCHEDULE								
Ref	Location	No Off	Manufacturer	Model	Height mm	Length mm	Volume (ls)	Pressure (Pa)
SG02	Changing Village	5	Gilberts	DG4	375	375	200	6
SG03	Changing Village	2	Gilberts	DG3	375	375	200	6
EV	Changing Village	47	Gilberts	GX150	202 Dia		30	45

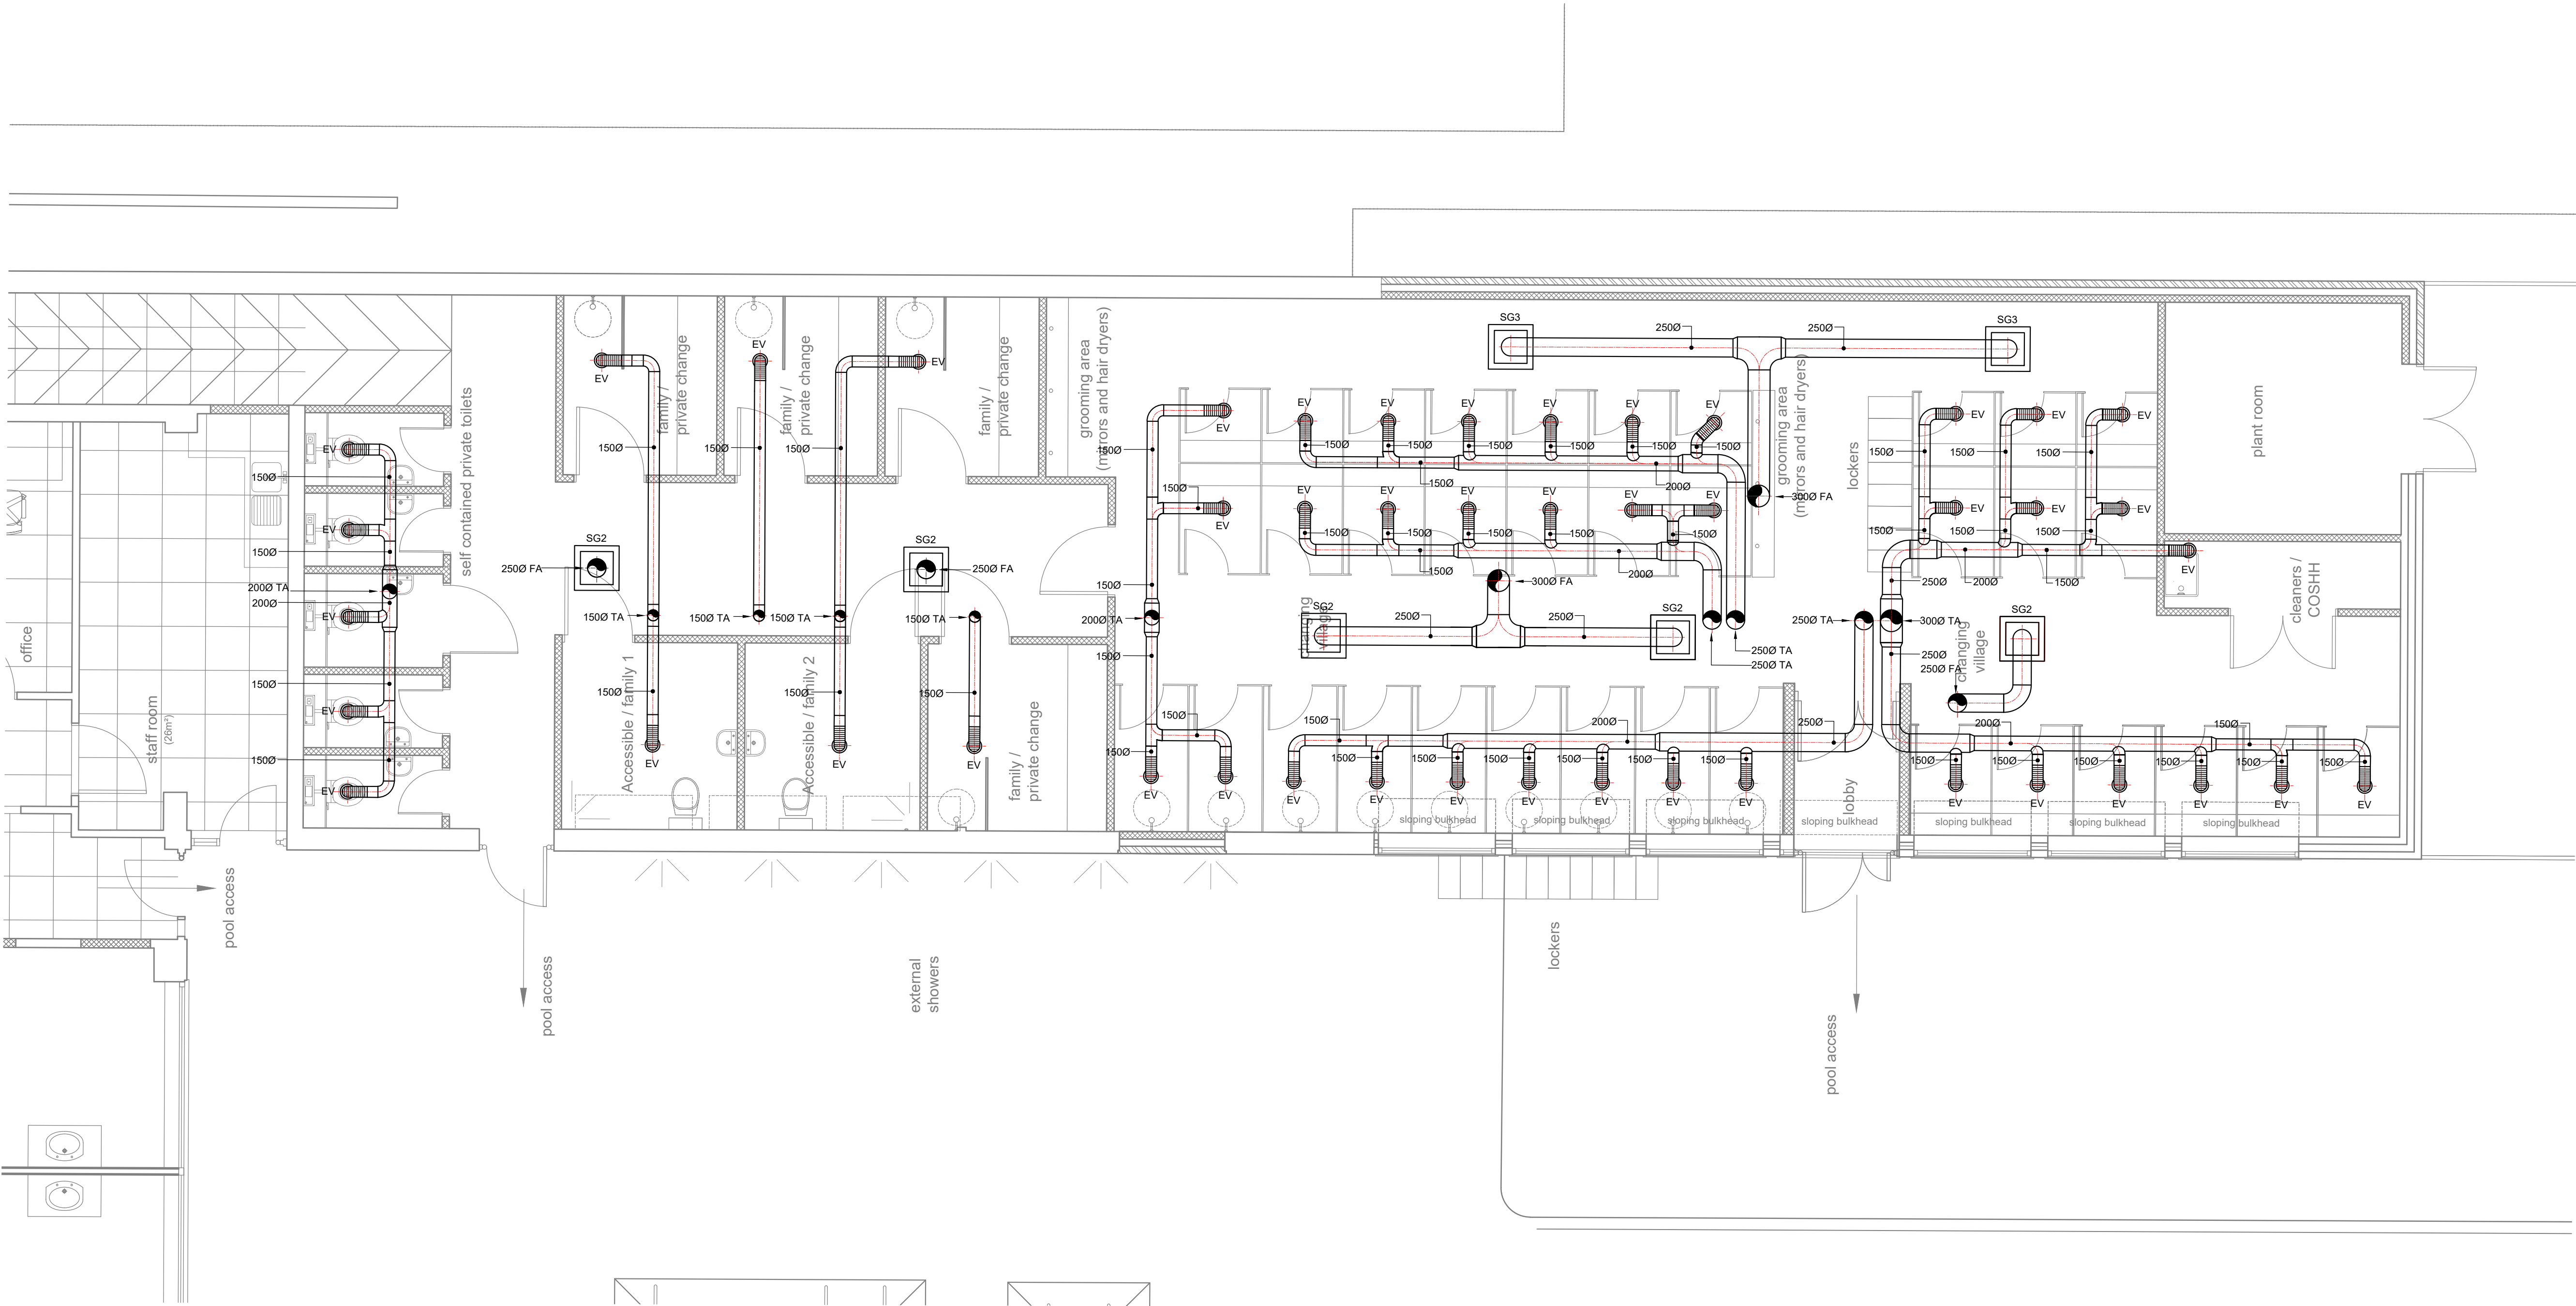

This drawing is not to be scaled. All dimensions to be checked on site and any discrepancies to be reported to PB Design and Consultancy Ltd. All material is produced on behalf of PB Design and Consultancy Ltd. All drawings to be read in conjunction with specification where applicable.

GENERAL NOTES

This drawing to be read in conjunction with the mechanical specification

Do not Scale from this drawing

DRAWING SPECIFIC NOTES

- This drawing to be read in conjunction with schematic drawing 240502-M09 and layout drawing 240502-M08.
- All ductwork within ceiling voids to be insulated.
- Final location of all grilles to be co-ordinated with lighting layout.
- No ductwork penetrations shall be cut through existing wooden roof beams.

LEGEND

- DUCTWORK TO/FROM ABOVE
- SPIRAL DUCTWORK
- FLEXIBLE DUCTWORK
- SG SUPPLY GRILLE
- EV EXTRACT VALVE
- TA TO ABOVE
- FA FROM ABOVE

T01	11.09.24	Tender Issue
Rev	Date	Description

PB Design and Consultancy Ltd
Woodside Cottage, Wood Lane, Renhold, Bedford, MK41 0LT
Tel: 01772 263194
e-mail: peter@pbdesignltd.co.uk

CLIENT

Ware Town Council
The Priory
High Street, Ware
Hertfordshire.
SG12 9AL

PROJECT

Ware Priory Lido
Priory Street, Ware
Hertfordshire.
SG12 0DE
Proposed Extension and Refurbishment

PROJECT NUMBER 240502

DRAWING TITLE

Proposed Mechanical Ventilation Services
Plan 2 of 2

DATE	October 2024	SCALE	1:50
DRAWN BY	PM	CHK	PM
DRAWING No	240502-M07	REV	T01