



service plan - existing fire & security

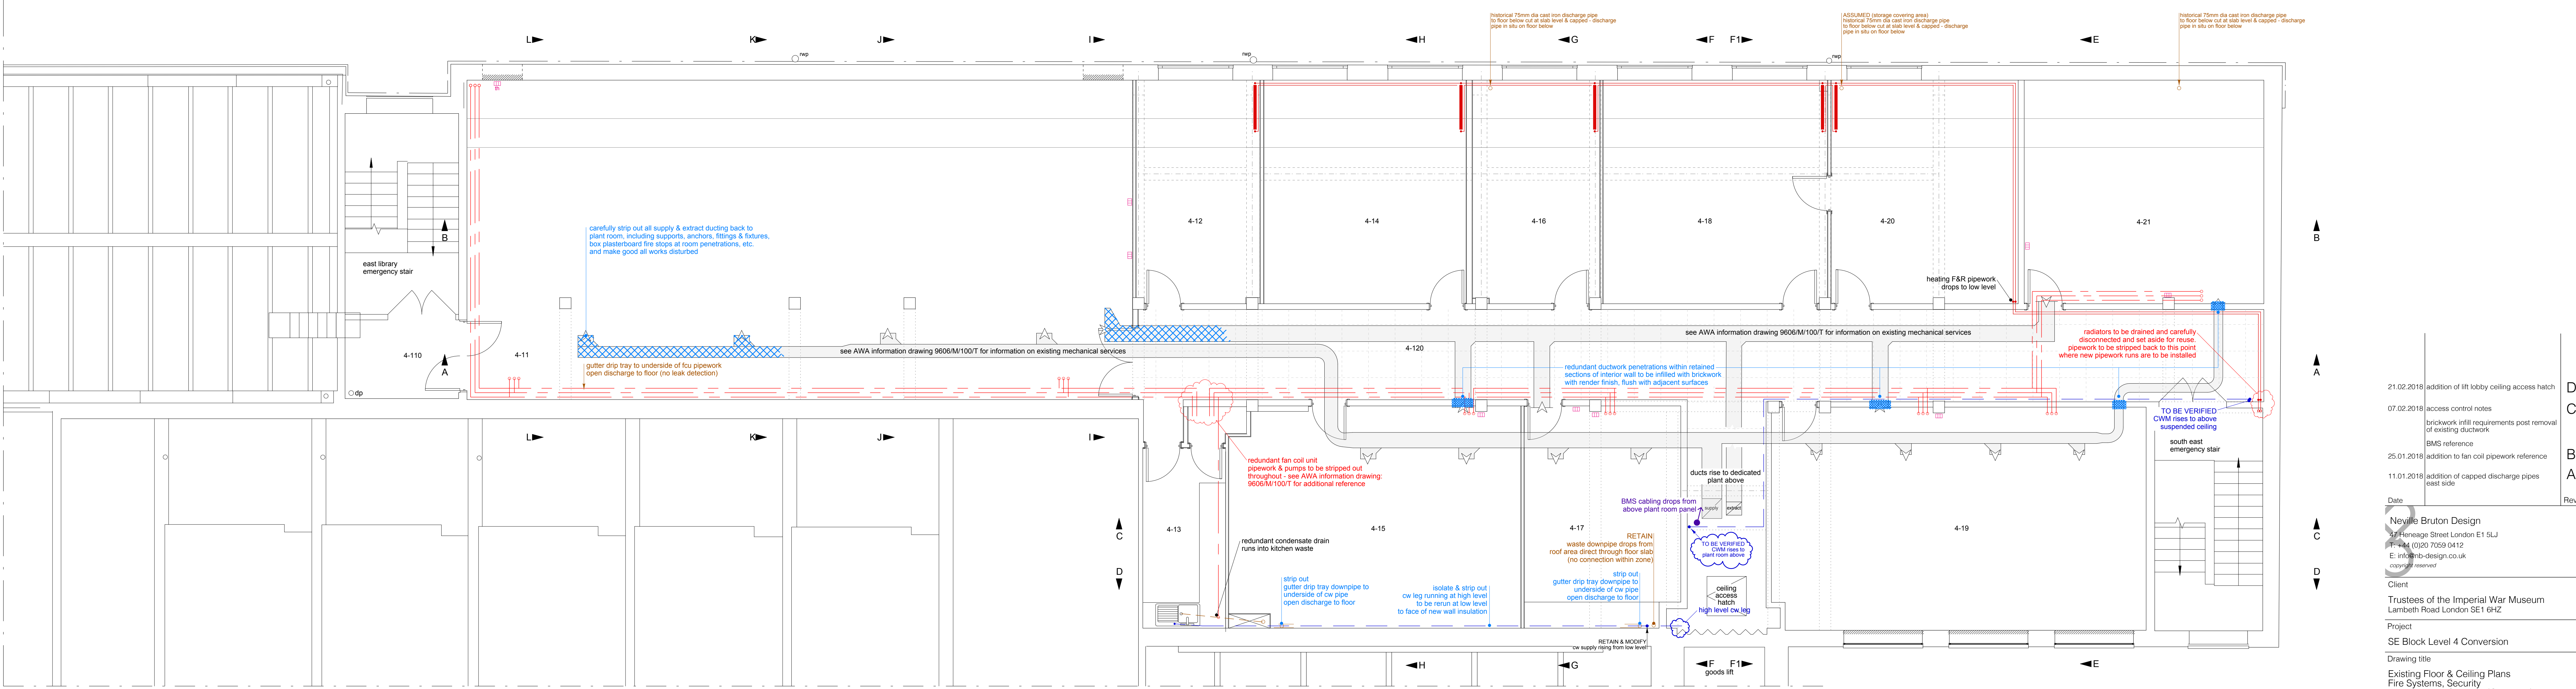

service plan - existing mechanical - AHU configuration - heating - plumbing

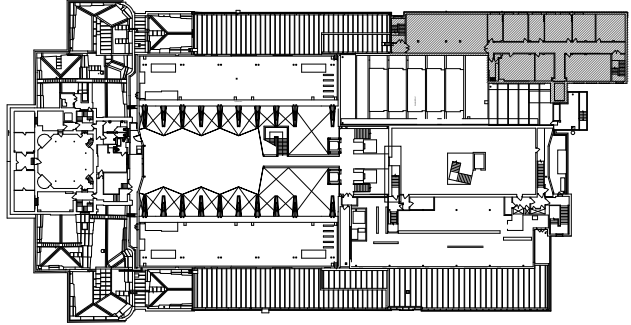

For sectional elevations see drawing:
IWM-LRL4-005
This drawing contains extracts from
RECORD INFORMATION referenced from the below
listed drawings:
Imperial War Museums:
IWM-MD-4-001 Rev A Floor Layout
IWM-FS-FAL-4-002 Fire Alarm Layout
Alan Baxter Associates:
1996 Historical structural alteration drawings:
C734/30/01 to C734/30/10
AWA Building Services Consultants:
1996 Historical Modifications to Mechanical Services
9606/M/100/T
UKAE
Speaker Locations and Cable Routes Level 4
3005 Rev D
Nicasayah
Level E Security Layout (Complete Floor)
LAM-E-S-005_RD (04.07)

door	door locking (general)
d 4-110a	access control & door contact alarm
d 4-110	none
d 4-111	none - chubb NIS
d 4-112	none
d 4-113	none - chubb NIS
d 4-114	none
d 4-115	access control & door contact alarm
d 4-116	none
d 4-117	none
d 4-118	none
d 4-119	none
d 4-120	none
d 4-201	none
d 4-21	access control
d 4-211	access control lock
d 4-212	digital & door contact alarm

- Legend
- (S) smoke head
 - (B) break glass
 - (IO) input/output interface module
 - (E) CO2 extinguisher
 - (P) PAVA speaker
 - (N) number refers to circuit
 - (A) access control board
 - (M) access control power supply
 - (R) access control reader
 - (L) electronic lock
 - (D) access control door release
 - (G) emergency break glass door release
 - (C) door contact
 - (E) access control electromagnet
 - (D) digital lock
 - (M) motion detector
 - (C) CCTV camera

- historical redundant fan coil unit pipework & condensate drain
 - heating flow & return pipework
 - radiator
 - cold water supply
 - wall mounted humidistat
- Note:
service isolation valves not shown on this drawing

21.02.2016	addition of lift lobby ceiling access hatch	D
07.02.2016	access control notes	C
	brickwork fill requirements post removal of existing ductwork	C
	BMS reference	B
25.01.2016	addition to fan coil pipework reference	A
11.01.2016	addition of capped discharge pipes (east side)	A
Date		Rev

Neylve Bruton Design
17 Henage Street London E1 5LJ
Tel: 020 7359 0412
E: info@nbd-design.co.uk
© 2016 nbd reserved

Client
Trustees of the Imperial War Museum
Lambeth Road London SE1 6HZ

Project
SE Block Level 4 Conversion

Drawing title
Existing Floor & Ceiling Plans
Fire Systems, Security
& Mechanical Services (Generally)

Scale 1:50 @ A0 Date 13.06.2017

DO NOT SCALE FROM THIS DRAWING.
FOR IDENTIFICATION PURPOSES ONLY. NOT FOR CONSTRUCTION.
ALL DIMENSIONS TO BE CHECKED ON SITE AND USED
IN PREFERENCE TO THOSE GIVEN OR SCALED FROM
THIS DRAWING

Drawing N°
IWM-LRL4-004

Revision letter	A	B	C	D					
-----------------	---	---	---	---	--	--	--	--	--

