


### 3. Temporary builder's/Permanent electricity supply housing cont.

#### GRP kiosk specification


GRP kiosks must be mounted on a concrete plinth (as per the brick built specification on page 4), with two customer installed ducts for the network power service cable and the site supply. The housing should be fixed to the plinth with four galvanised 10mm Rawl through bolts screwed to the internal flange. It must also have a mounting board inside for the electrical equipment.

Kiosks are available from a number of suppliers such as Enviro Engineering, meterboxes.co.uk and Kingsley Plastics.

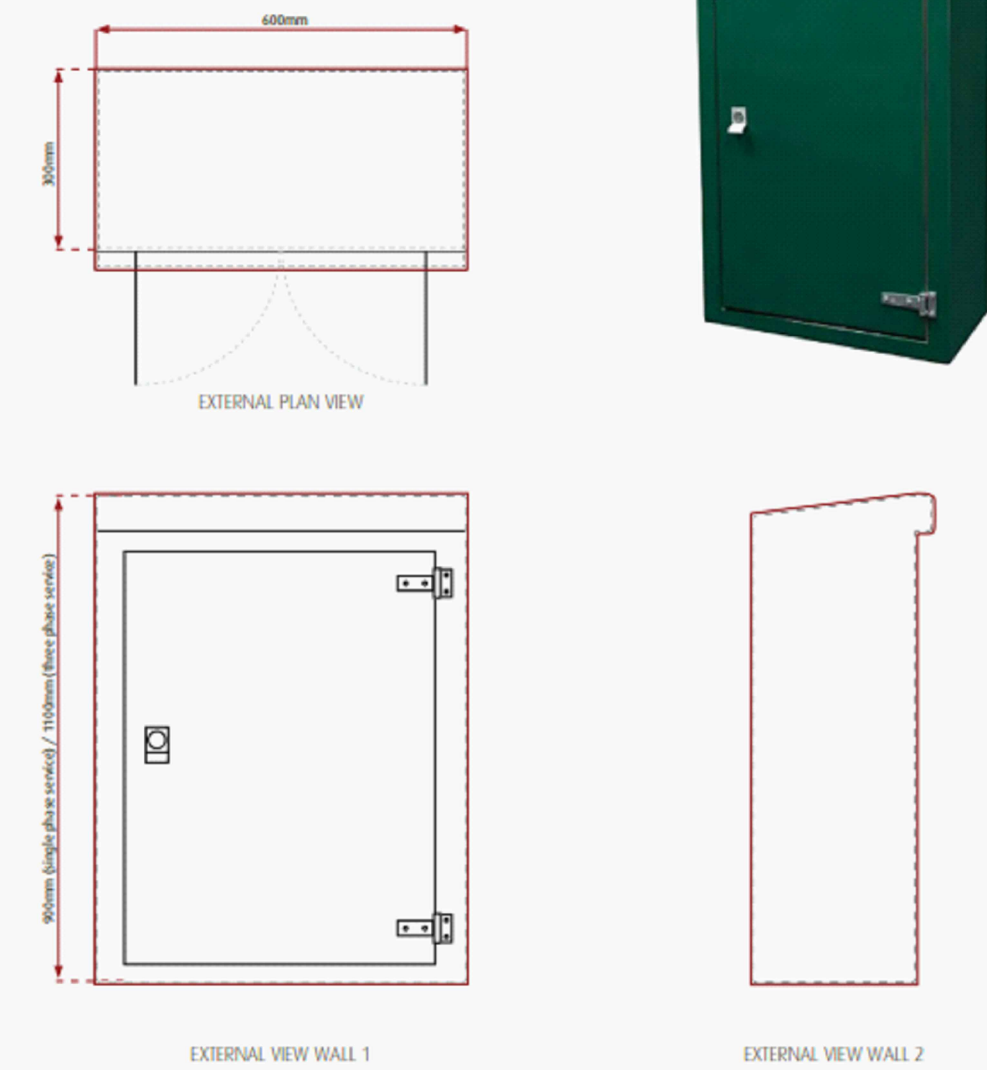

Any questions? Call 0800 029 4280 Mon-Fri, 8.30-5pm

#### UKPN GRP ENCLOSURE DETAIL FOR TEMPORARY BUILDERS SUPPLY

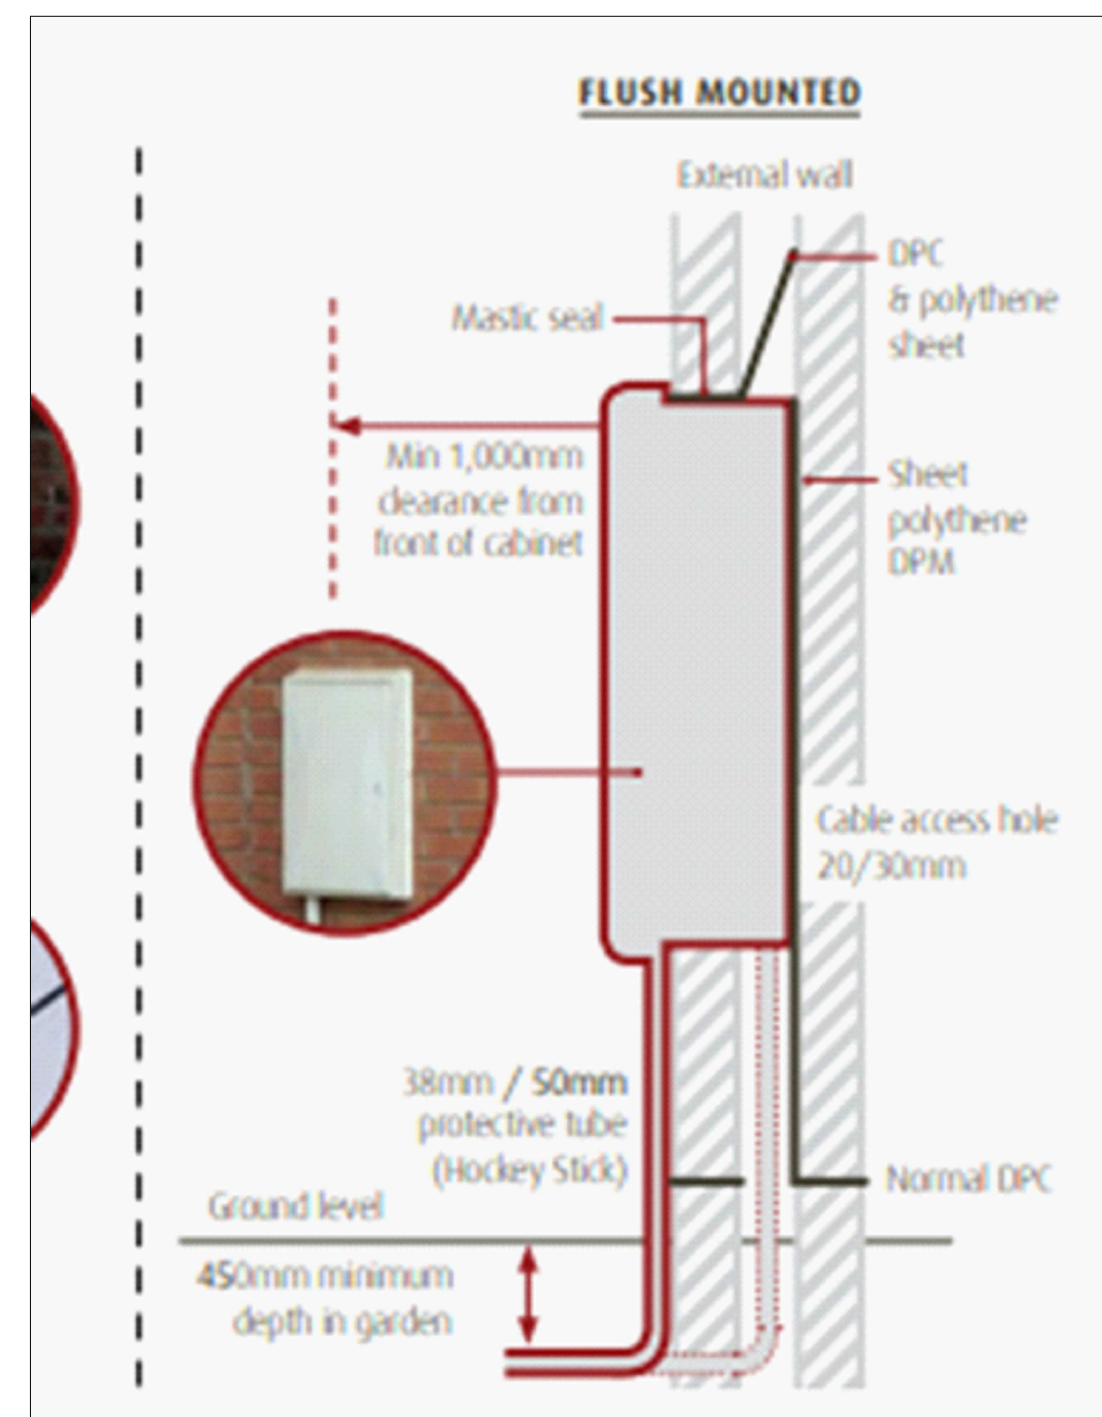

#### UKPN DETAIL FOR FLUSH METER CABINET

Drainage  
Ditch Bank

EMPLOY UKPN TO REMOVE EXISTING INCOMING ELECTRICITY SUPPLIES TO BUILDING (HOUSED WITHIN METER BOX) AND RELOCATE TO CARPARK AS A TEMPORARY BUILDERS SUPPLY. SUPPLY TO BE RELOCATED TO EXTENDED BUILDING AT A LATER DATE.

MAIN CONTRACTOR TO LOCATE AND EXPOSE THREE PHASE SERVICE CABLE AND PROVIDE JOINT TRENCH FOR UKPN

Cable chamber for external lighting and future ELV cables

EMPLOY UKPN TO RELOCATED EXISTING THREE PHASE SUPPLY FROM THE EXISTING BUILDING TO GRP ENCLOSURE FOR TEMPORARY BUILDERS SUPPLY. SUPPLY TO BE RELOCATED BACK TO EXTENDED BUILDING ON COMPLETION. MAIN CONTRACTOR TO PROVIDE GRP ENCLOSURE, BASE AND CABLE TRENCH

APPROXIMATE POSITION OF EXISTING UKPN SERVICE CABLE TO REMAIN

TYPE EX-A  
KINGFISHER VIVA CITY PRO




#### LEGEND:-

- 2 No 100mm Ø black PVC ducts for external lighting and future use. 1 No duct to be expect clear and spare for future ELV services
- 1 No 100mm Ø black PVC duct for external lighting mains voltage cabling.
- 1 No black PVC duct for Incoming UKPN electricity supply cable
- Grey BT PVC duct for Incoming BT Openreach telecoms cable. Duct and chamber sizes to be confirmed with BT Openreach
- 600x600 Cable chamber for external lighting and CCTV cabling
- Cable chamber for incoming BT Openreach services. Size and details to be to BT Openreach specification

EX-A External lighting lantern on 6m meter column.

EX-VF External verifocal CCTV camera

EX External fixed CCTV camera

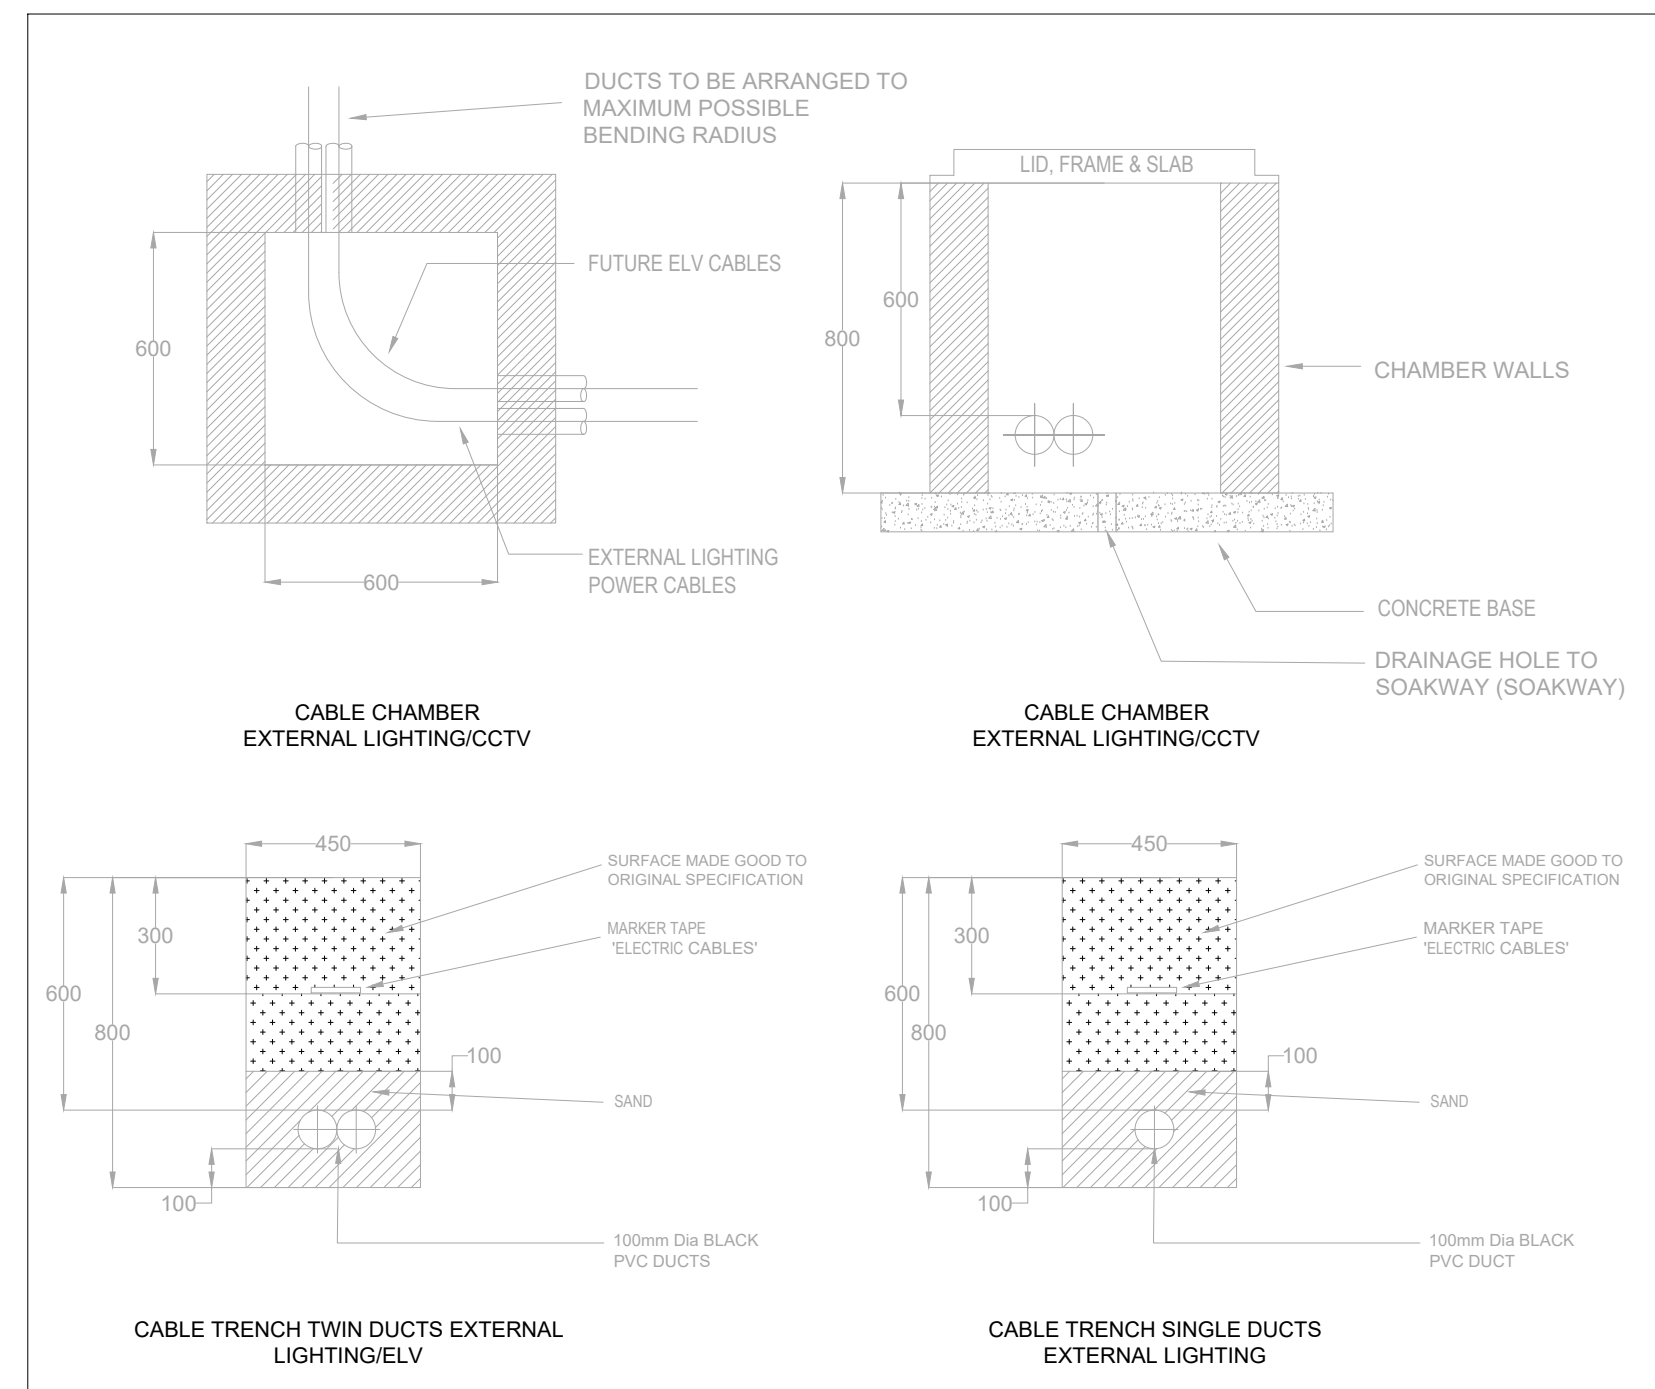

#### NOTES

- DRAWING TO BE READ IN CONJUNCTION WITH THE ELECTRICAL SPECIFICATION AND ALL OTHER ELECTRICAL DRAWINGS
- FOR CABLE TRENCH AND CABLE CHAMBER DETAILS FOR BT OPENREACH AND UKPN CABLES REFER TO UTILITY COMPANIES SPECIFICATION.

B	Revised Tender Issue - updated to suit latest building layout	July 23	NR	AW
A	Tender Issue	July 22	NR	AW
rev.	description	date	drawn	approved

information ☐ approval ☐ tender ☒ contract ☐ construction ☐

#### Axis Mechanical & Electrical Consulting Engineers

No.8 Poplars Court  
Lenton Lane  
Nottingham  
NG7 2RR  
United Kingdom

tel: +44 (0) 115 9791875  
fax: +44 (0) 115 9249179  
email: mail@axisconsult.co.uk  
web: www.axisconsult.co.uk



#### client

SAWTRY PARISH COUNCIL

#### project

GREEN FIELD SPORTS FIELD  
SAWTRY, HUNTINGDON

#### drawing

ELECTRICAL SERVICES  
PROPOSED SITE PLAN SHOWING CCTV, EXTERNAL  
AND INCOMING UTILITY SERVICES.

drawn N.R.	approved A.W.	date JULY 22	scale 1:200@A1
---------------	------------------	-----------------	-------------------

drawing ref. AX1937-E-04 revision B