


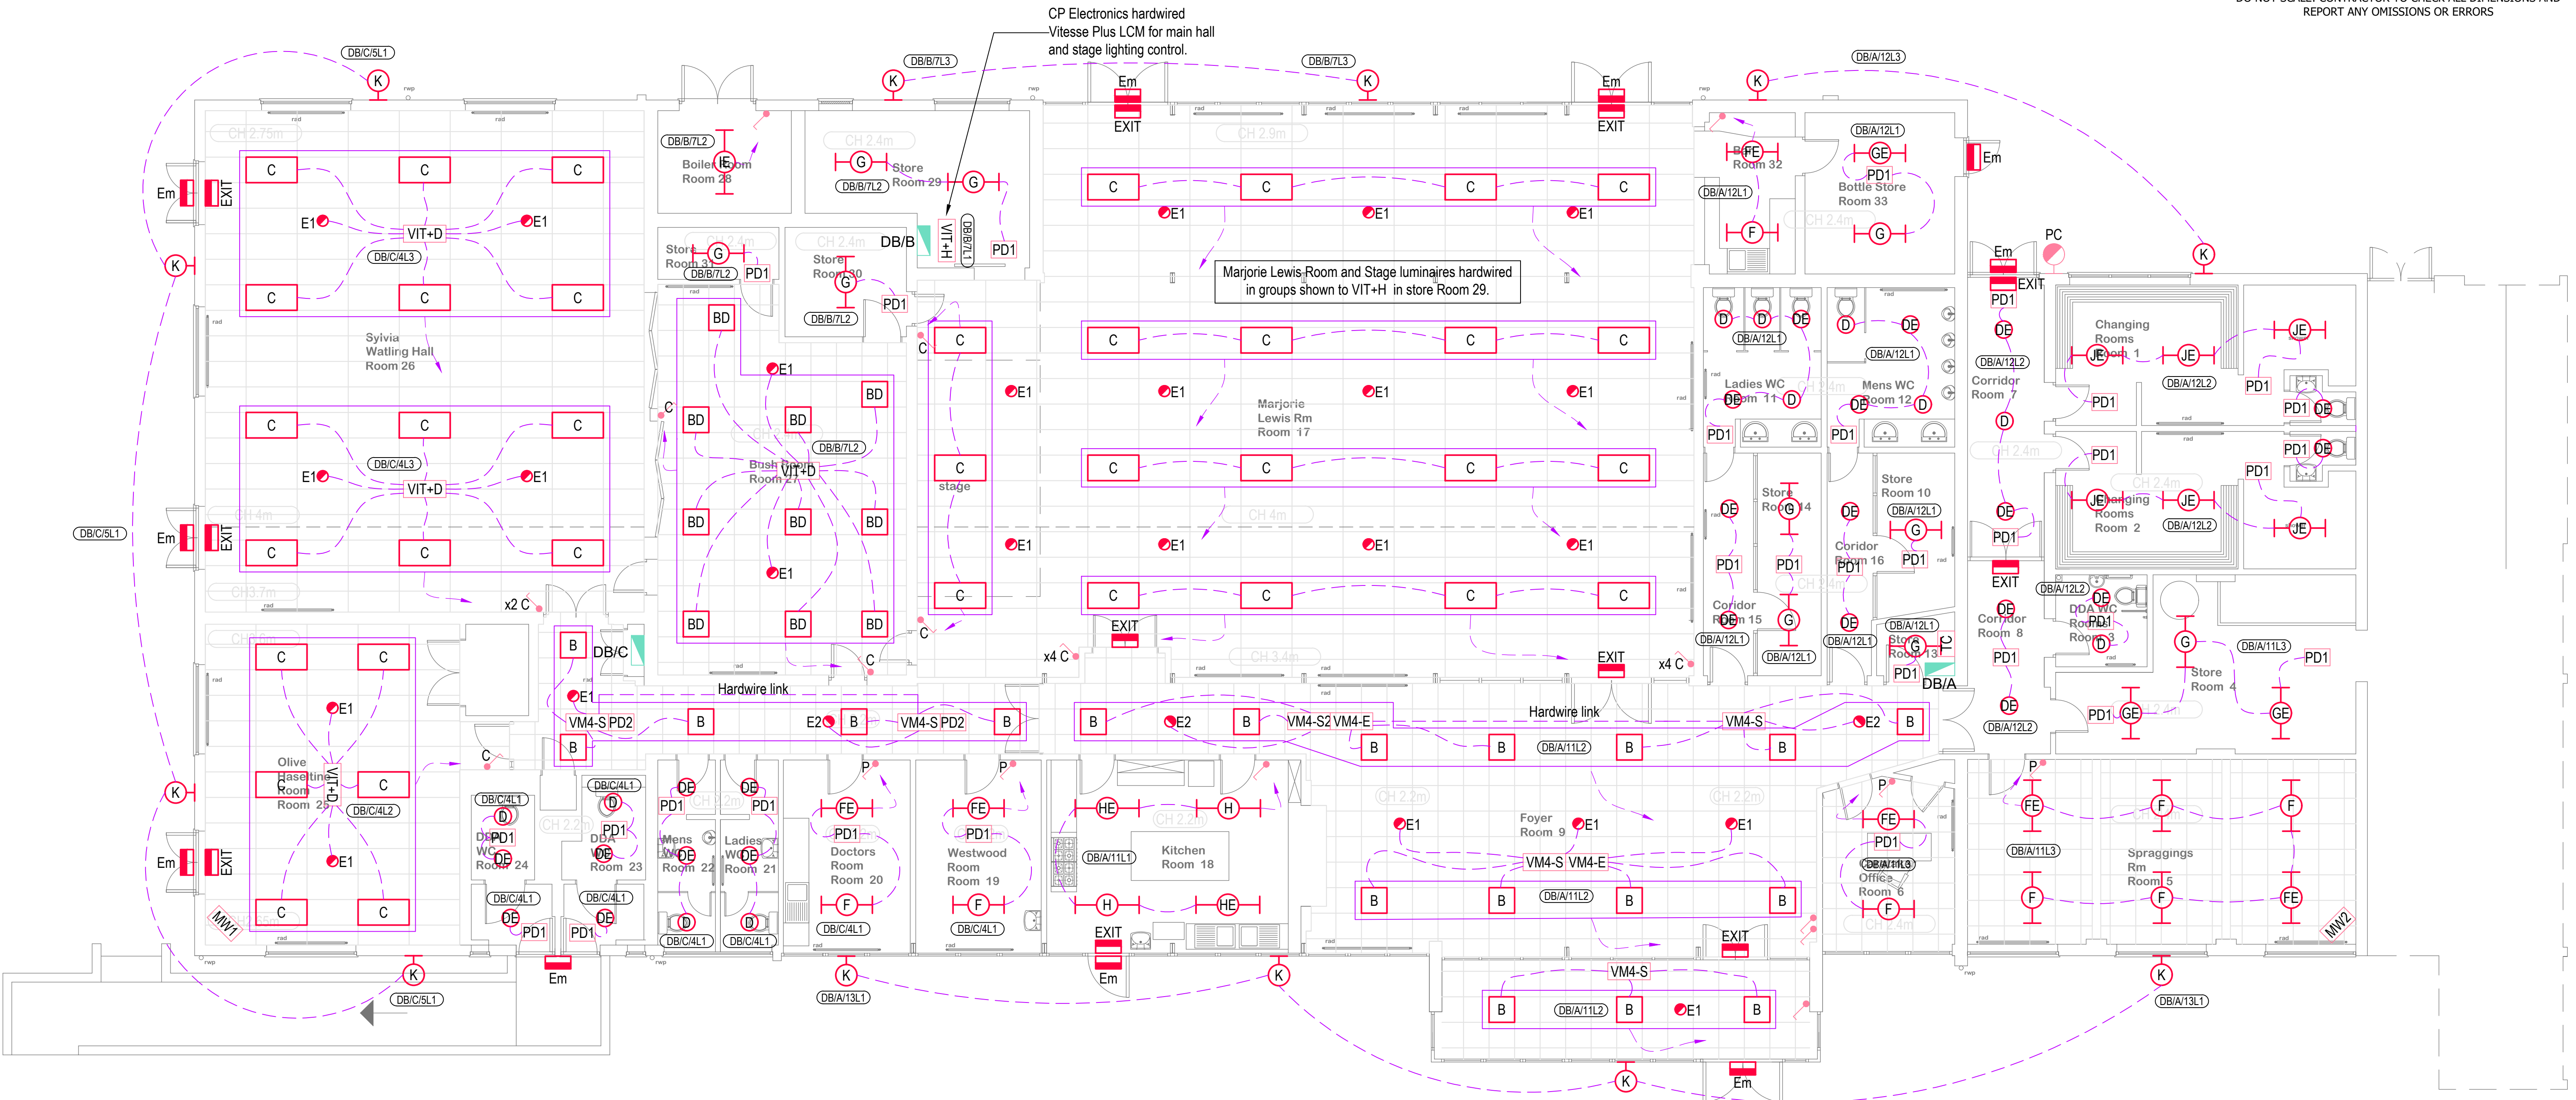

LEGEND & LUMINAIRE SCHEDULE	
REF	DESCRIPTION
A	33w 240mm Ø 4000k LED recessed downlight. As Sylvania Insaver Slim 225 IP44 4100lm 840, ref: 0030309
B	35.6w 600mm x 600mm 4000k LED UGR 19 flat panel. As Sylvania Start Panel, ref: 0042184
BD	35.6w 600mm x 600mm 4000k DALI dimmable LED UGR 19 flat panel. As Sylvania Start Panel, ref: TBC by manufacturer
C	58w 1200mm x 600mm 4000k LED UGR 19 flat panel with DALI dimming. As Sylvania Start Panel UGR19 5500LM 840 DALI, ref: 0061278
D	14w 350mm Ø 4000k LED exterior surface mounted luminaire. As Sylvania Start Surface IP66 1500LM 840 MW SENS IK10 WHT, ref: 0049005
DE	14w 350mm Ø 4000k LED exterior surface mounted luminaire with integral emergency. As Sylvania Start Surface IP66 1500LM 840 MW SENS IK10 WHT, ref: 0049013
E1	Recessed stand-alone emergency spotlight luminaire with area lens. As Sylvania Start Em spot MT NM 3H, ref: 201910160-1
E2	Recessed stand-alone emergency spotlight luminaire with corridor lens. As Sylvania Start Em spot MT NM 3H, ref: 201911038-1
Em	IP65 LED emergency bulkhead luminaire. As Sylvania Start Eco Emergency Bulkhead, ref: 0032004
EXIT	LED emergency exit sign with legend to suit position. As Sylvania Sylsafe range to suit mounting position
F	36W 1218mm x 200mm 4000K LED diffuser luminaire. As Sylvania Deltawing LED40 EB 4K 1200, ref: 0044871
FE	36W 1218mm x 200mm 4000K LED diffuser luminaire with integral emergency. As Sylvania Deltawing LED40 EB 4K 1200, ref: 0044877

LEGEND & LUMINAIRE SCHEDULE	
REF	DESCRIPTION
G	21W 1200mm x 89mm 4000K LED weatherproof luminaire with flat diffuser. As Sylvania Resisto 1200 IP66 2800LM 840, ref: 0010210
GE	21W 1200mm x 89mm 4000K LED weatherproof luminaire with flat diffuser and integral emergency. As Sylvania Resisto 1200 IP66 2800LM 840, ref: 0010218
H	30W 1500mm x 89mm 4000K integrated LED weatherproof luminaire with flat diffuser. As Sylvania Resisto 1500 IP66 4000LM 840, ref: 0010243
HE	30W 1500mm x 89mm 4000K integrated LED weatherproof luminaire with flat diffuser and integral emergency. As Sylvania Resisto 1500 IP66 4000LM 840, ref: 0010253
IE	46W 1500mm x 89mm 4000K integrated LED weatherproof luminaire with flat diffuser and integral emergency. As Sylvania Resisto 1500 HE IP66 7100LM 840, ref: 0010272
JE	25W 1500mm x 89mm 4000K integrated LED weatherproof luminaire with flat diffuser and integral emergency. As Sylvania Resisto 1500 HE IP66 4000LM 840, ref: 0010271
K	23W 3000k LED 200mm x 200mm square wall mounted luminaire with 'T3' optic and anthracite grey finish. As Performance in Lighting 'Mimik 20', ref: 304423
MW1	CP Electronics Vitesse Plus recessed Microwave Detector. Ref: VITP7-MWS3A
MW2	CP Electronics Vitesse Plus surface Microwave Detector. Ref: MWS3A-PRM + MWS3A-DBB
PD1	CP Electronics Surface mounted Vitesse PIR Detector. Ref: EBD5M-PRM
PD2	CP Electronics recessed Vitesse Plus PIR Detector with 3m lead for connection to VM4. Ref: VITM4-EBDSPIR-PRM
VIT+D	CP Electronics Vitesse Plus DALI Dimmable 12-Output LCM. Ref: VITP7-MB-DD

LEGEND & LUMINAIRE SCHEDULE	
REF	DESCRIPTION
VIT+H	CP Electronics Vitesse Plus DALI Hardwired LCM in enclosure. Ref: VITP7-HW-LCM6-BDD
VM4-S	CP Electronics Vitesse Modular 4, 4-output starter unit. Ref: VITM4-S
VM4-S2	CP Electronics Vitesse Modular 4, 2-output starter unit. Ref: VITM4-S2
VM4-E	CP Electronics Vitesse Modular 4, 4-output extender unit. Ref: VITM4-E
	1-Way Switch
P	'Push to Make' momentary action switch.
C	'Centre Biased' retractive switch.
	Hard wired link between LCM's to operate together.
TC	External Lighting Time Clock
PC	External Lighting Photocell

TENDER ISSUE

T2	External lighting added, updated to suit comments and circuit references added	KLP	CJP	ALH	Aug 21
T1	Tender Issue	KLP	CJP	ALH	Jul 21
	Preliminary Issue	KLP	CJP	ALH	Jul 21
REV	DESCRIPTION	BY	CHK	APP	DATE

Client
HELLEDSON PARISH COUNCIL



GREENRIDGE, LITTLEFIELD, DEREHAM, NORFOLK NR19 1BQ
Tel/ Fax: 01362 652704 Mobile: 07789 815485
email: andrew@alhdesign.co.uk

Project:
HELLEDSON COMMUNITY CENTRE
WOODVIEW ROAD, HELLEDSON
NORFOLK, NR6 5SR

Drawing Title:
ELECTRICAL SERVICES
LIGHTING LAYOUT

Scale @ 1:75	Drawn KLP	Date Jul 21	Checked CJP	Date Jul 21	Approved ALH	Date Jul 21
Project No. 21027	Type EL	Drawing No. 63-01	Revision T2			