


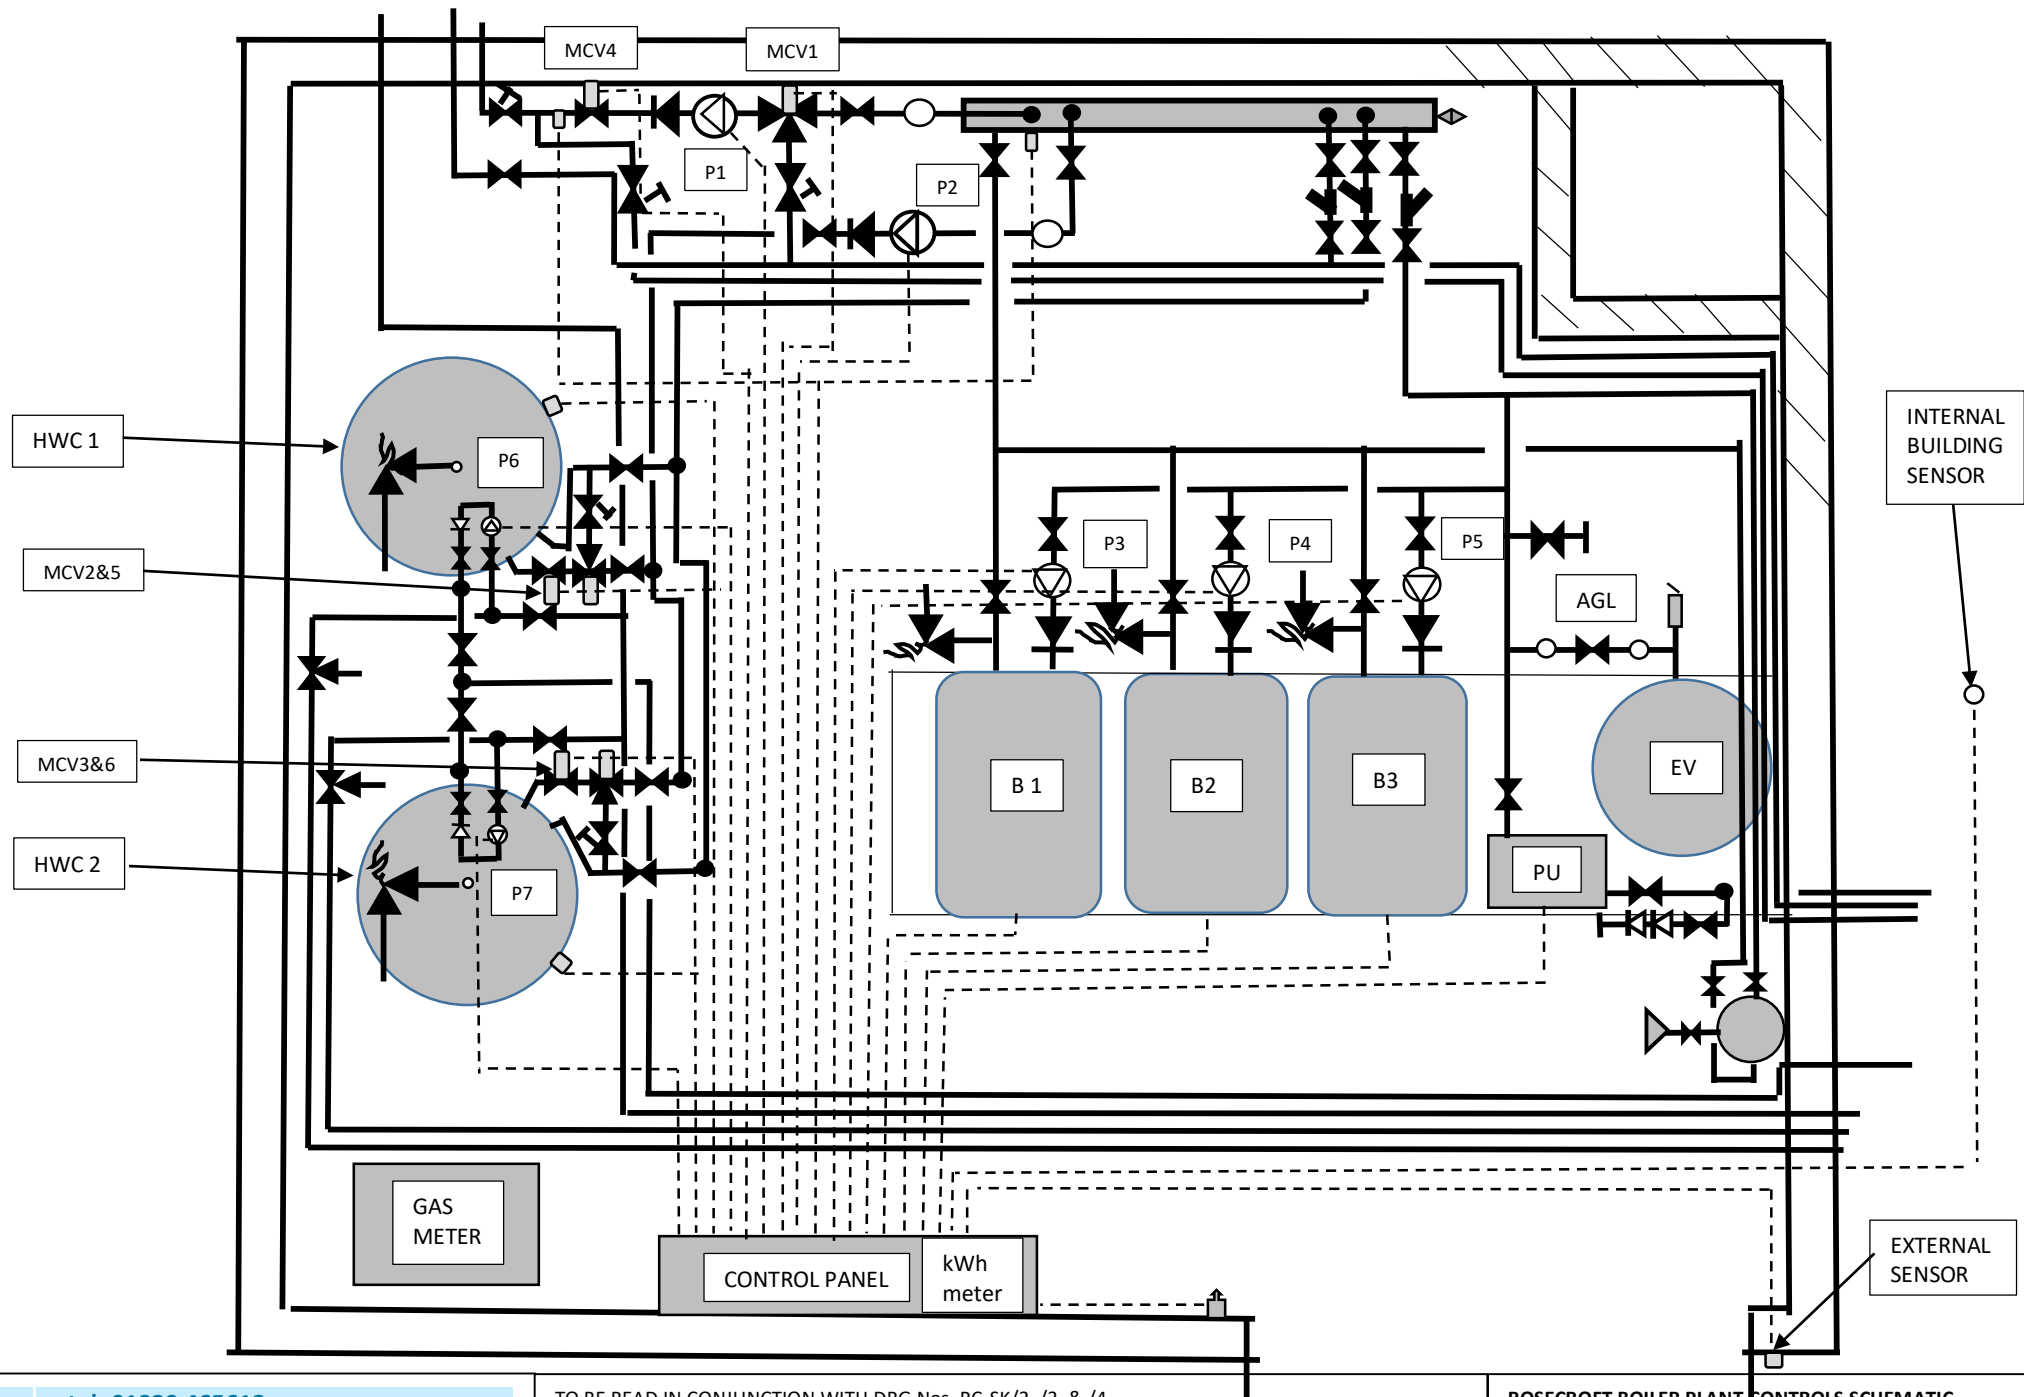

DCHC

tel: 01920 465618
fax: 01920 465618
email: derek.c.howes@btinternet.com

TO BE READ IN CONJUNCTION WITH DRG Nos. RC-SK/2, /3, & /4

ALL DIMENSIONS ARE STATED IN mm

ROSECROFT BOILER PLANT CONTROLS SCHEMATIC
SCALE : APRX 1:25 @ A4
DATE : FEB2018
DRG No. RC-SK/4/T