


PROPOSED INDICATIVE VENTILATION CHANGES

Ground Floor Plan

Project: Environment Agency, Leeds

DRG Ref: M02

Scale: NTS

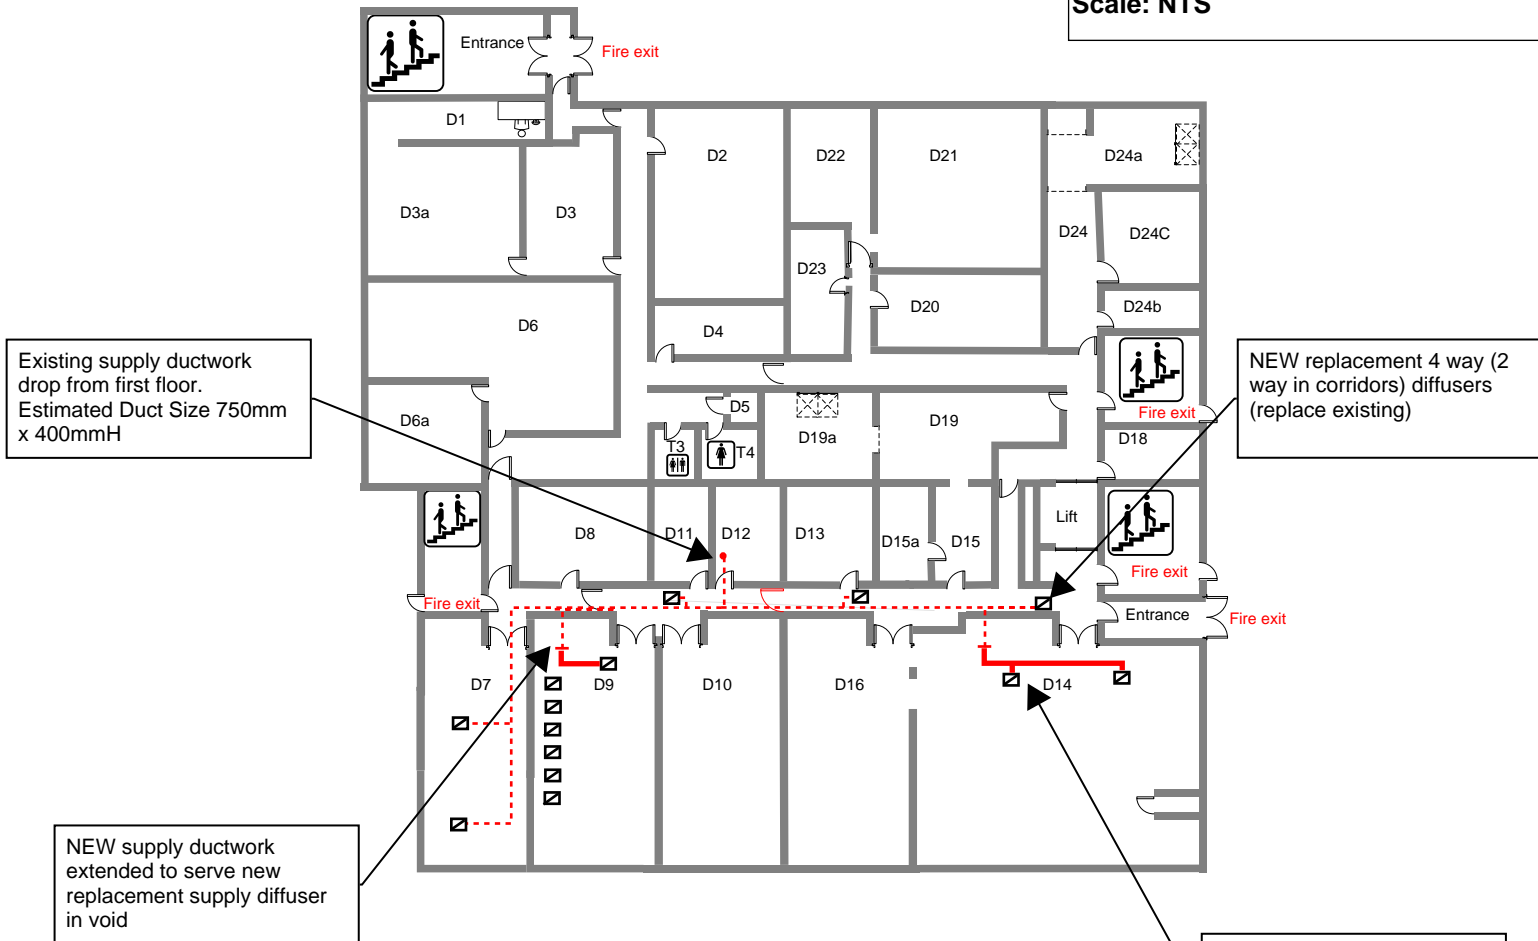

KEY

- Existing Extract Ductwork retained (indicative only)
- Existing Supply Ductwork retained (indicative only)
- /// Strip Out Works (indicative only)
- NEW Extract Ductwork retained (indicative only)
- NEW Supply Ductwork retained (indicative only)
- Existing Supply Grille to be replaced with NEW 4 Way Diffuser c/w OBD (indicative only)
- Existing Extract Grille to be replaced with NEW Eggcrate Grille c/w OBD (indicative only)