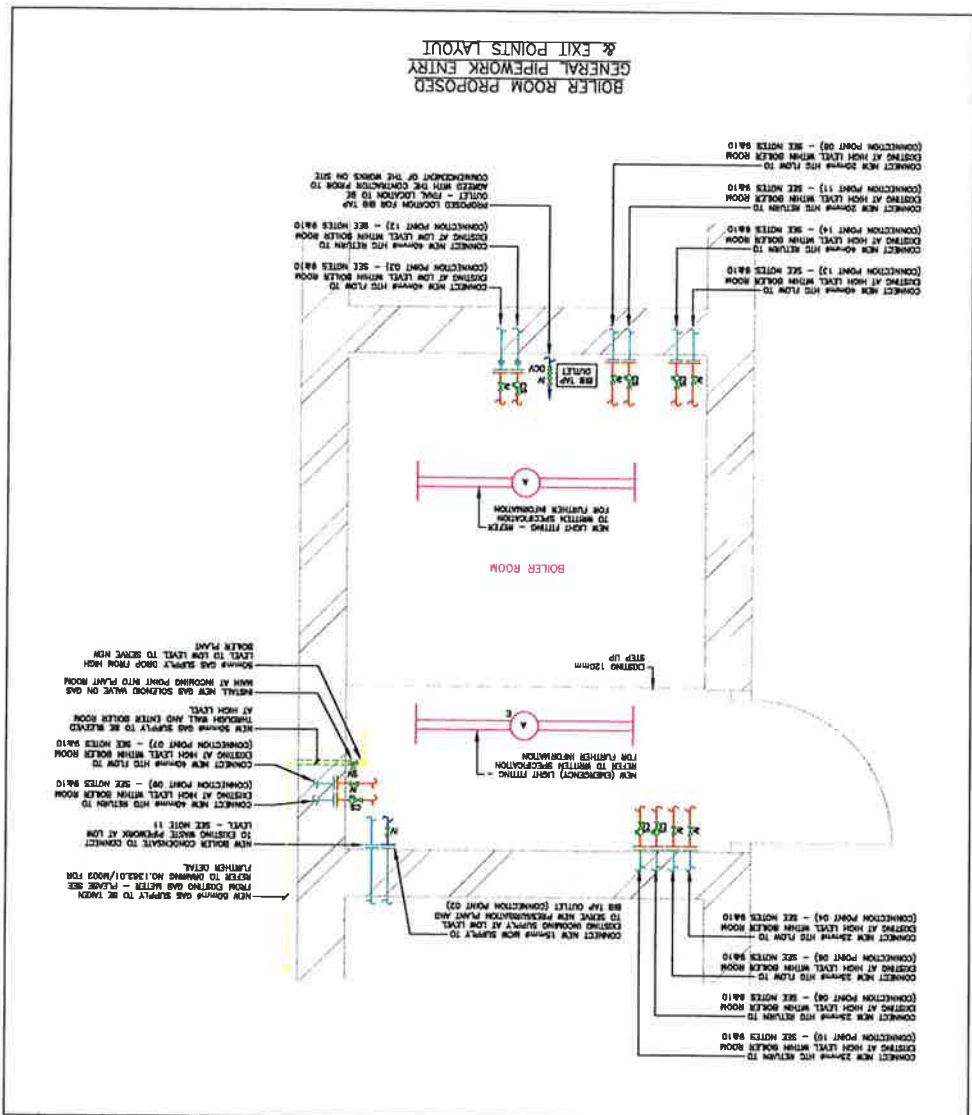



[illegible]


	WOKINGHAM TOWN COUNCIL BOILER REPLACEMENT SCHEME
PROPOSED BOILER ROOM SCHEMATIC	

REV	DATE	AMENDMENTS	
1	20.09.18		

psb Consulting
(Oxford) Ltd

2015-2016
 2017-2018
 2019-2020
 2535-2536
 2537-2

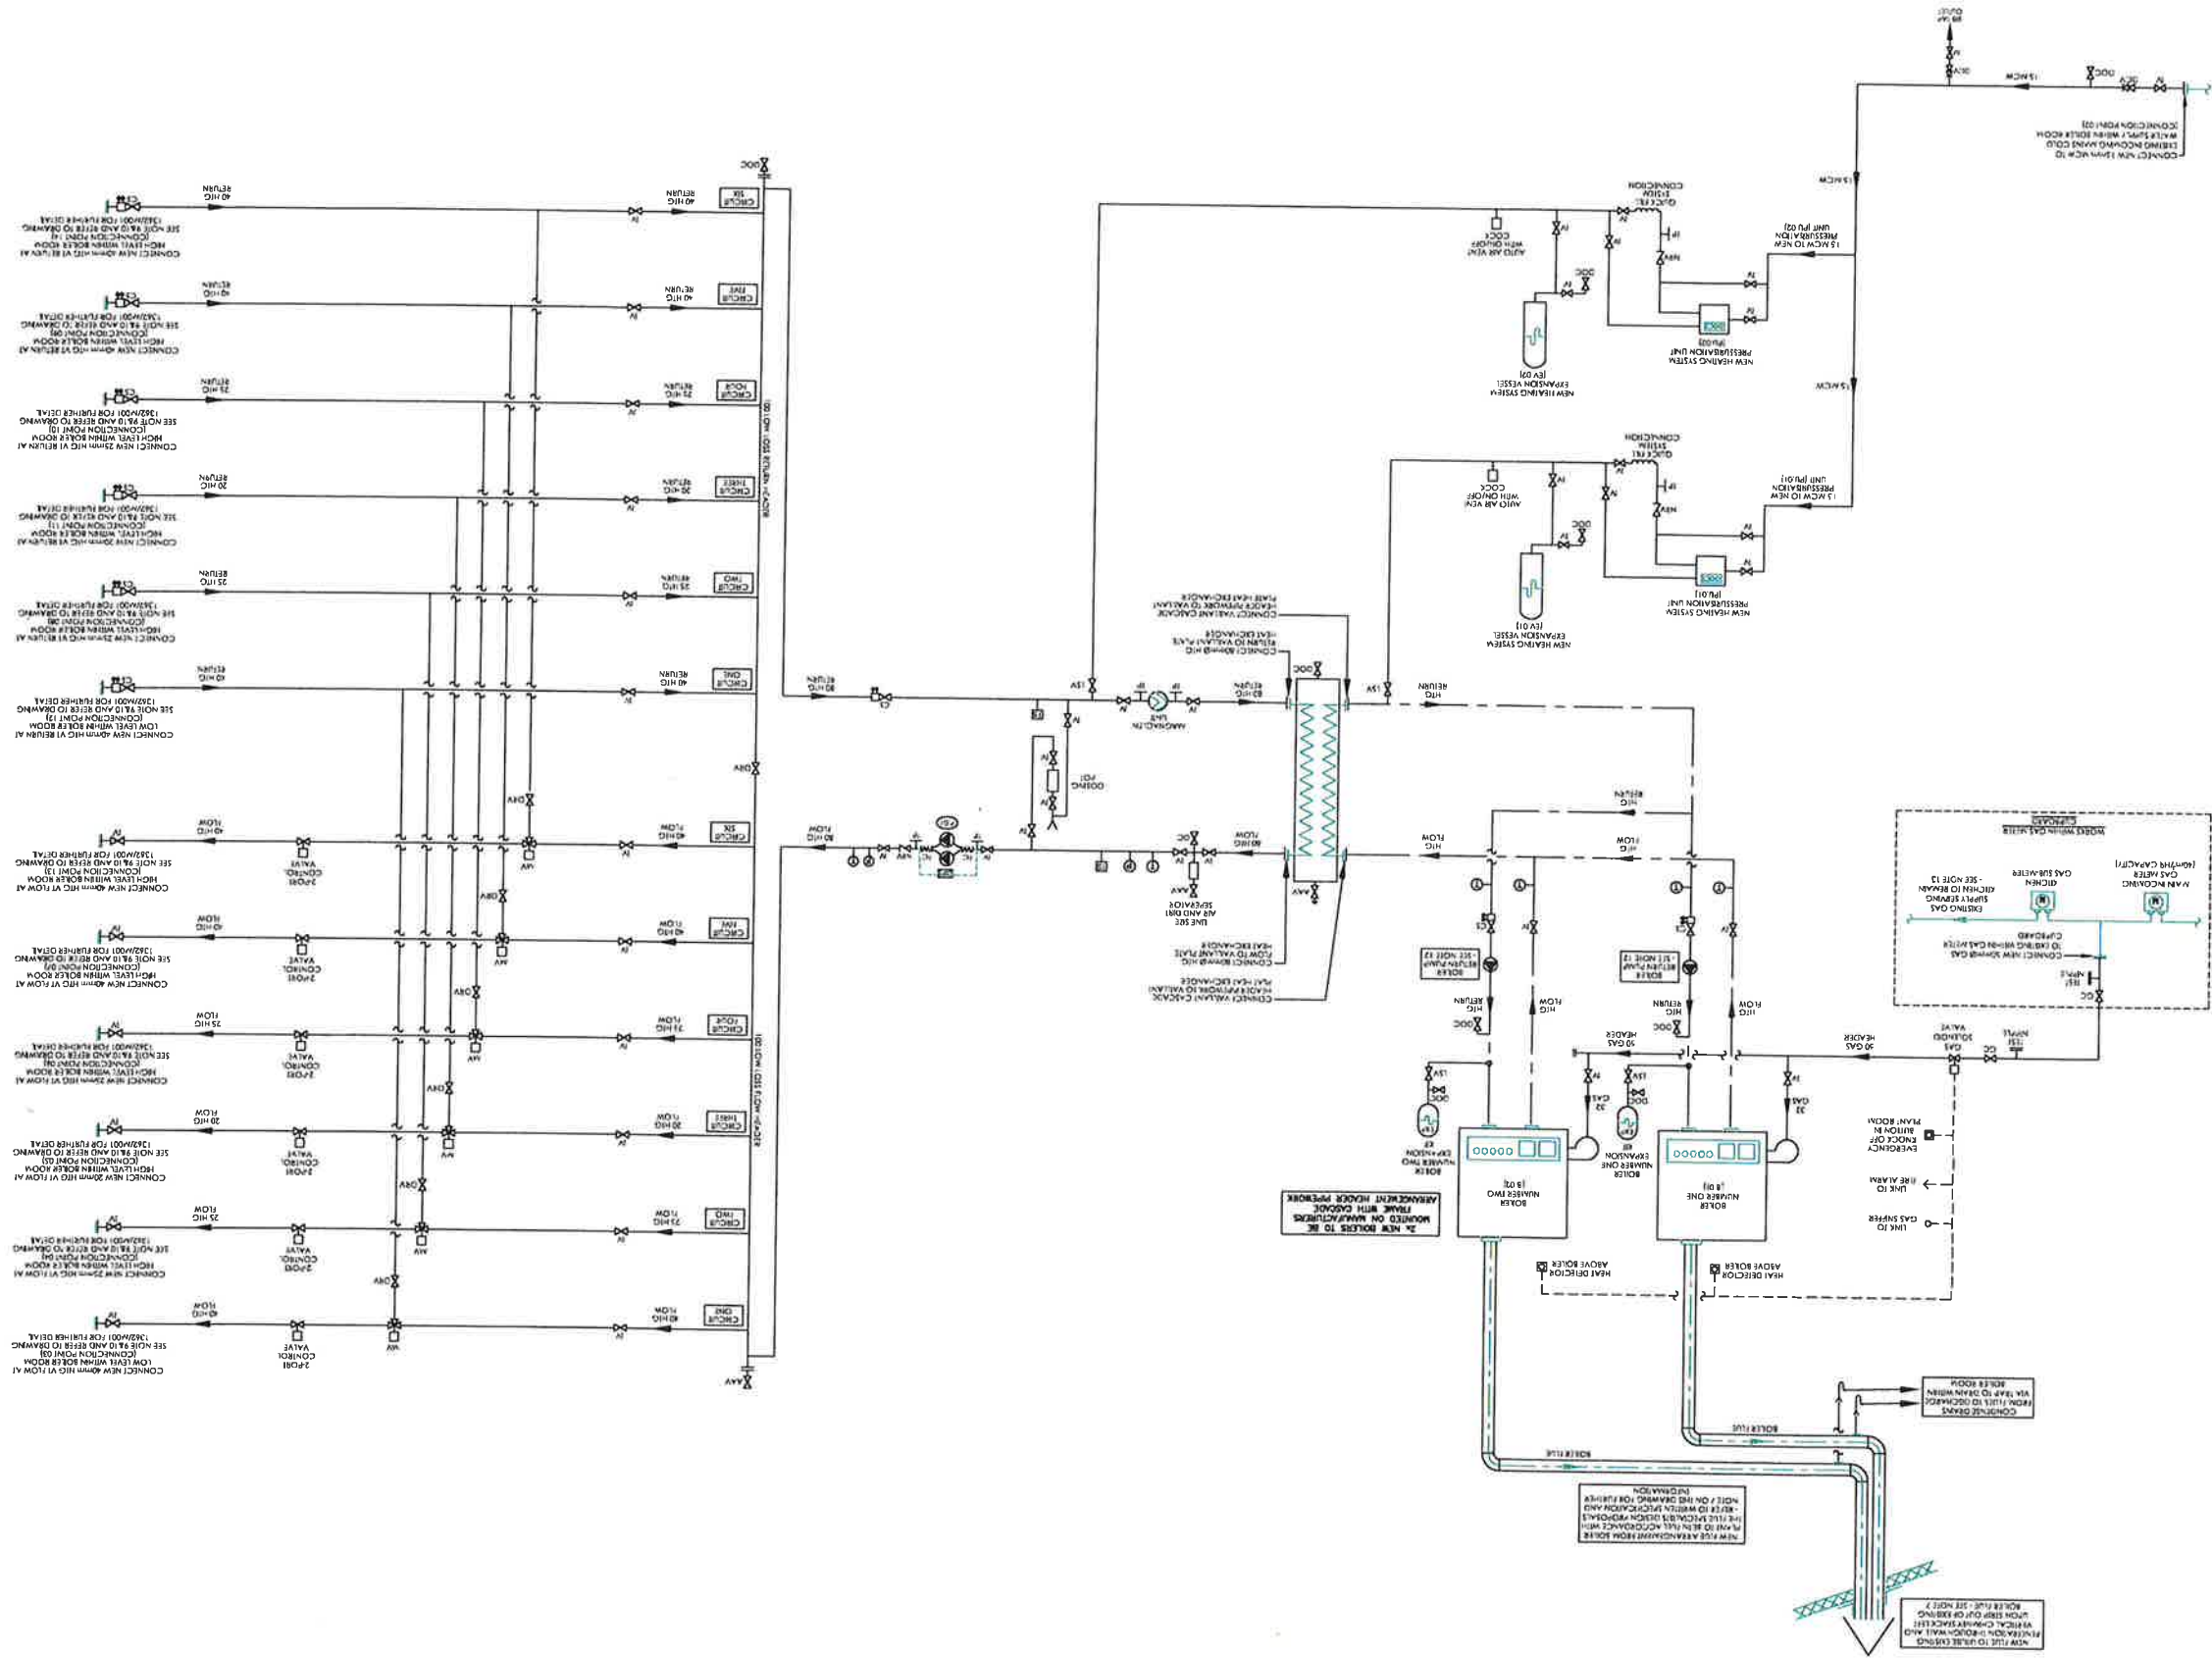

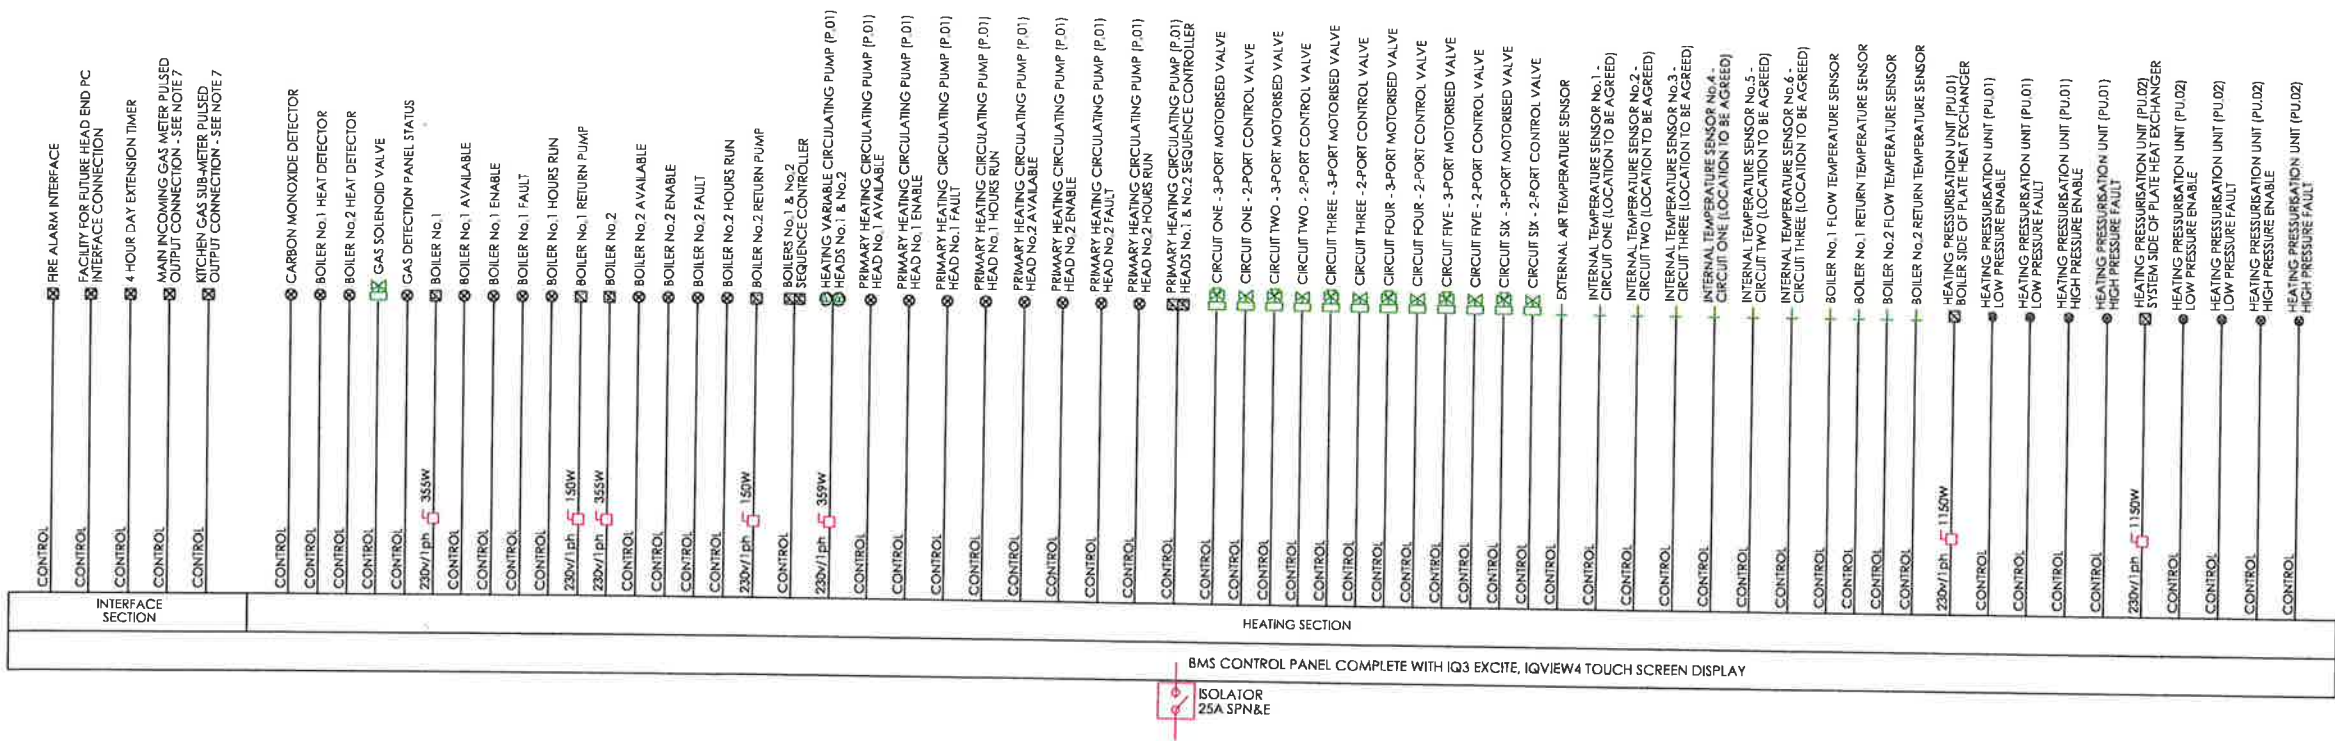

- NOTES:
1. DO NOT SCALE FROM THIS DRAWING.
 2. THE CONTRACTOR IS TO VERIFY ALL DIMENSIONS, TOLERANCES, AND REFERENCES ON SITE PRIOR TO COMMENCEMENT OF THE WORKS.
 3. THIS DRAWING IS TO BE READ IN CONJUNCTION WITH THE SPECIFICATION AND ALL OTHER PROJECT DESIGN DOCUMENTATION.
 4. FINAL LOCATIONS OF ALL THERMOSTATS AND SENSORS ARE TO BE AGREED ON SITE PRIOR TO COMMENCEMENT OF THE WORKS.
 5. THE CONTRACTOR IS TO CONSULT THE ASBESTOS R&D SURVEY REPORT COMMISSIONED FOR THIS PROJECT AND ANY OTHER AVAILABLE ASBESTOS RELATED DOCUMENTATION PRIOR TO COMMENCEMENT OF THE WORKS ON SITE.
 6. THE CONTRACTOR IS TO CONFIRM ALL ELECTRICAL LOADS TO THE BMS PANEL MANUFACTURER AT THE TIME OF ORDERING THE PANEL.
 7. PULSED OUTPUT CONNECTIONS TO EXISTING GAS METERS ARE TO BE PROVIDED AS REQUIRED AND AS EXISTING PROVISION GIVEN BY CURRENT GAS METER INSTALLATIONS.

T	20.09.18	TENDER ISSUE	PSB
REV	DATE	AMMENDMENTS	APP

SUITE 4 HERSCHMAN HOUSE
5 EAST ST HELEN STREET
ABINGDON
OXFORDSHIRE
OX14 3EG
TEL: 01235 428425
EMAIL: info@psbconsulting.co.uk
WWW: psbconsulting.co.uk

CLIENT

Wokingham Town Council

PROJECT

WOKINGHAM TOWN HALL
BOILER REPLACEMENT SCHEME

PROPOSED BMS AUTOMATIC
CONTROLS SCHEMATIC

DRAWING NUMBER: 1362.01/M003/1

SCALE	SZE	DWN	CKD	APP	DATE	REV
NIS	A1	PS	J2	PS	20.09.2018	1