


TYWYN/ABERDYFI CRS

FORMER FIRE STATION - FRANKWELL STREET

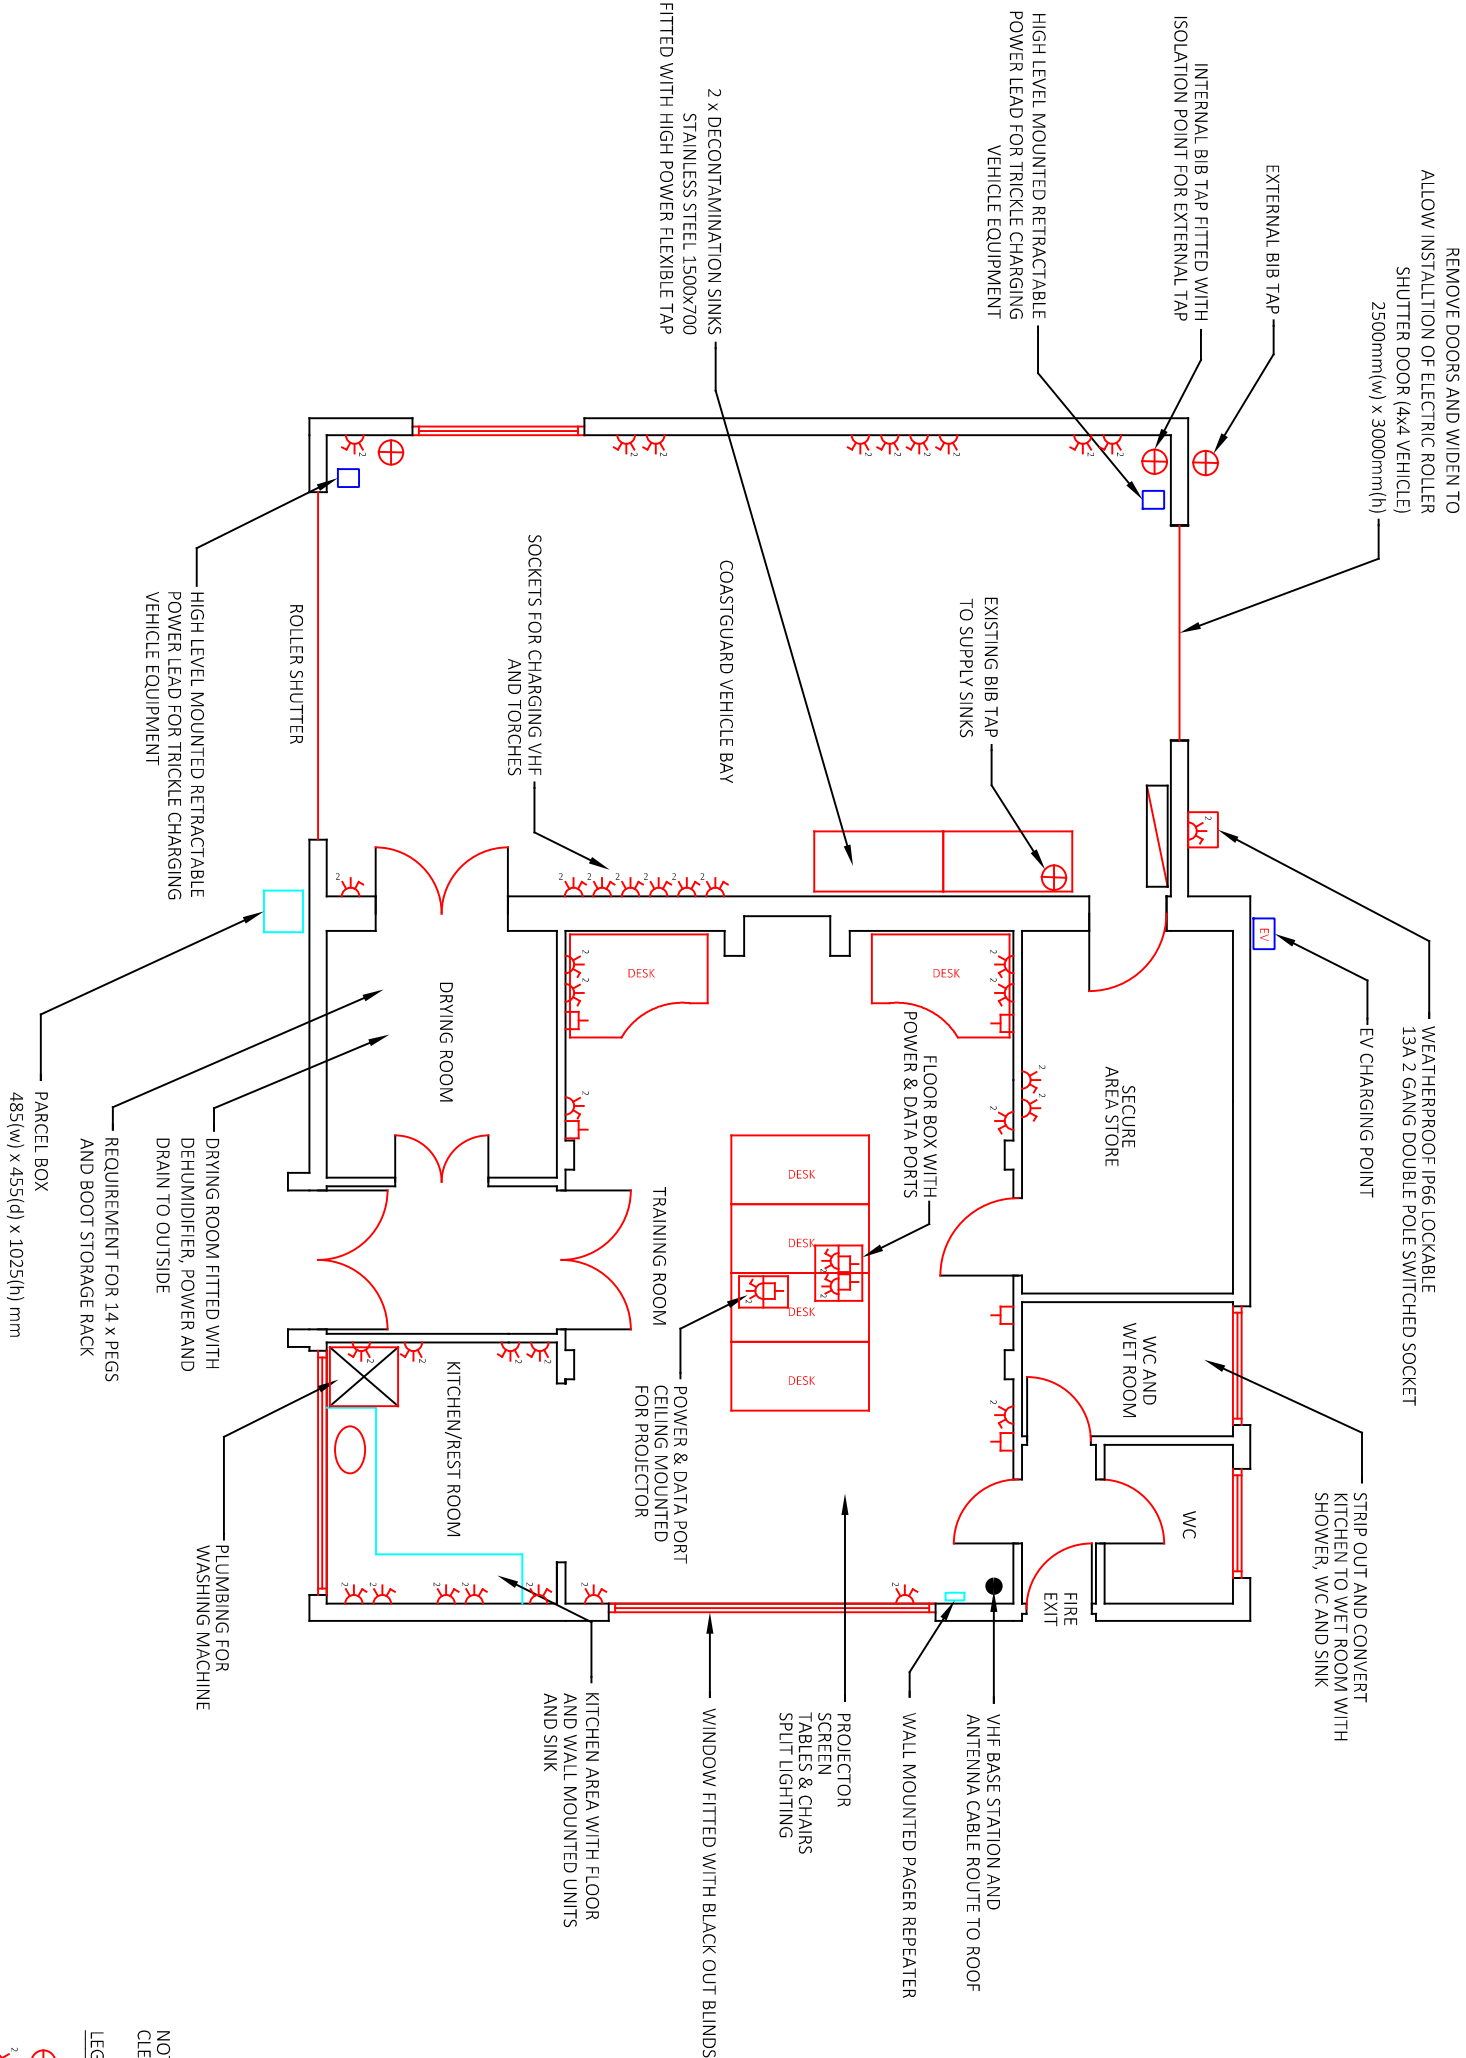

NOTES:
CLERESTORY WINDOWS AND SKYLIGHTS OMITTED FOR CLARITY

LEGEND

- ⊕ BIB TAP
- ⌘ DOUBLE SOCKET
- ⌚ 2 GANG RJ45 SOCKET

FLOOR PLAN: PROPOSED FIXTURES & FITTINGS

SCALE 1:100