



## 4. Operations

A4 Scale: 1:15,000

Forest District:	North England	Contract Type:	Eng. - Service - FM Maintenance - Vegetation Control
Contract Name:	grizedale planting beatup	Prepared By:	Joe Daniels
Contract No:	FEE/0467	Date Prepared:	23/10/2017
Framework/ Service Contract:		Contract Manager:	Joe Daniels
Extent Name:	Claife	Contract Status:	Open

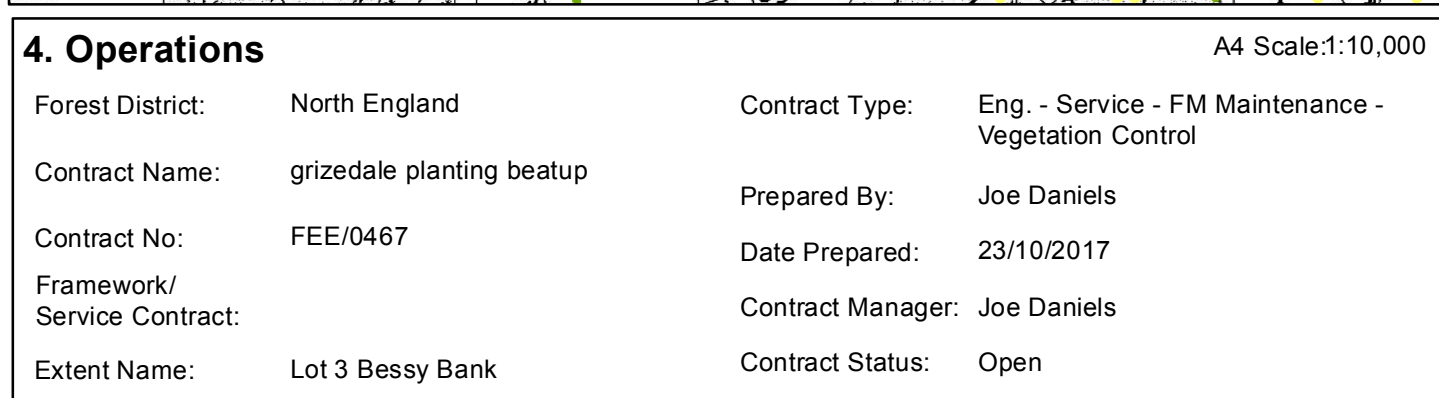


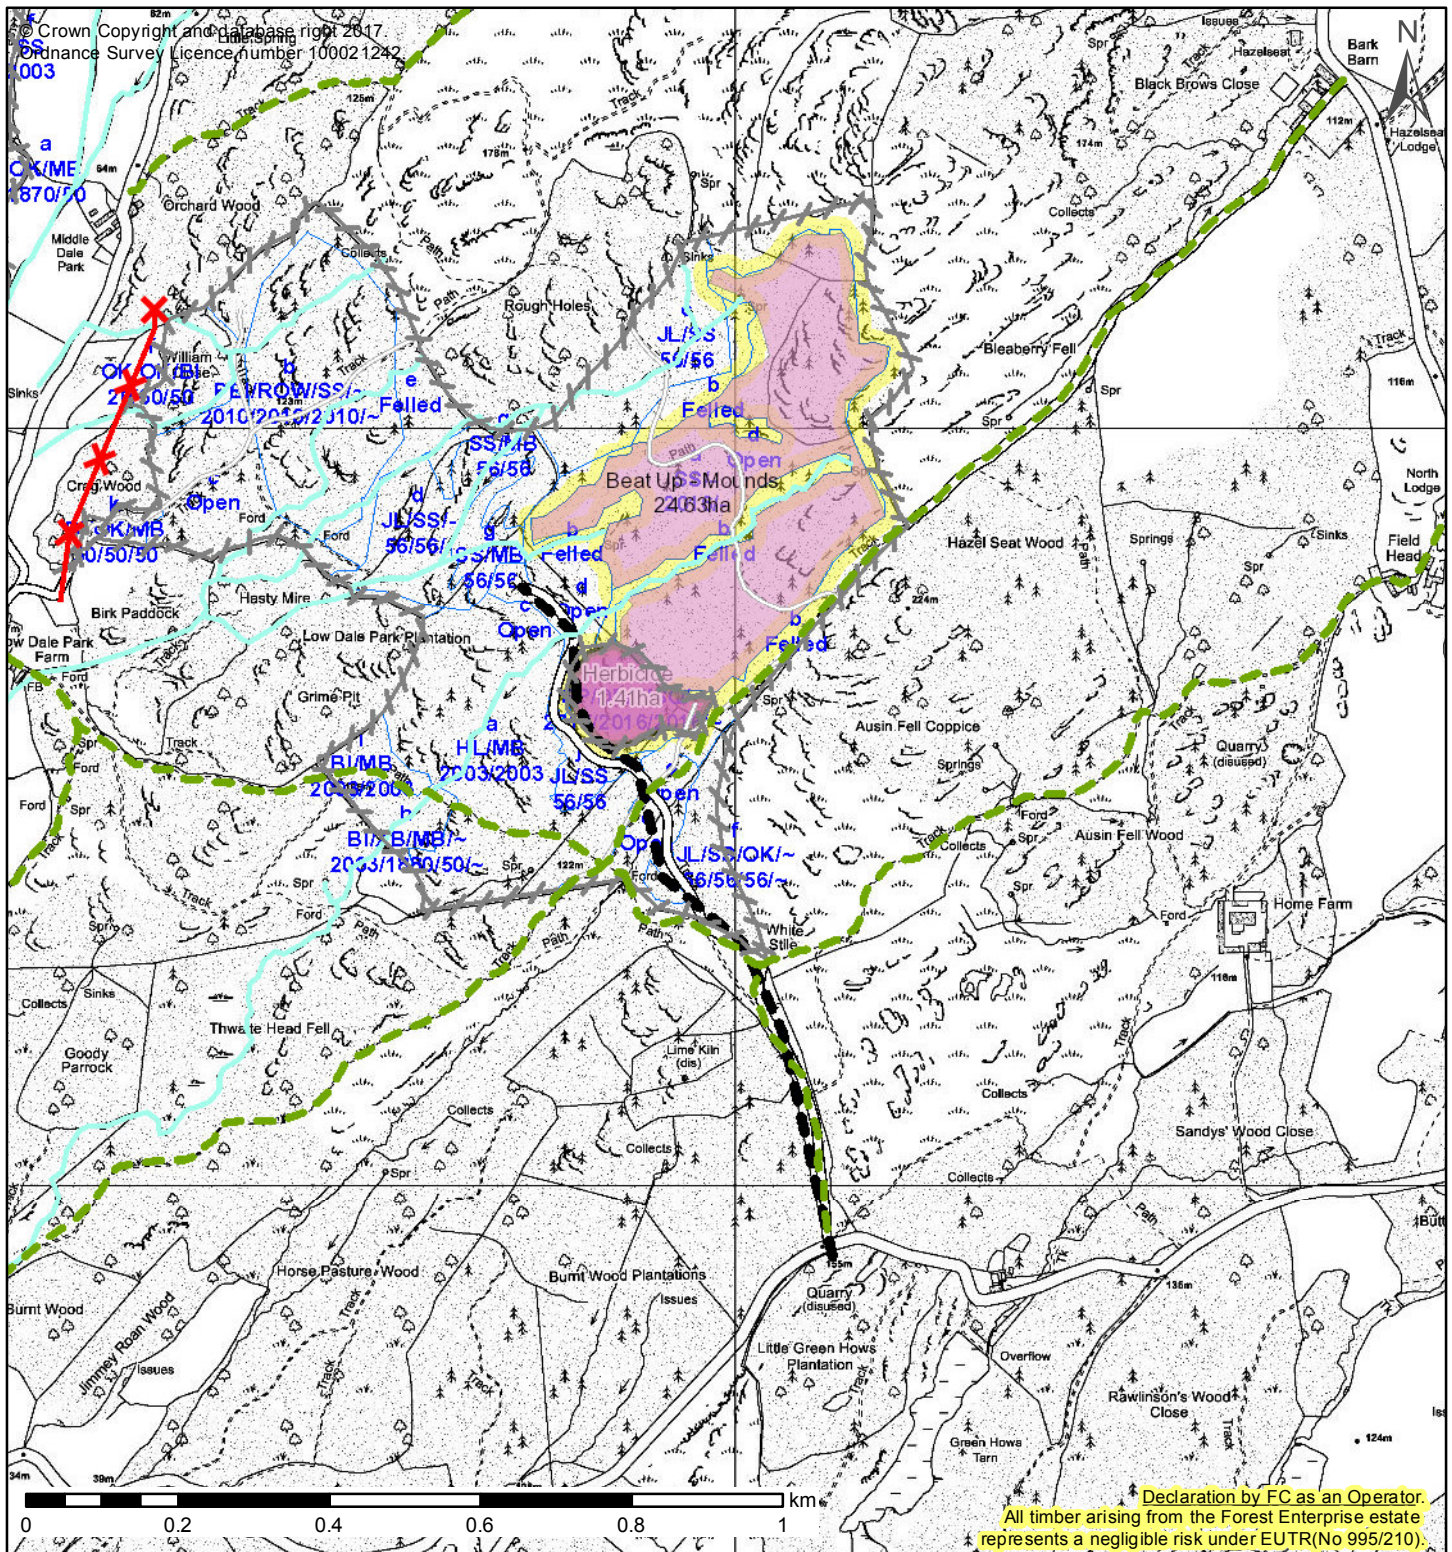

## 4. Operations

A4 Scale: 1:10,000

Forest District:	North England	Contract Type:	Eng. - Service - FM Maintenance - Vegetation Control
Contract Name:	grizedale planting beatup	Prepared By:	Joe Daniels
Contract No:	FEE/0467	Date Prepared:	23/10/2017
Framework/ Service Contract:		Contract Manager:	Joe Daniels
Extent Name:	Lowdale Park	Contract Status:	Open

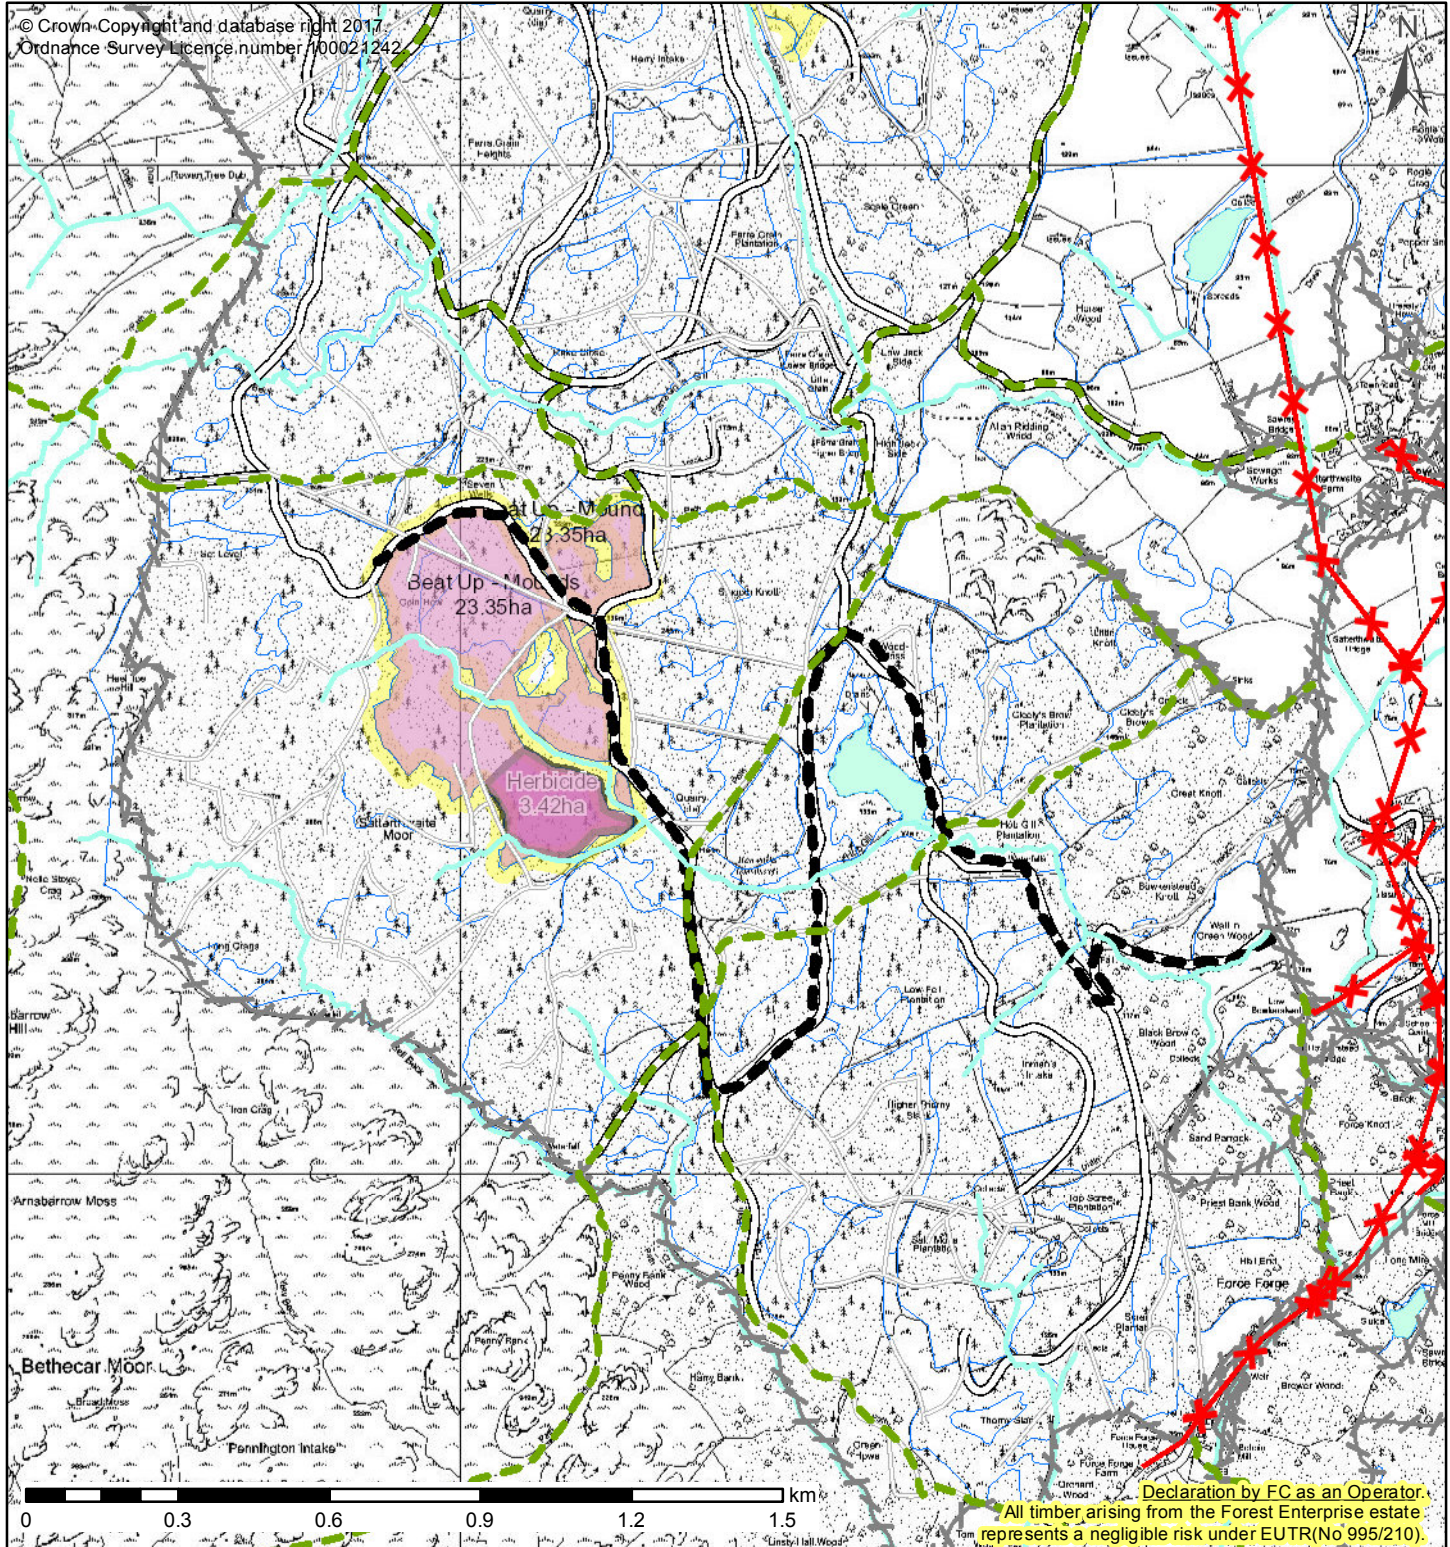


## 4. Operations

A4 Scale: 1:15,000

Forest District:	North England	Contract Type:	Eng. - Service - FM Maintenance - Vegetation Control
Contract Name:	grizedale planting beatup	Prepared By:	Joe Daniels
Contract No:	FEE/0467	Date Prepared:	23/10/2017
Framework/ Service Contract:		Contract Manager:	Joe Daniels
Extent Name:	Satt Moor	Contract Status:	Open

© Crown Copyright and database right 2017  
Ordnance Survey Licence number 100021242

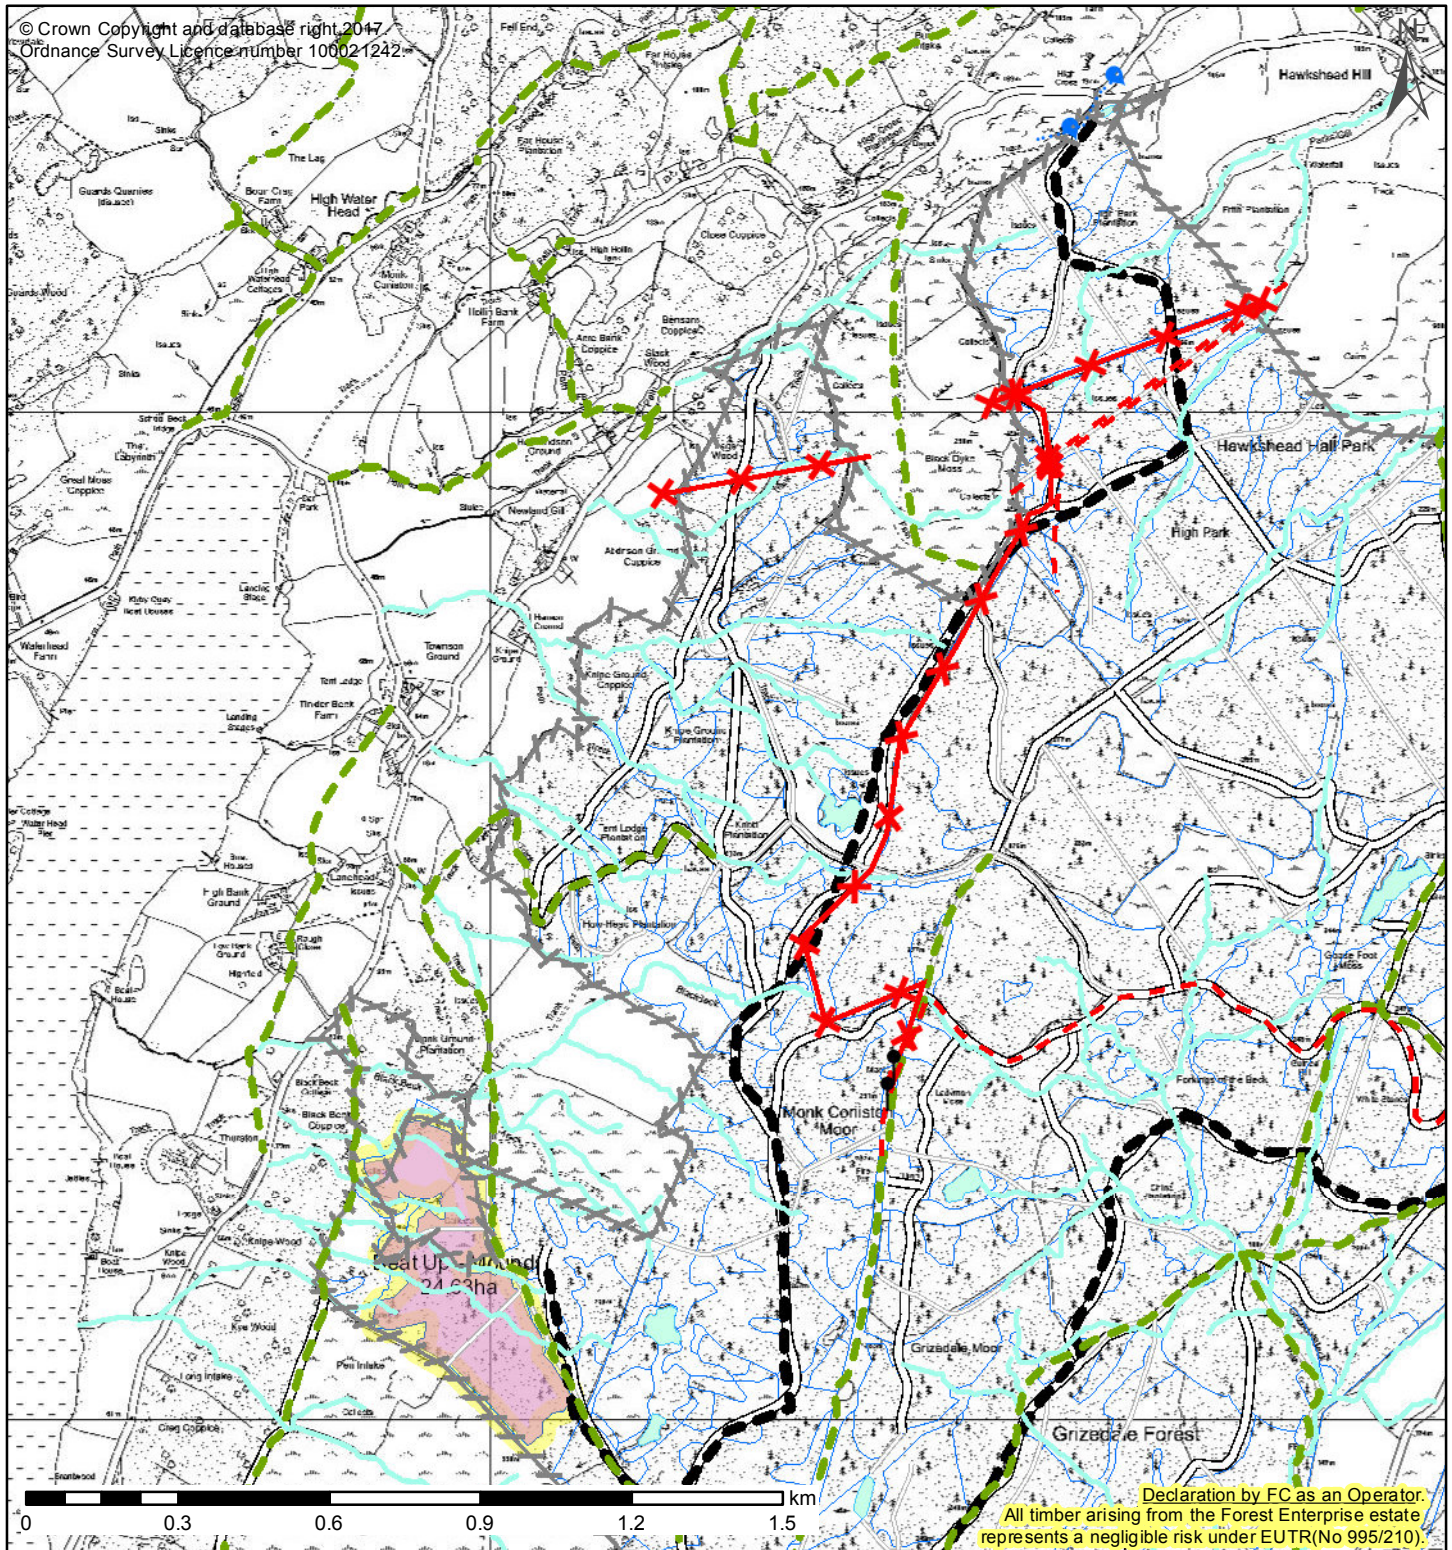

## 4. Operations

A4 Scale:1:15,000

Forest District:	North England	Contract Type:	Eng. - Service - FM Maintenance - Vegetation Control
Contract Name:	grizedale planting beatup	Prepared By:	Joe Daniels
Contract No:	FEE/0467	Date Prepared:	23/10/2017
Framework/ Service Contract:		Contract Manager:	Joe Daniels
Extent Name:	Thurstons	Contract Status:	Open

#### 4. Operations


grizedale planting beatup  
FEE/0467

	Signs - Prohibition		Sitka Spruce
	Signs - Threshold		Mix 1
	Signs - Warning/Diversion		Mix 2
	Signs - Other		Mix 3
	Site Parking		Mix 4
	Canopy Stores		Beat Up - Flat
	Masts/Aerials		Beat Up - Mounds
	Crossing Points		Beat Up - Screefing
	Overhead powerline		Direct Seeding
	Underground powerline		Mechanical Planter
	Gas Pipelines		Plant - Flat
	Water Pipelines		Plant - Mound
	Public Rights of Way (Eng.)		Plant - Screefing
	Overhead telephone or fibreoptic		Bracken (Chemical)
	Underground telephone or fibreoptic		Bracken (Physical)
	Access Track		Brashing
	Drain Maintenance		Burning
	New Drain		Grass Cutting
	Fences (Eng.)		Grazing
	Watercourses		Herbicide
	Forest Road Access Route		Machine Flail / Swipe
	Rides		Mechanical Weeding
	Roads		Mulching
	Steep Ground Areas		Re-spacing
	No Go Areas		Rhododendron (Chemical)
	Soft Ground Areas		Rhododendron (Other)
	Beech		Rhododendron (Physical)
	Douglas Fir		Strimmer
	Larch		Quarries
	Oak		Open Water
	Other Broadleaf		Sub-compartments
	Other Conifer		Contract Areas
	Pine		Contract Outline
	Spruce		Contract Areas

#### 4. Operations

grizedale planting beatup

FEE/0467

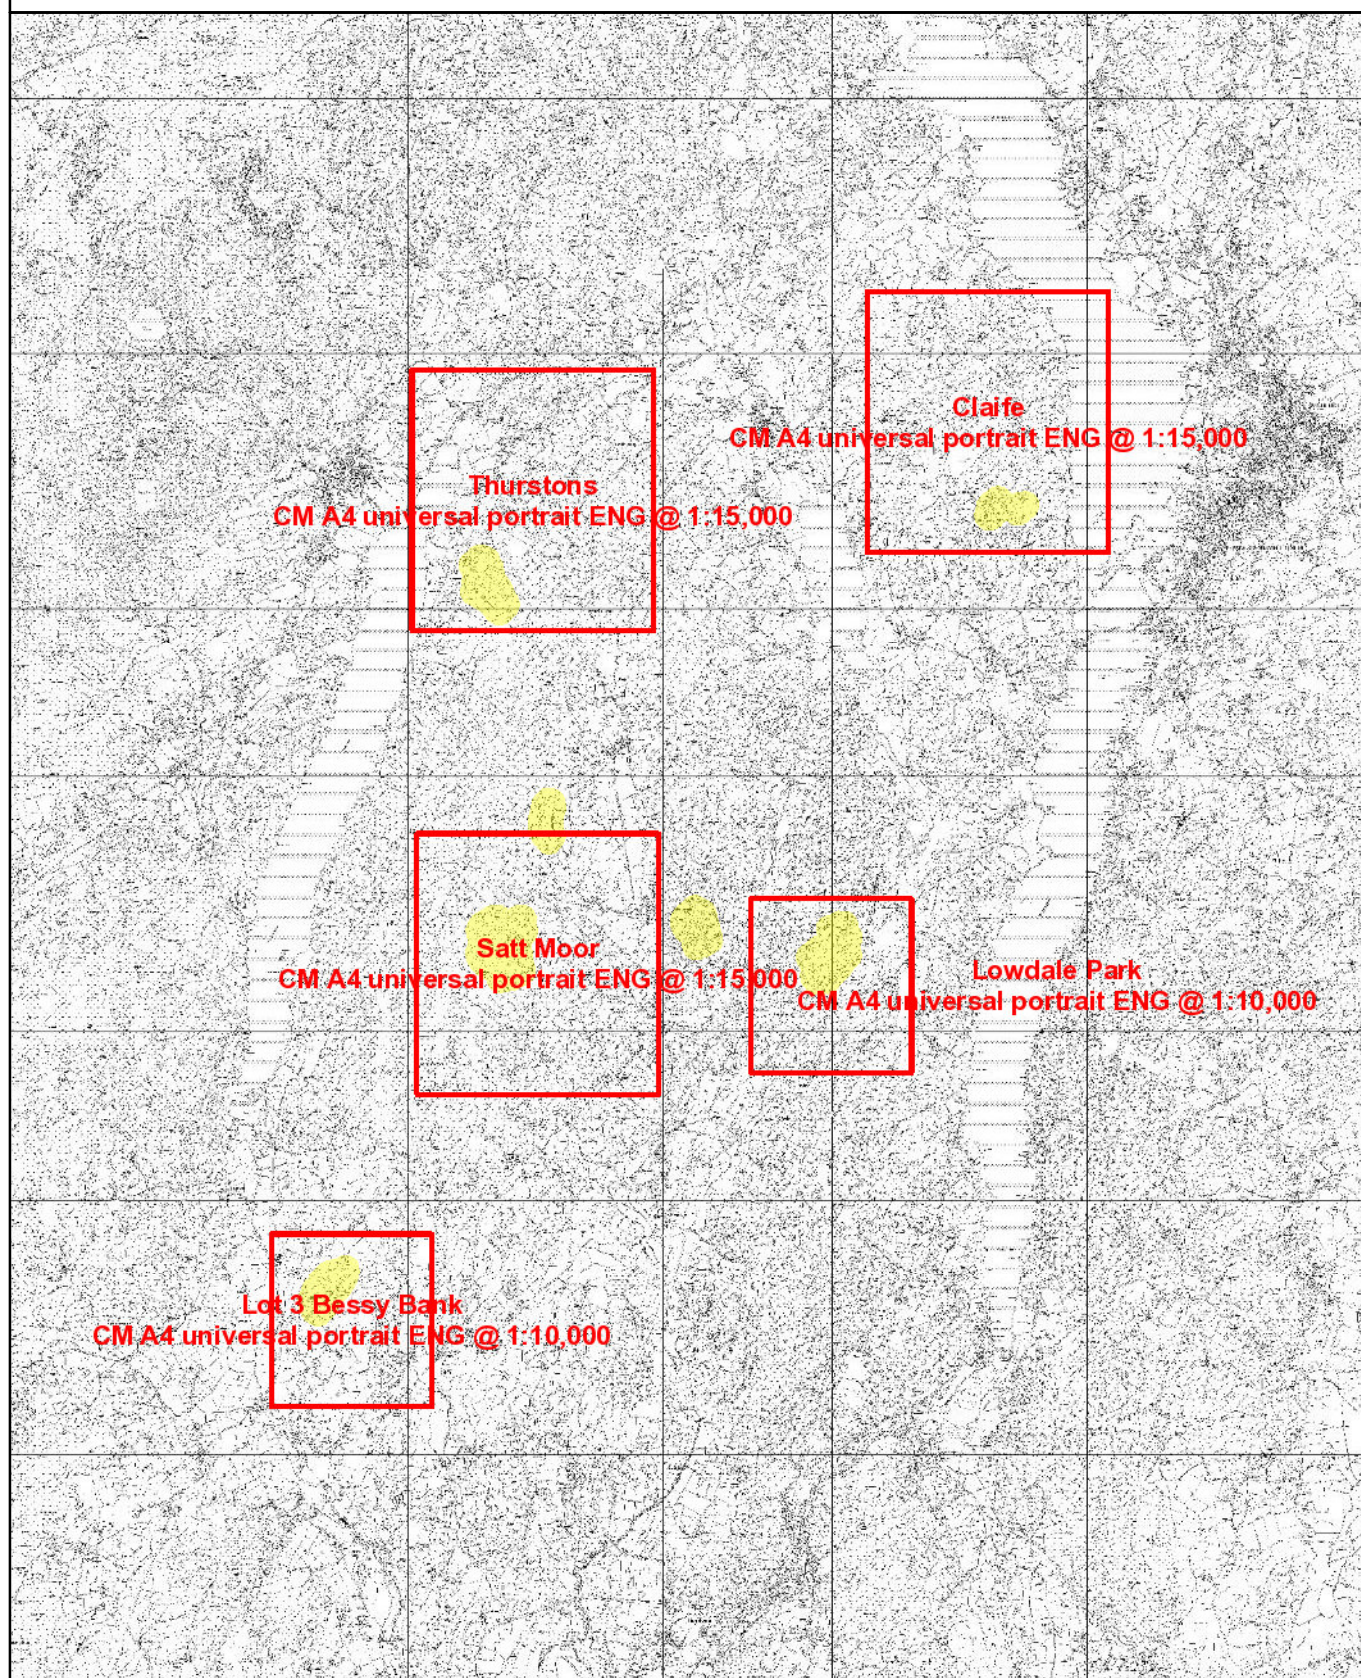

Contract Areas

Contract Outline



Contract Areas